

ADDRESS:  
Interception of George Apyad with Abd-Elwareth Asr St  
9th district Nasr city

CLIENT NAME:

Eng/ Ashraf Farag

TELEPHONE #:  
(+20)1001689916

PROJECT NAME:

DRAWINGS TITLE:

Sheet Size: A3

Rev : 0

DRAWN BY:

Ahmed Hesham  
TELEPHONE #:  
(+20)1116030118

SCALE:


APPROVED BY:

Hesham Zayed  
TELEPHONE #:  
(+20)102032244

DATE: 22-08-2022

DESCRIPTION:

Furniture Plan

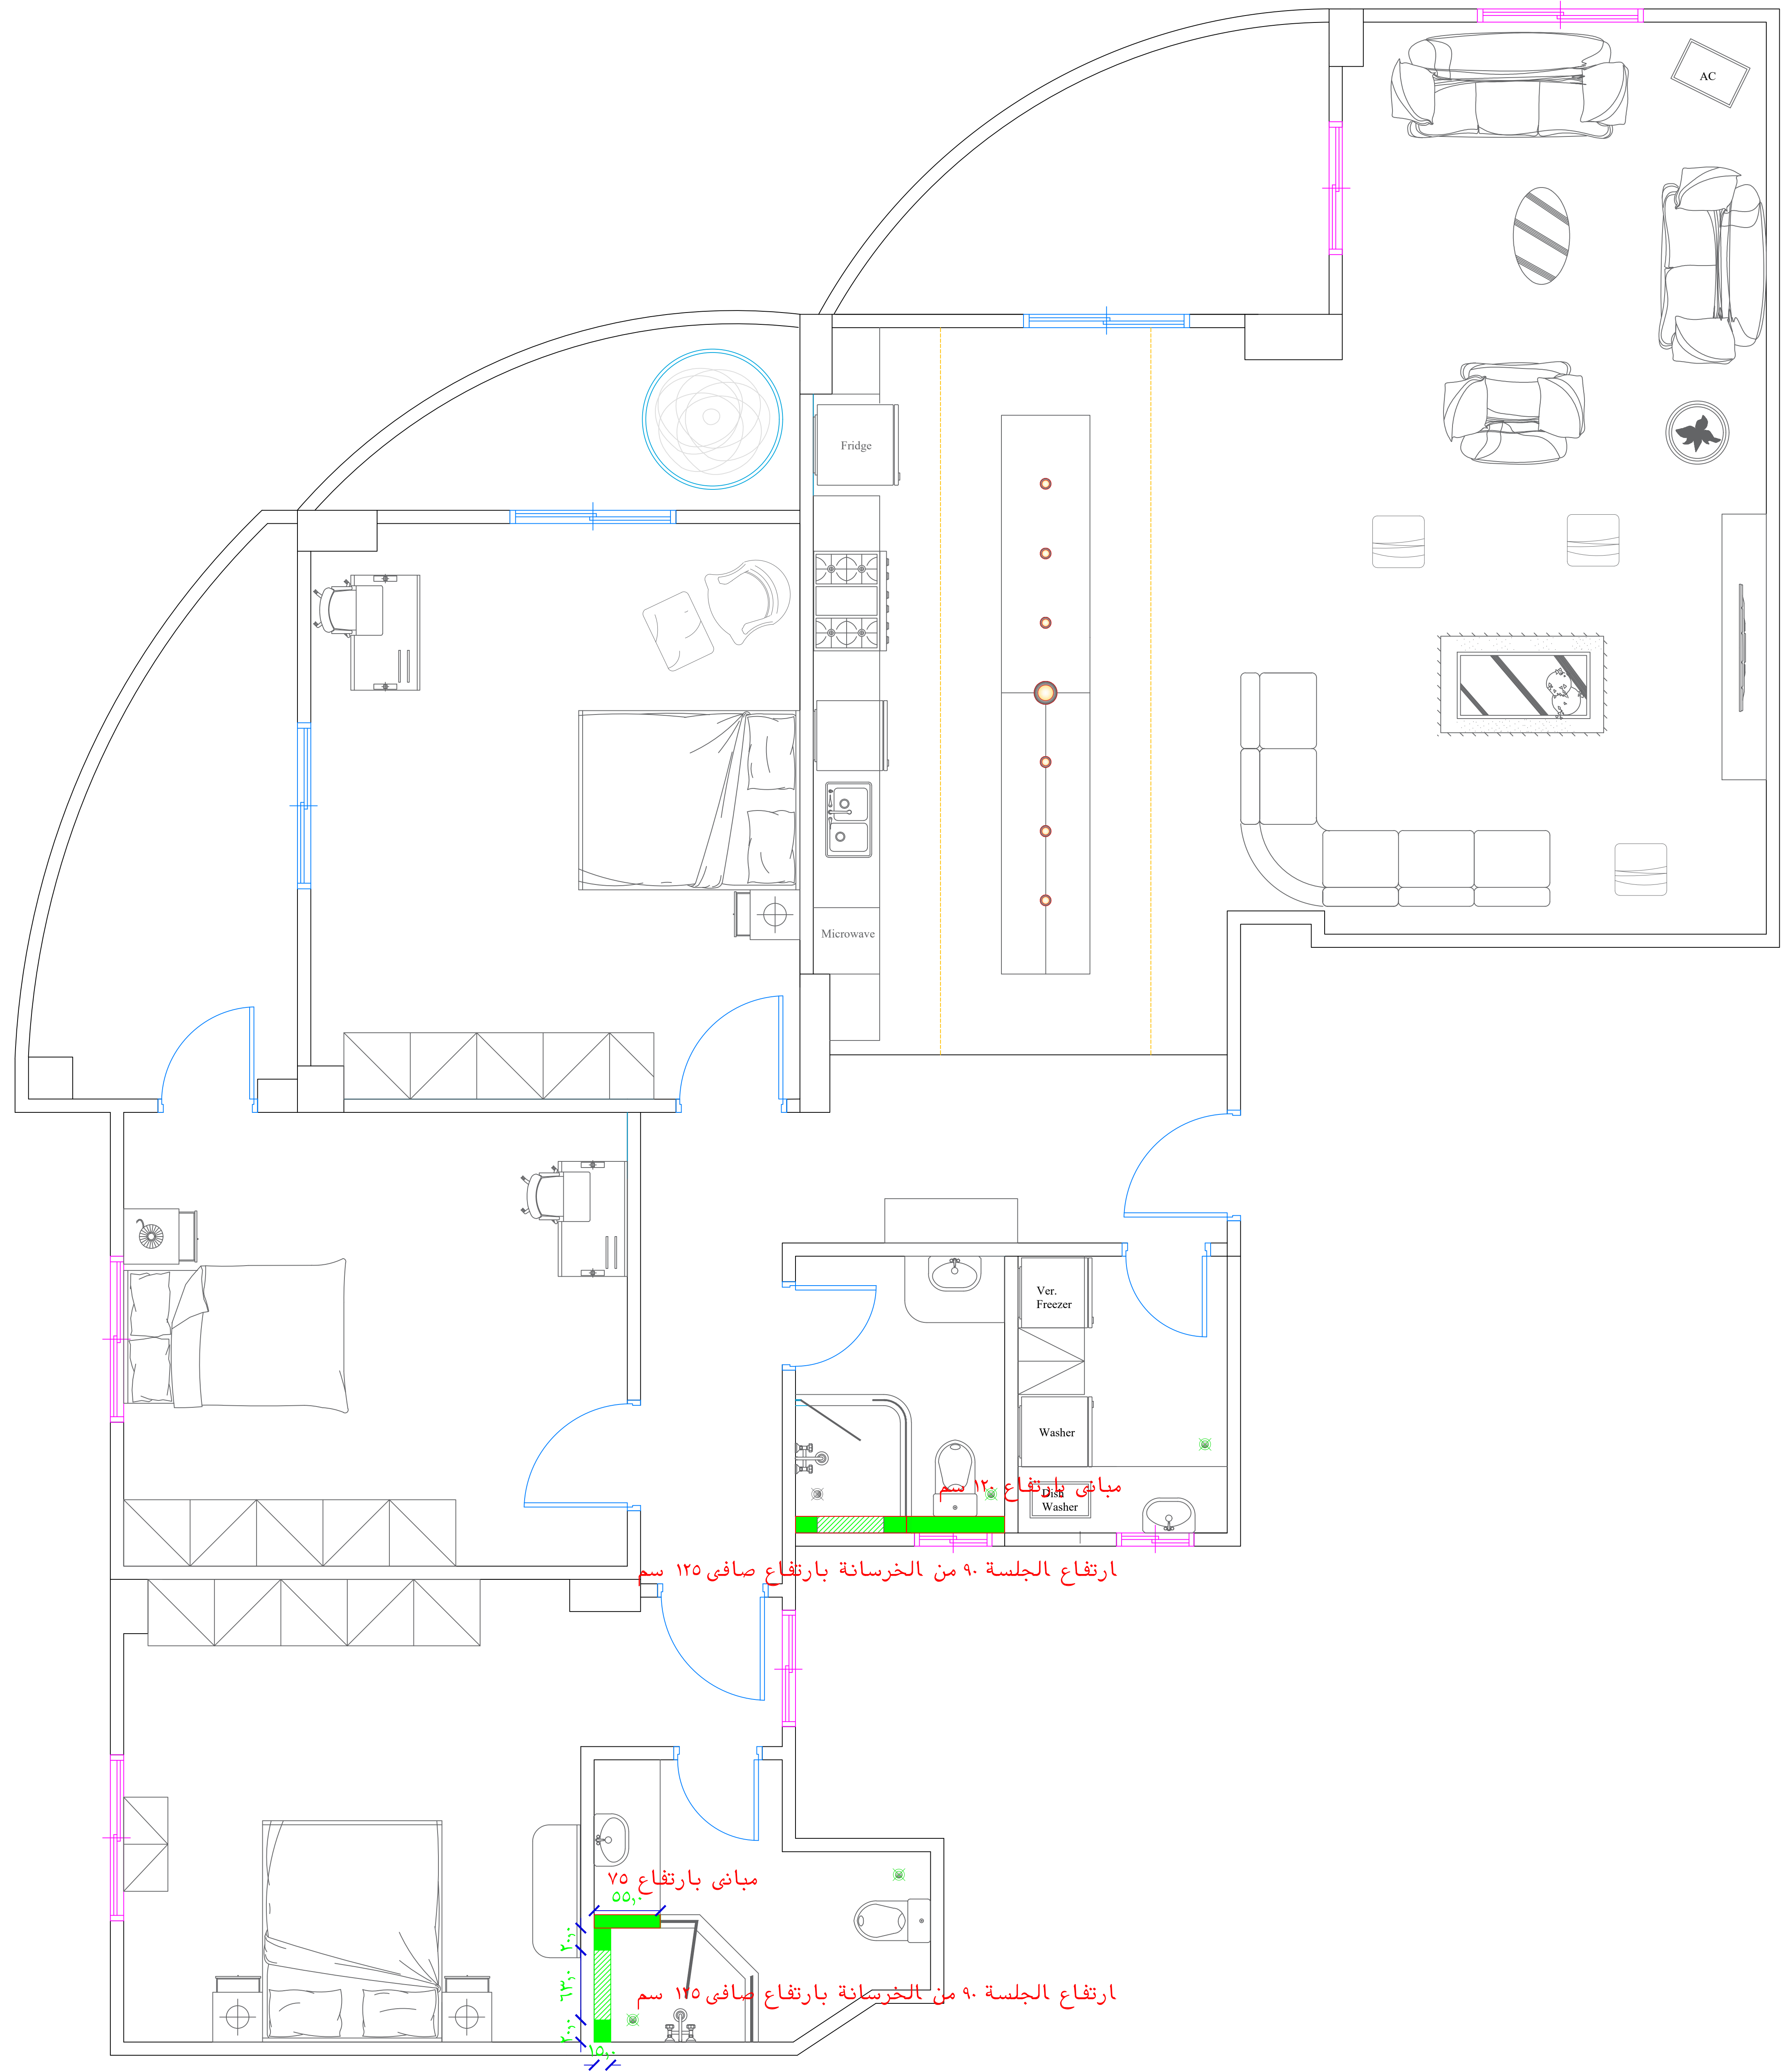

ADDRESS:  
Interception of George Apyad with Abd-Elwareth Asr St  
9th district Nasr city

CLIENT NAME:

PROJECT NAME:

DRAWINGS TITLE:

DRAWN BY:

APPROVED BY:

DESCRIPTION:

Eng/ Ashraf Farag

TELEPHONE #:  
(+20)1001689916

Ahmed Hesham

TELEPHONE #:  
(+20)1116030118

SCALE:

Hesham Zayed


TELEPHONE #:  
(+20)102032244

DATE: 10-09-2022

Masonry Plan

Sheet Size: A3

Rev : 0

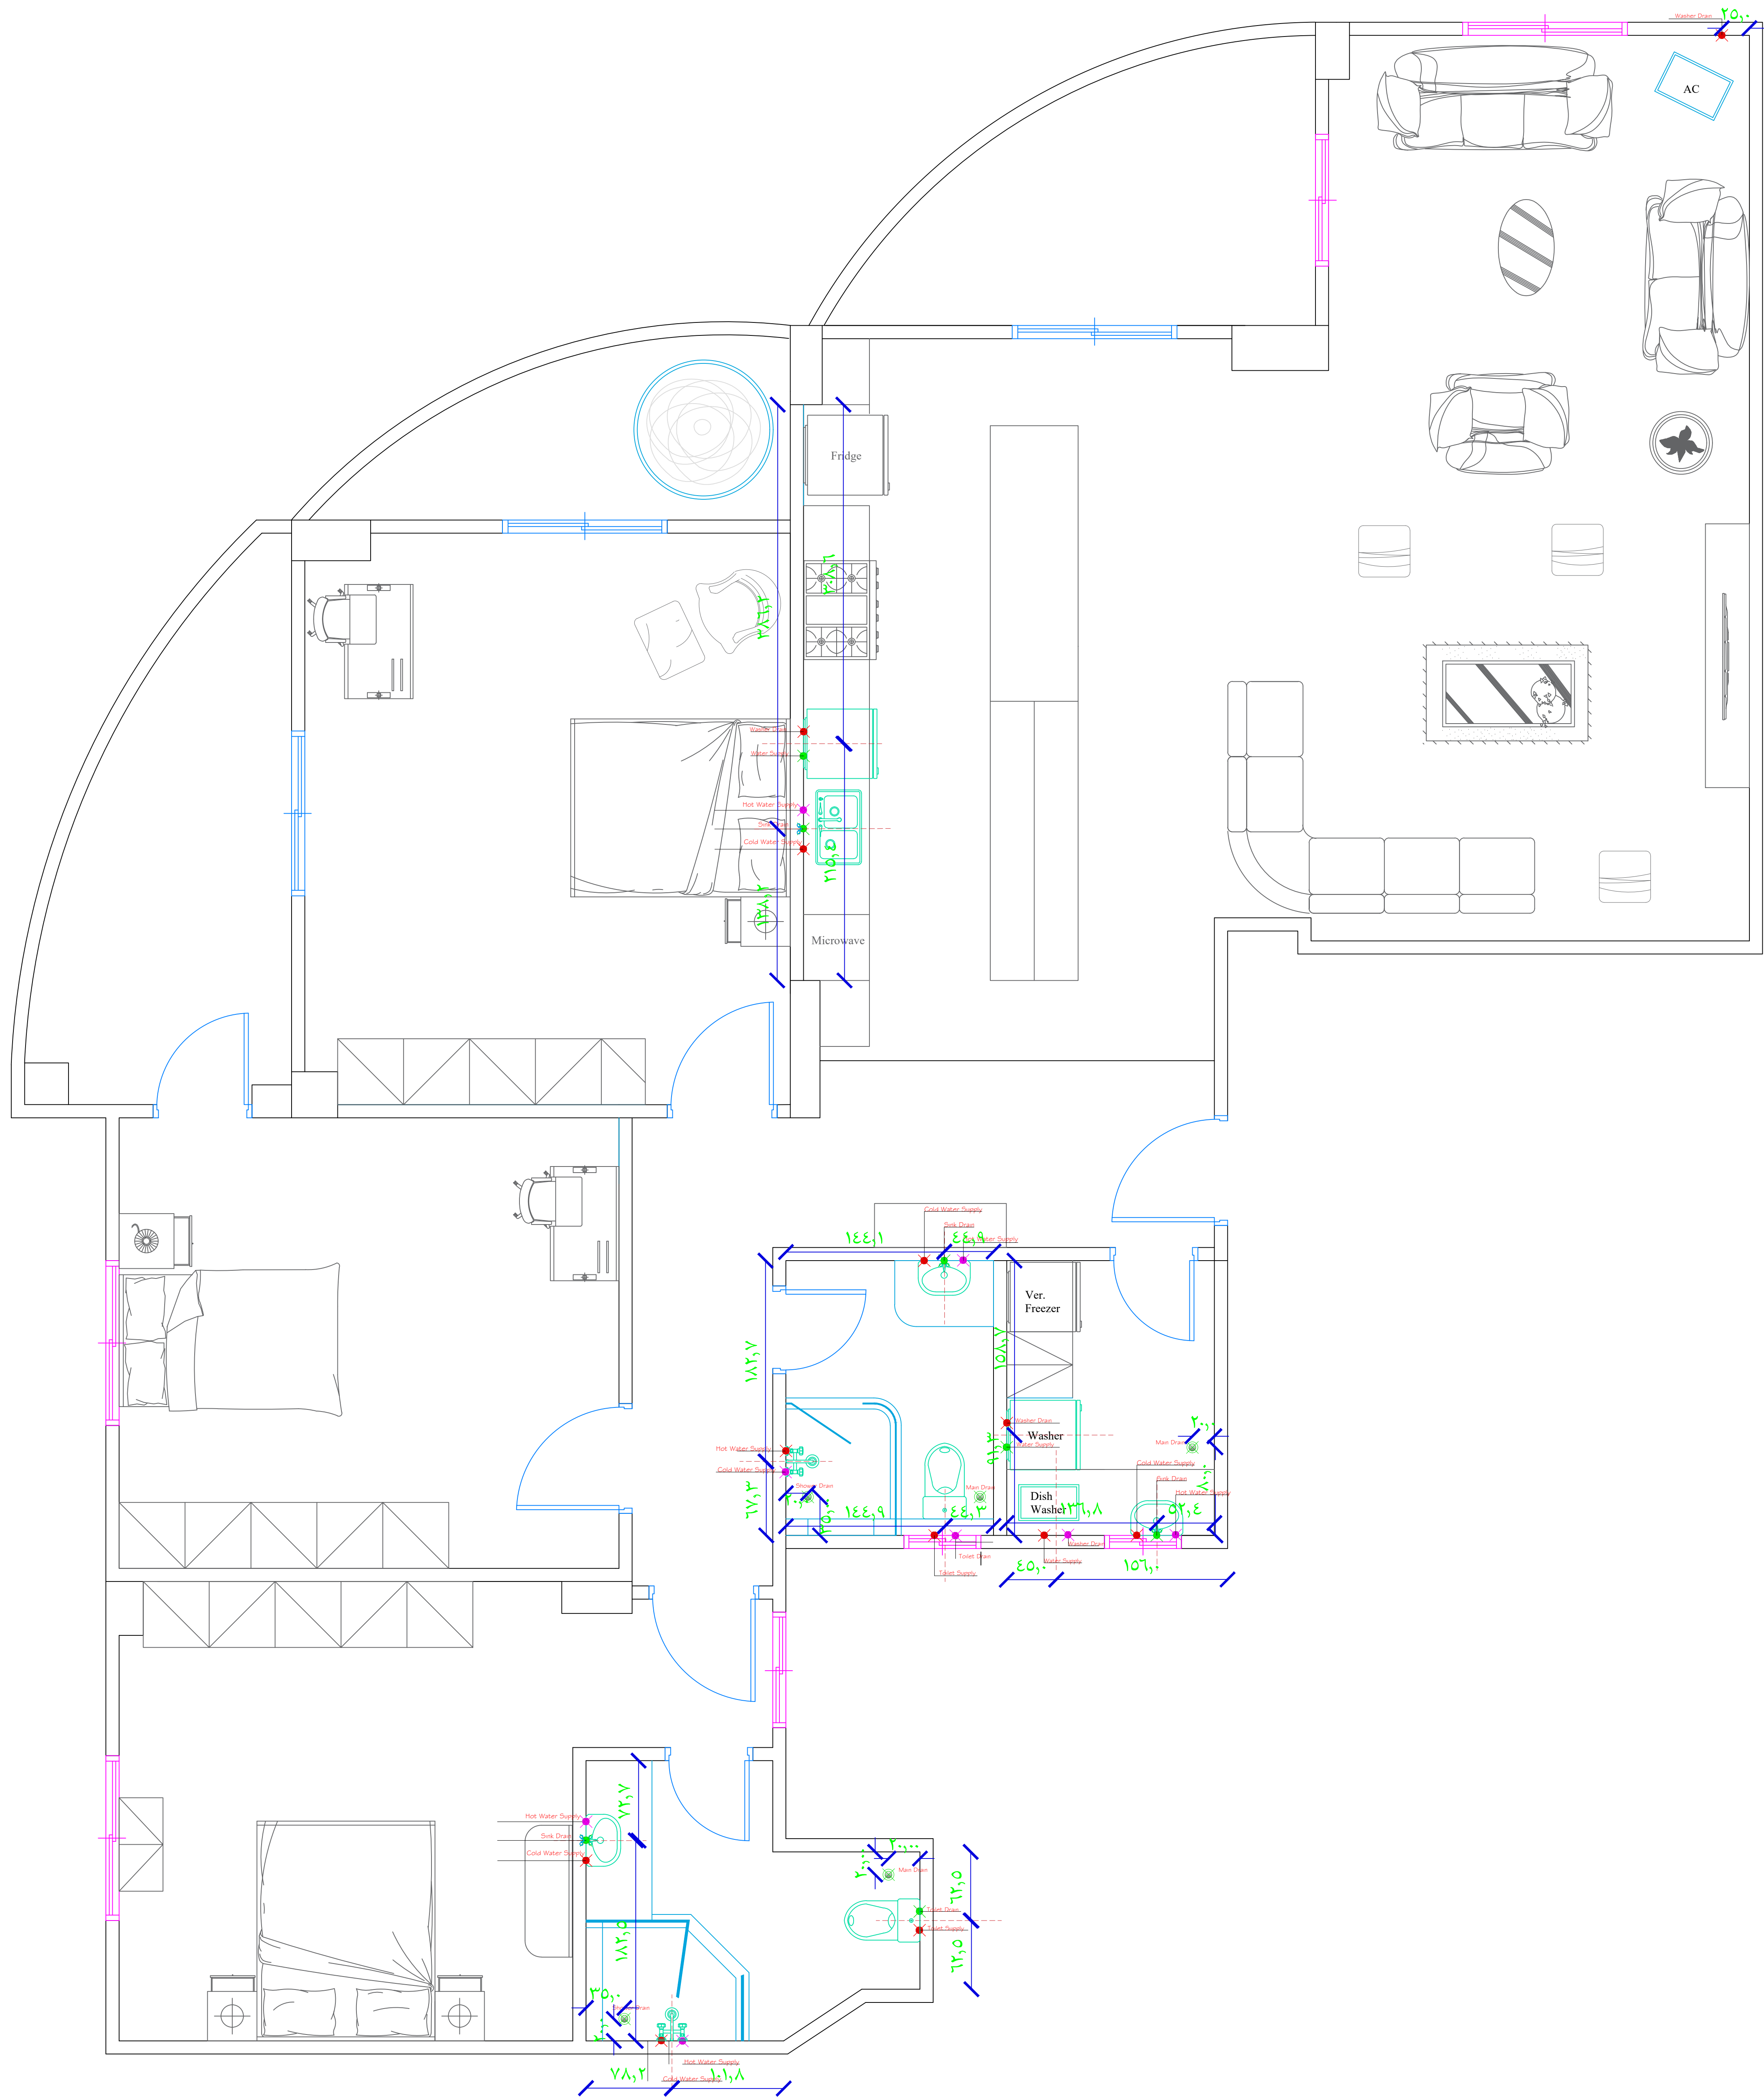

ADDRESS:  
Interception of George Apyad with Abd-Elwareth Asr St  
9th district Nasr city

CLIENT NAME:

Eng/ Ashraf Farag

TELEPHONE #:  
(+20)1001689916

PROJECT NAME:

DRAWINGS TITLE:

Sheet Size: A3

Rev : 0

DRAWN BY:

Ahmed Hesham  
TELEPHONE #:  
(+20)1116030118

SCALE:

APPROVED BY:


Hesham Zayed  
TELEPHONE #:  
(+20)102032244

DATE: 22-08-2022

DESCRIPTION:

Plumbing Plan



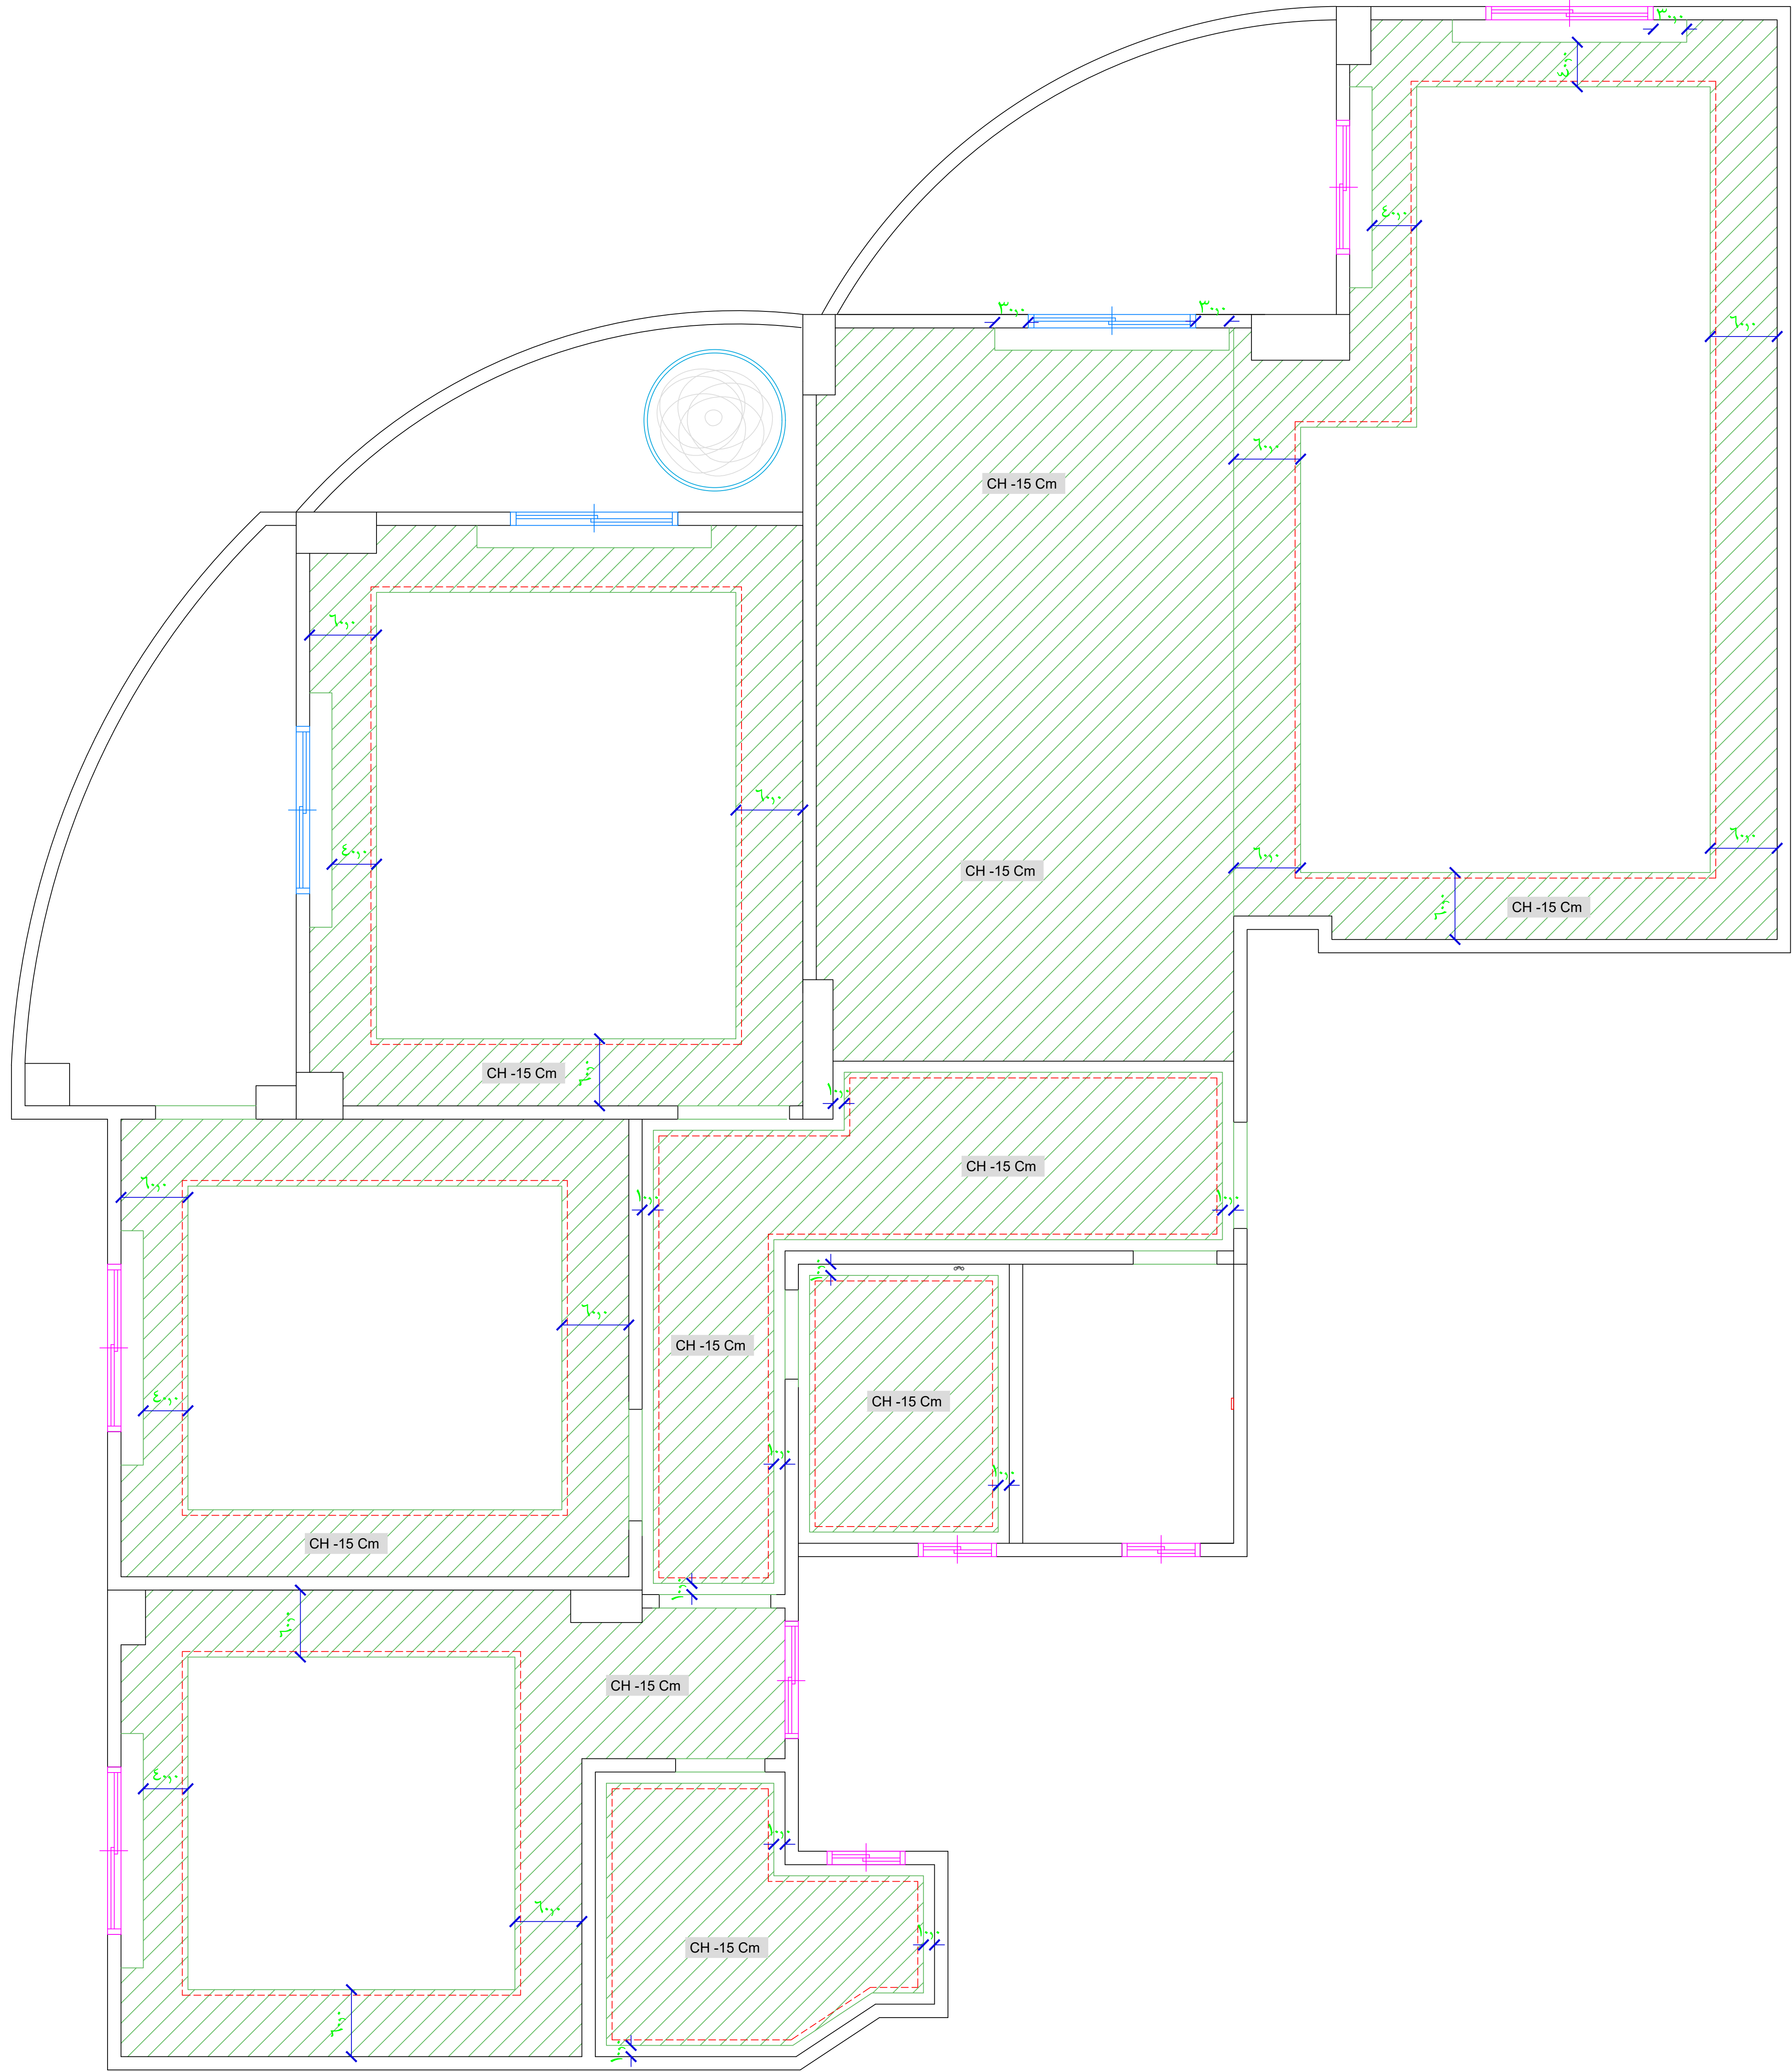

ADDRESS:  
Interception of George Apyad with Abd-Elwareth Asr St  
9th district Nasr city

CLIENT NAME:

Eng/ Ashraf Farag

TELEPHONE #:  
(+20)1001689916

PROJECT NAME:

DRAWINGS TITLE:

Sheet Size: A3

Rev : 0

DRAWN BY:

Ahmed Hesham  
TELEPHONE #:  
(+20)1116030118

SCALE:


APPROVED BY:

Hesham Zayed  
TELEPHONE #:  
(+20)1020232244

DATE: 04-09-2022

DESCRIPTION:

Gypsum Board Ceiling Plan

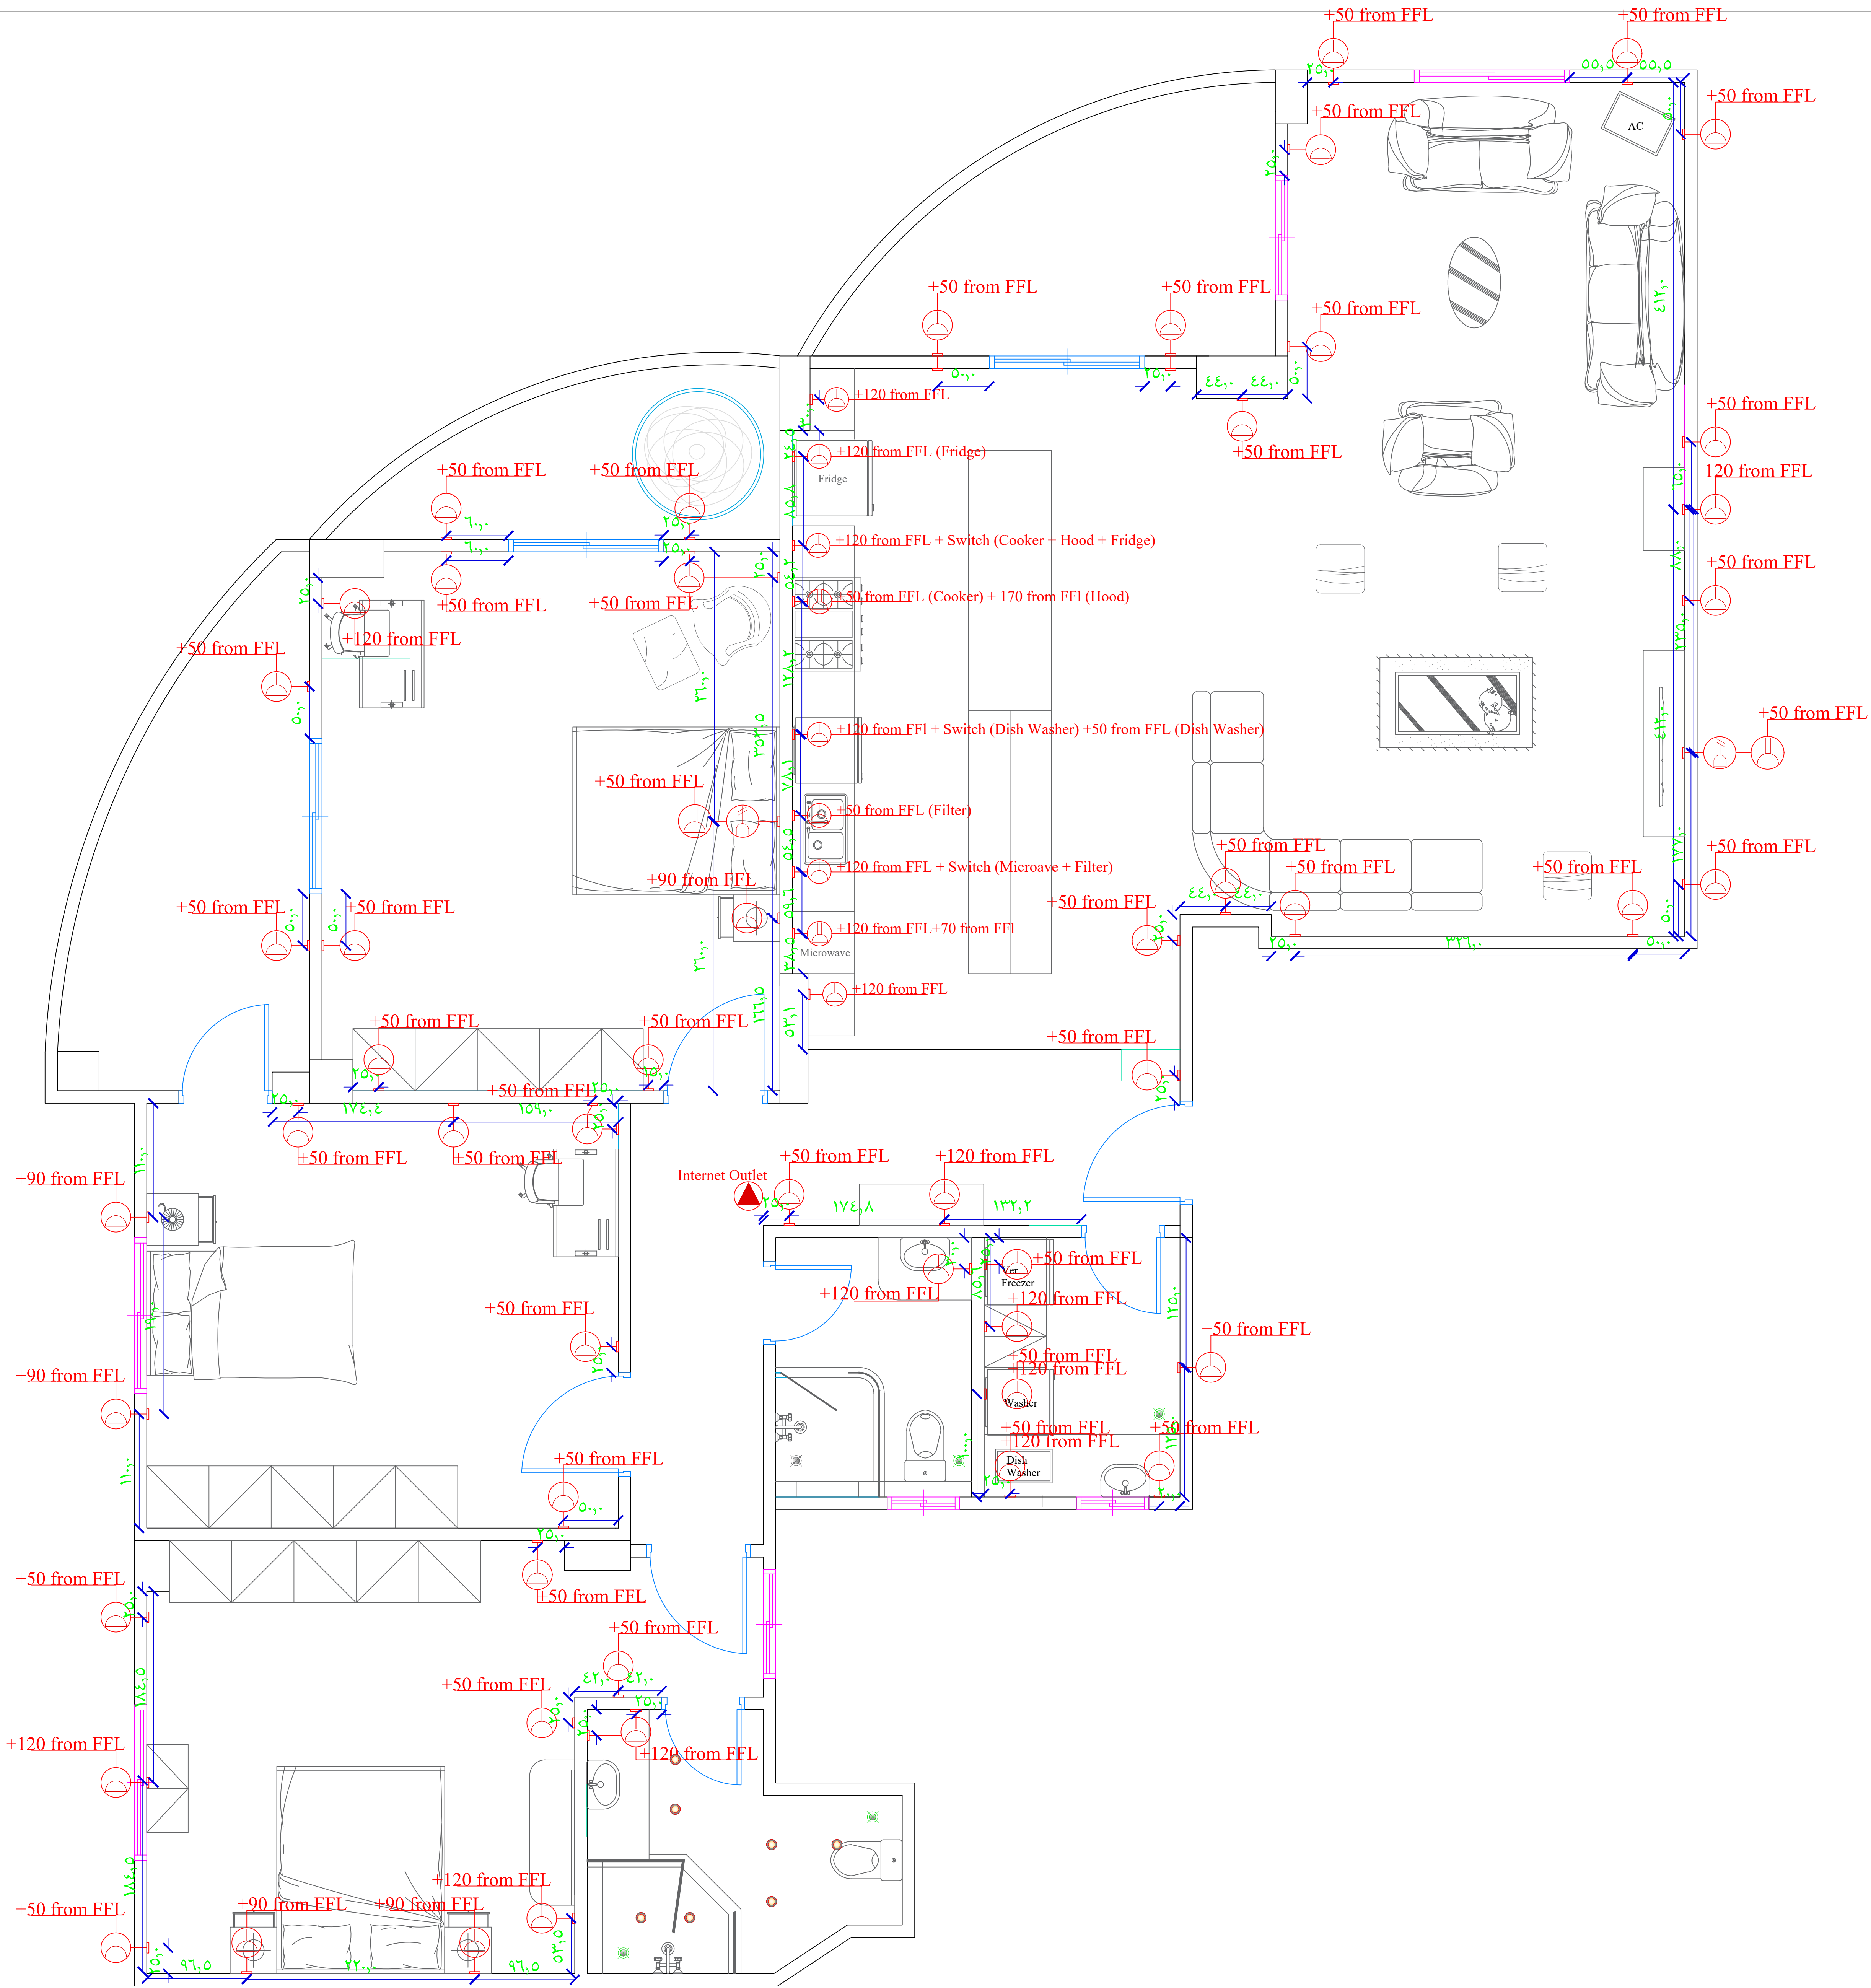

ADDRESS:  
Interception of George Apyad with Abd-Elwareth Asr St  
9th district Nasr city

CLIENT NAME:

PROJECT NAME:

DRAWINGS TITLE:

DRAWN BY:

APPROVED BY:

DESCRIPTION:

Eng/ Ashraf Farag

TELEPHONE #:  
(+20)1001689916

Ahmed Hesham  
TELEPHONE #:  
(+20)1116030118

Hesham Zayed  
TELEPHONE #:  
(+20)102032244

Power Plan


Sheet Size: A3

SCALE:

DATE: 05-09-2022

Rev : 0



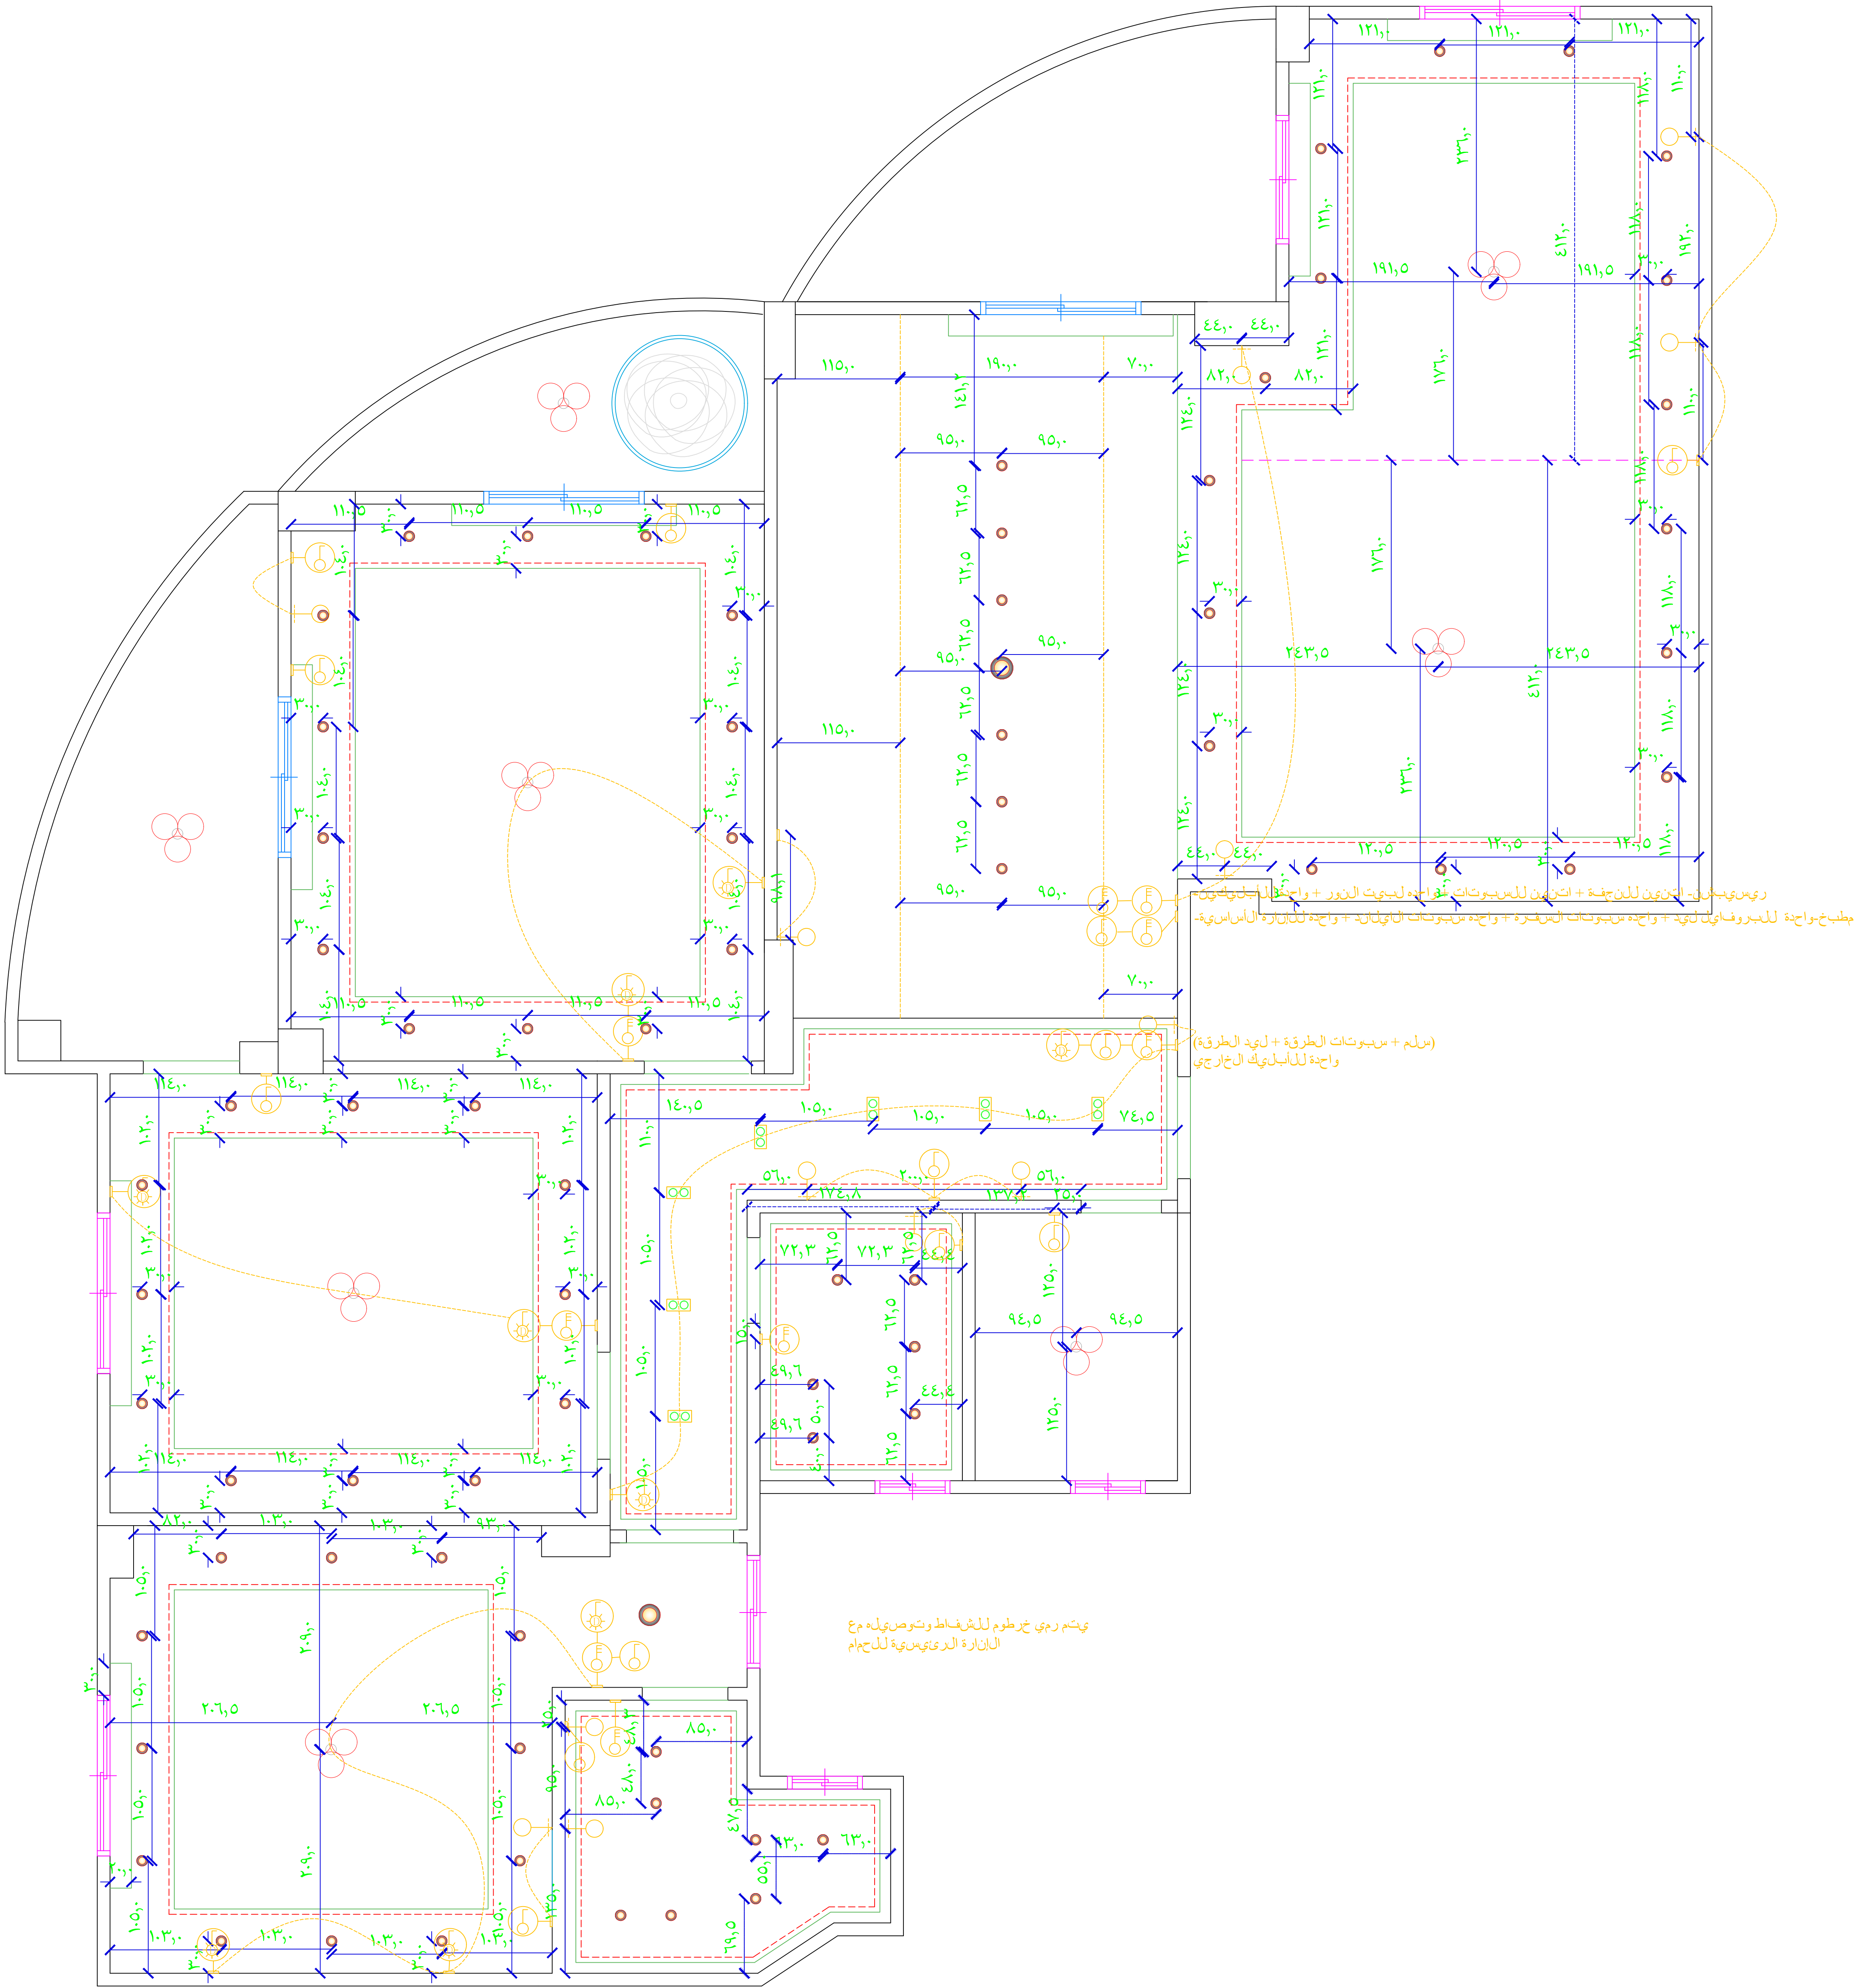

Lighting Switches

Symbol	Designation
	Electrical single switch (110 cm)h
	Electrical double switch (110 cm)h
	Electrical Three way Switch (110 cm)h
	Lighting Outlet
	DEVIATOR switch (110 cm)H

ADDRESS:  
Interception of George Apyad with Abd-Elwareth Asr St  
9th district Nasr city

CLIENT NAME:

Eng/ Ashraf Farag

TELEPHONE #:  
(+20)1001689916

PROJECT NAME:

DRAWINGS TITLE:

Sheet Size: A3

Rev : 0

DRAWN BY:

Ahmed Hesham  
TELEPHONE #:  
(+20)1116030118

SCALE:

APPROVED BY:

Hesham Zayed  
TELEPHONE #:  
(+20)1020232244  
DATE: 07-09-2022

DESCRIPTION:

lighting & Switches &  
Lighting Tracks Plan