




ADDRESS: 3 Hossam El-deen Bassiouny ST. Block No.29 - 9th district Nasr city	CLIENT NAME:	PROJECT NAME:	DRAWINGS TITLE:	DRAWN BY:	APPROVED BY:	DESCRIPTION: General Layout
	Ahmed Gamal	Elsafwa Tower		Ahmed Hesham	Hesham Zayed	
	TELEPHONE #: (+20)1020325050		Sheet Size: A3	TELEPHONE #: (+20)1116030118	TELEPHONE #: (+20)102032244	
			Rev : 0	SCALE:	DATE: 9-11-2021	

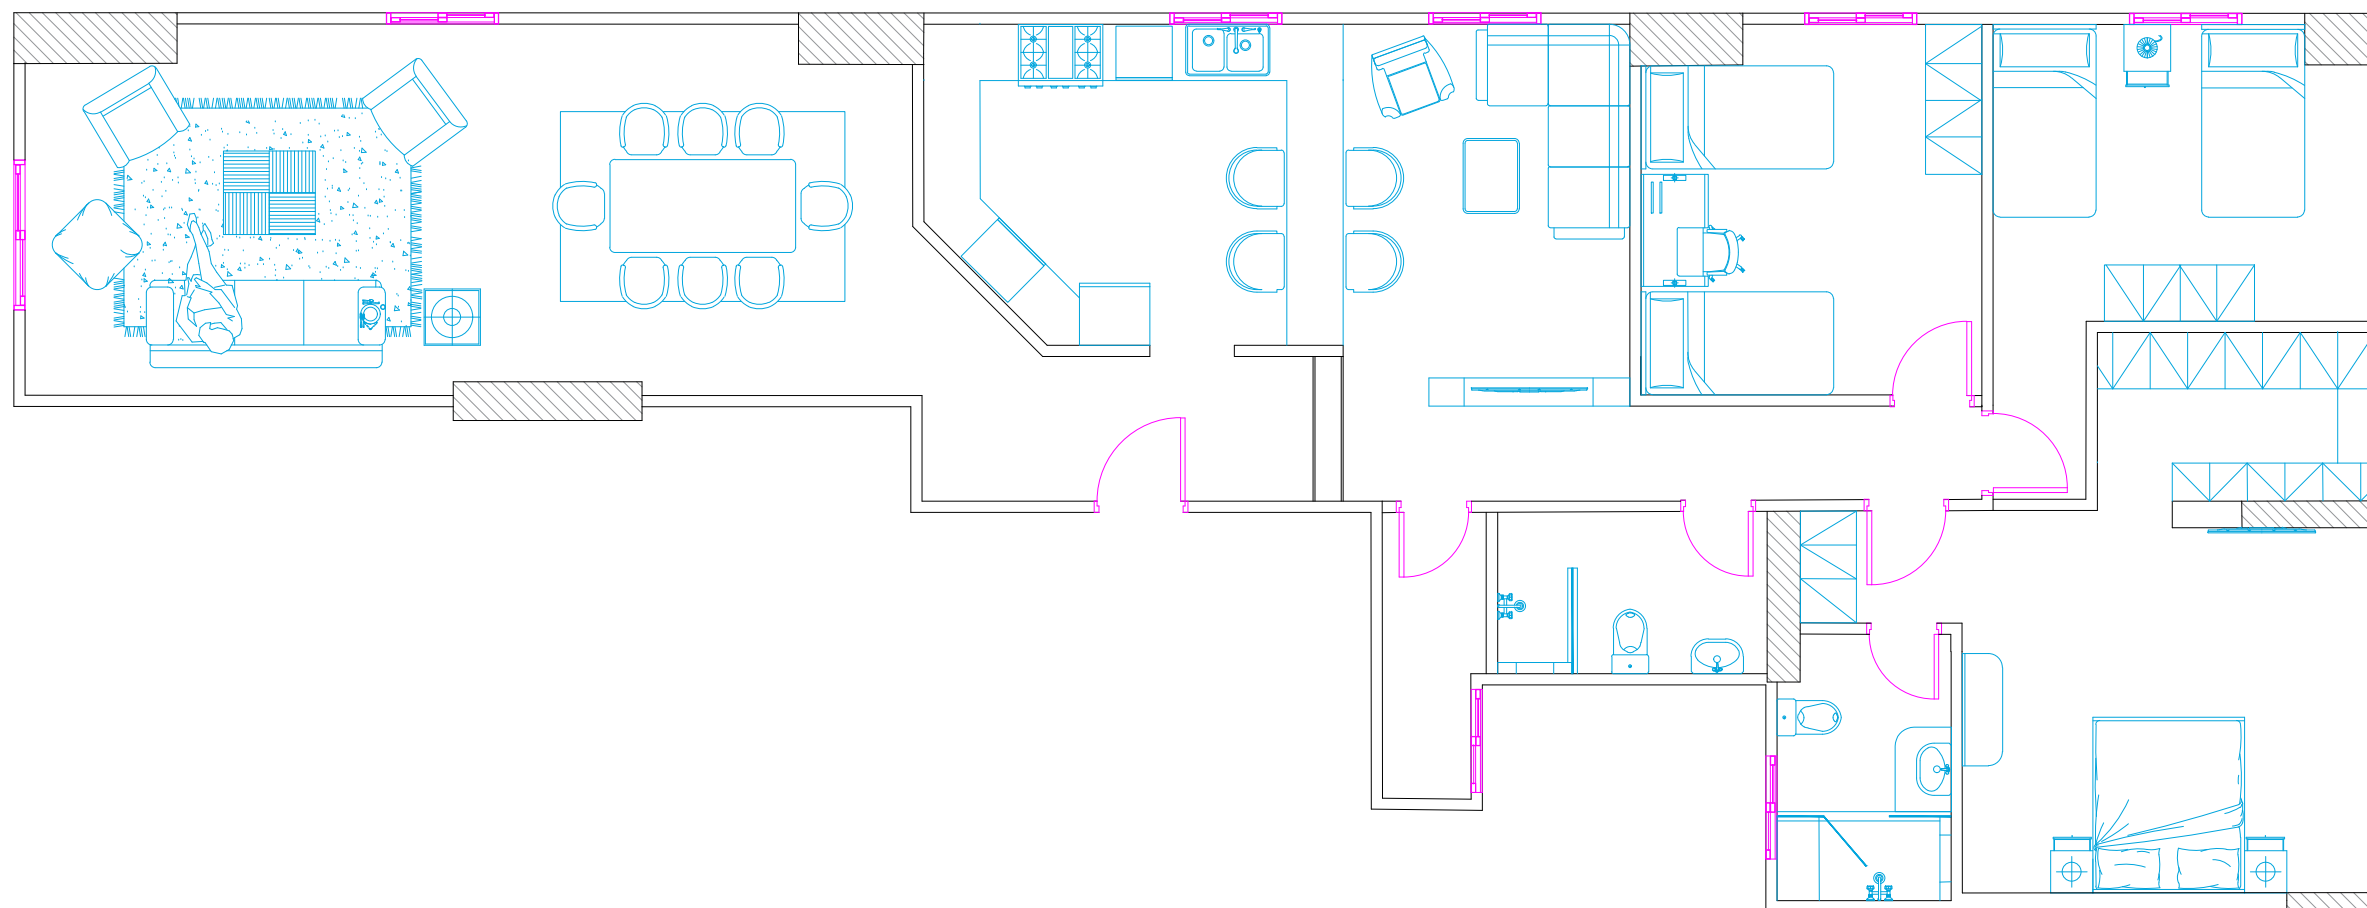



ADDRESS: 3 Hossam El-deen Bassiouny ST. Block No.29 - 9th district Nasr city	CLIENT NAME:	PROJECT NAME:	DRAWINGS TITLE:	DRAWN BY:	APPROVED BY:	DESCRIPTION: Furniture Plan
	Ahmed Gamal	Elsafwa Tower		Ahmed Hesham TELEPHONE #: (+20)1116030118	Hesham Zayed TELEPHONE #: (+20)1020232244	
	TELEPHONE #: (+20)1020325050		Sheet Size: A3	SCALE:	DATE: 12-11-2021	
			Rev : 0			

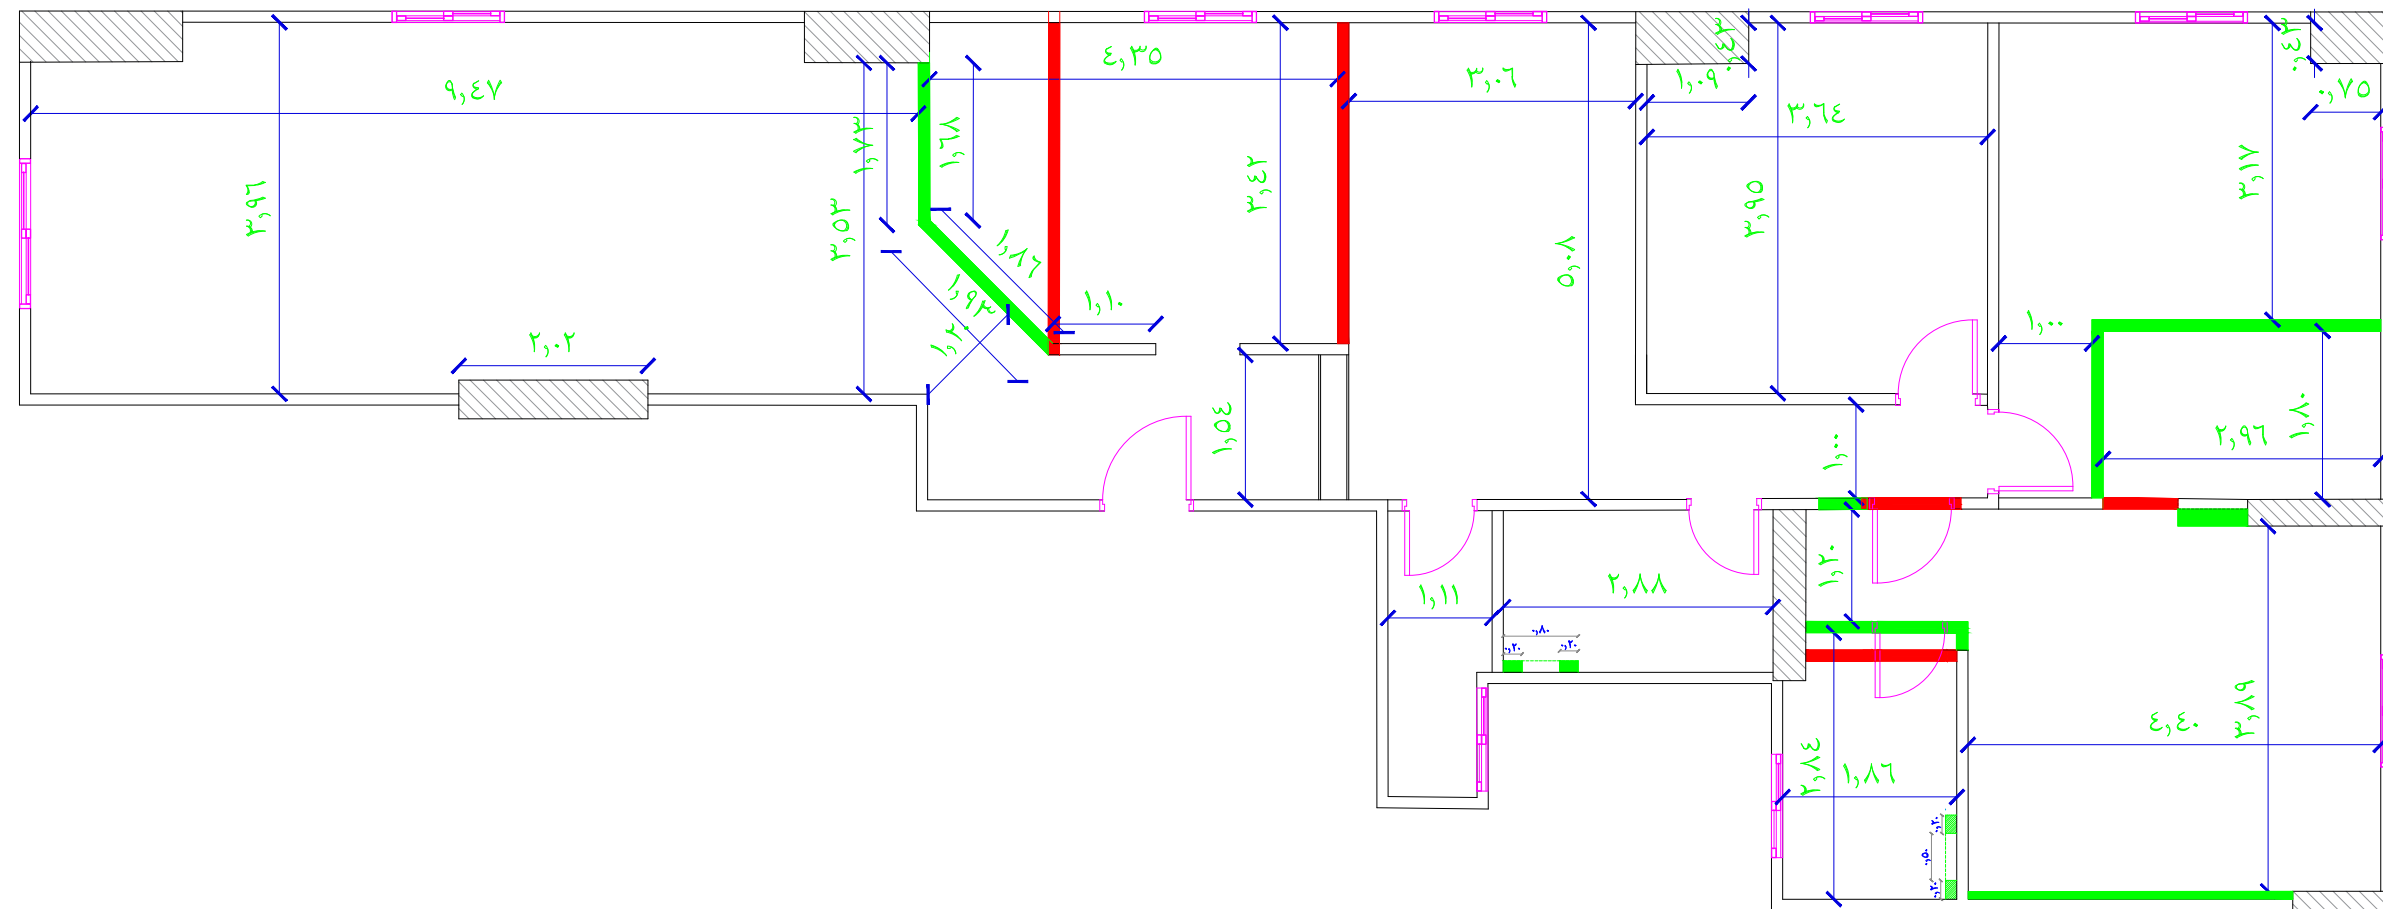

ADDRESS: 3 Hossam El-deen Bassiouny ST. Block No.29 - 9th district Nasr city	CLIENT NAME:	PROJECT NAME:	DRAWINGS TITLE:	DRAWN BY:	APPROVED BY:	DESCRIPTION:
	Ahmed Gamal	Elsafwa Tower		Ahmed Hesham	Hesham Zayed	Demolition plan <div> <div>Removed</div> <div>Built</div> </div>
	TELEPHONE #: (+20)1020325050		Sheet Size: A3	TELEPHONE #: (+20)1116030118	TELEPHONE #: (+20)102032244	
			Rev : 0	SCALE:	DATE: 9-11-2021	

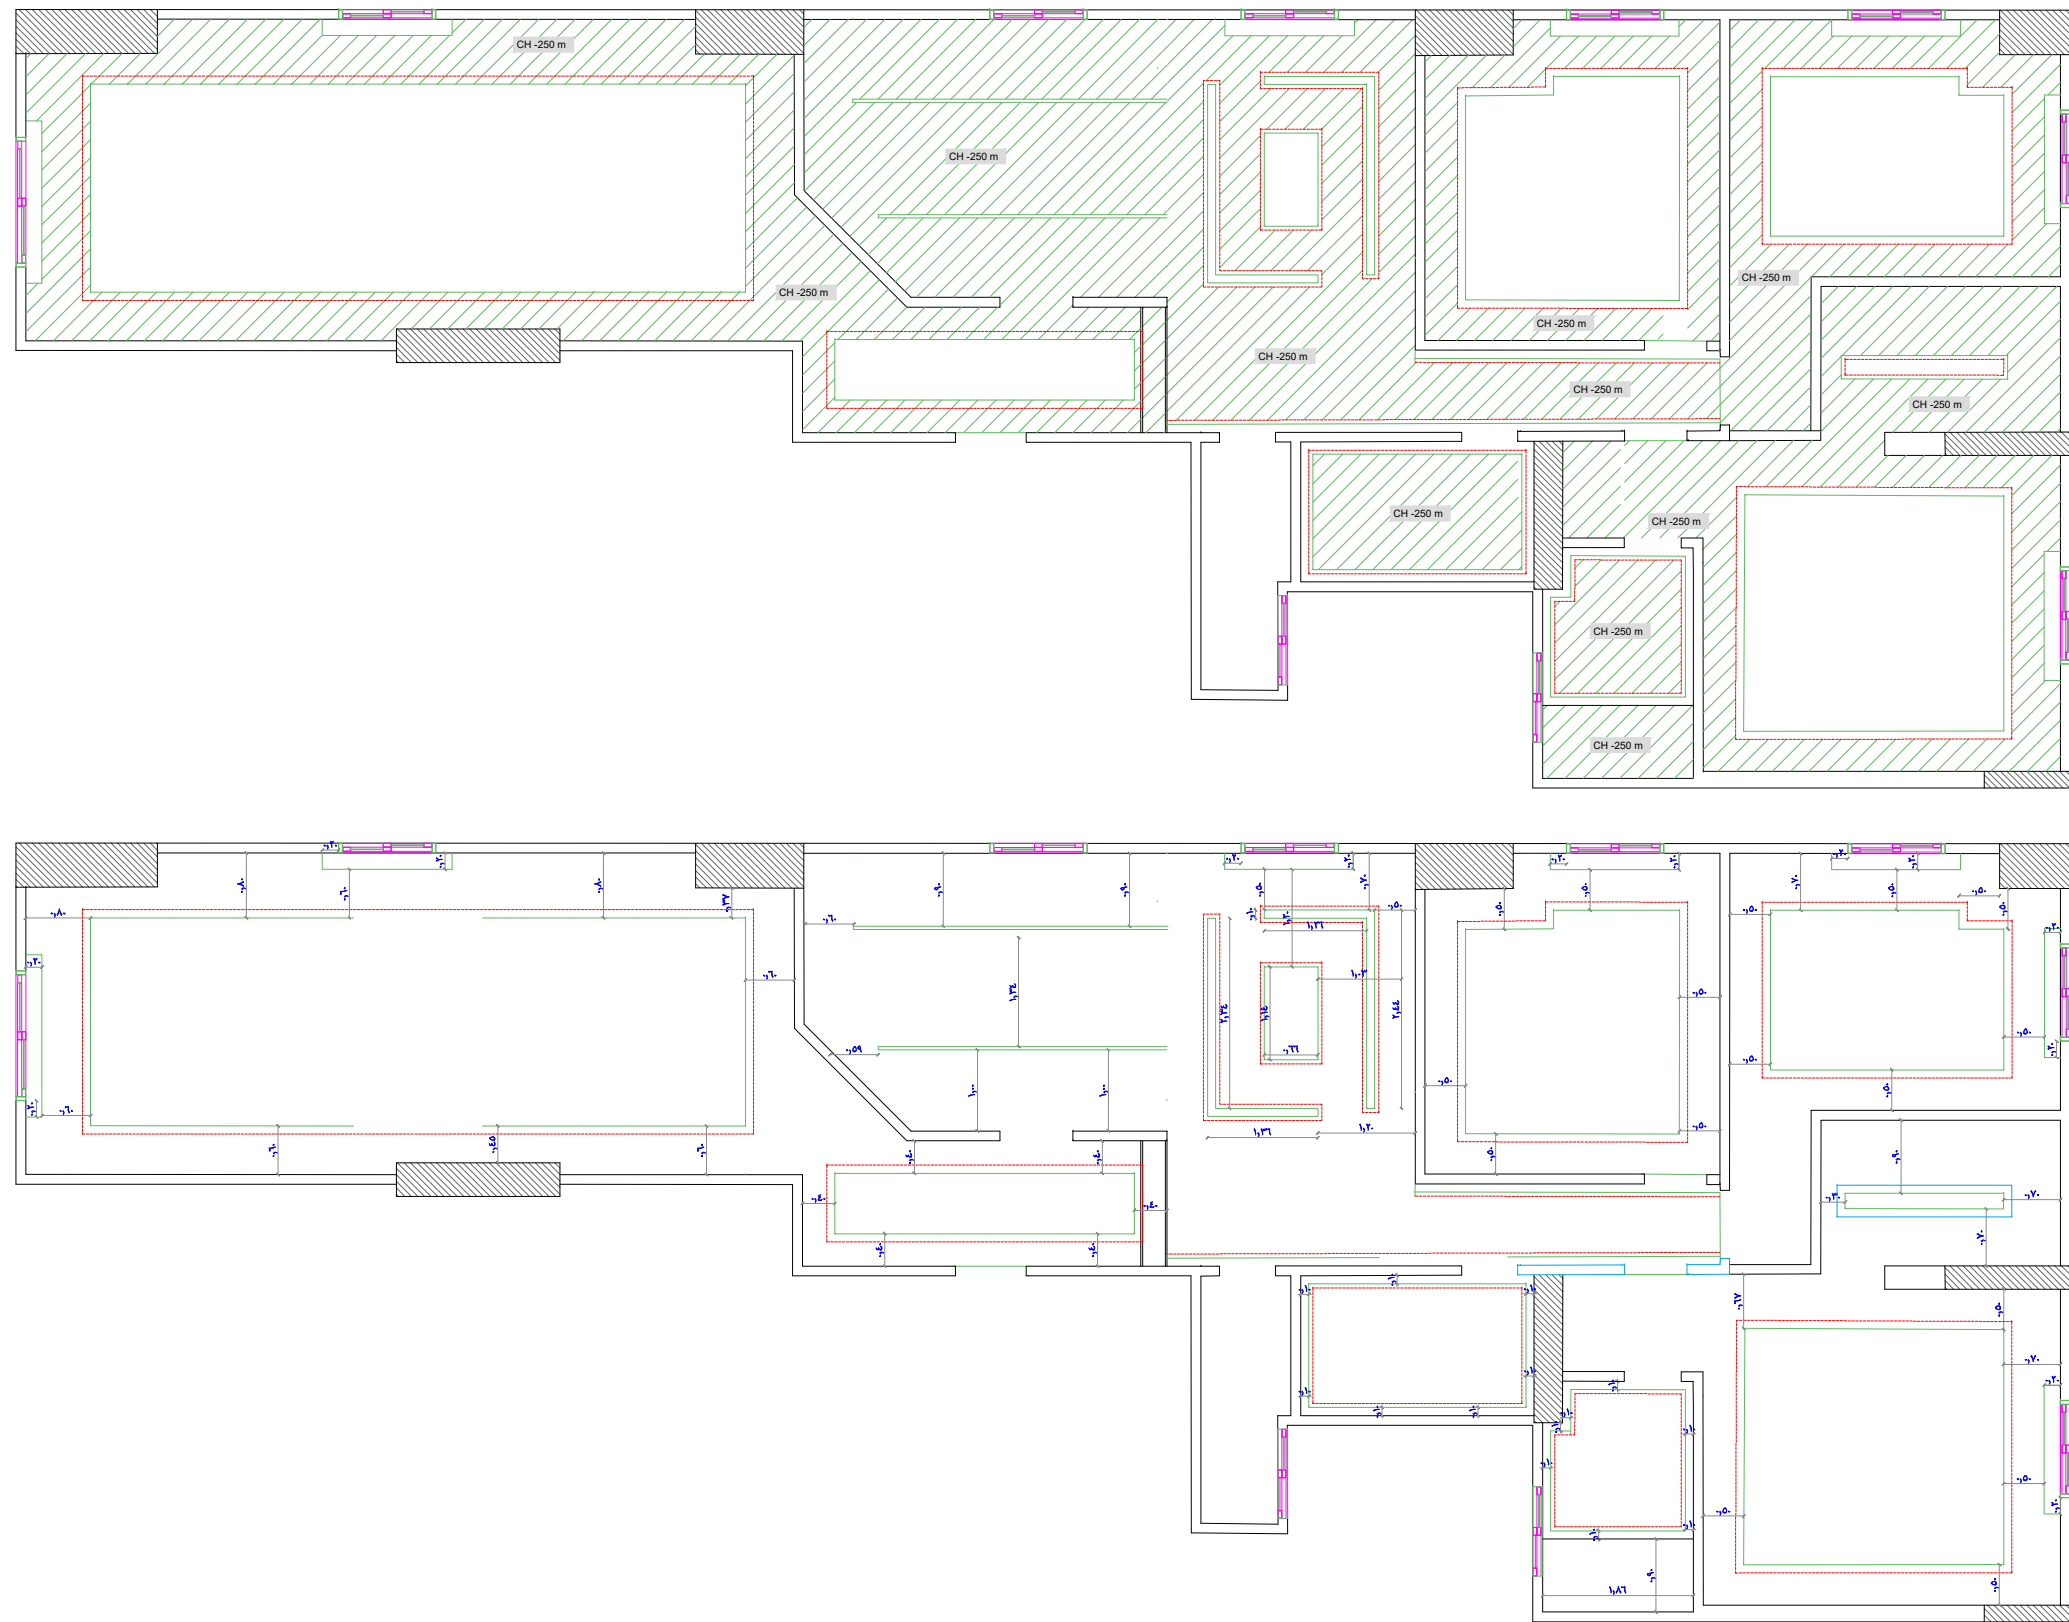

ADDRESS: 3 Hossam El-deen Bassiouny ST. Block No.29 - 9th district Nasr city	CLIENT NAME:	PROJECT NAME:	DRAWINGS TITLE:	DRAWN BY:	APPROVED BY:	DESCRIPTION: Ceiling Layout
	Ahmed Gamal	Elsafwa Tower		Ahmed Hesham	Hesham Zayed	
	TELEPHONE #: (+20)1020325050		Sheet Size: A3	TELEPHONE #: (+20)1116030118	TELEPHONE #: (+20)102032244	
			Rev : 0	SCALE:	DATE: 9-11-2021	

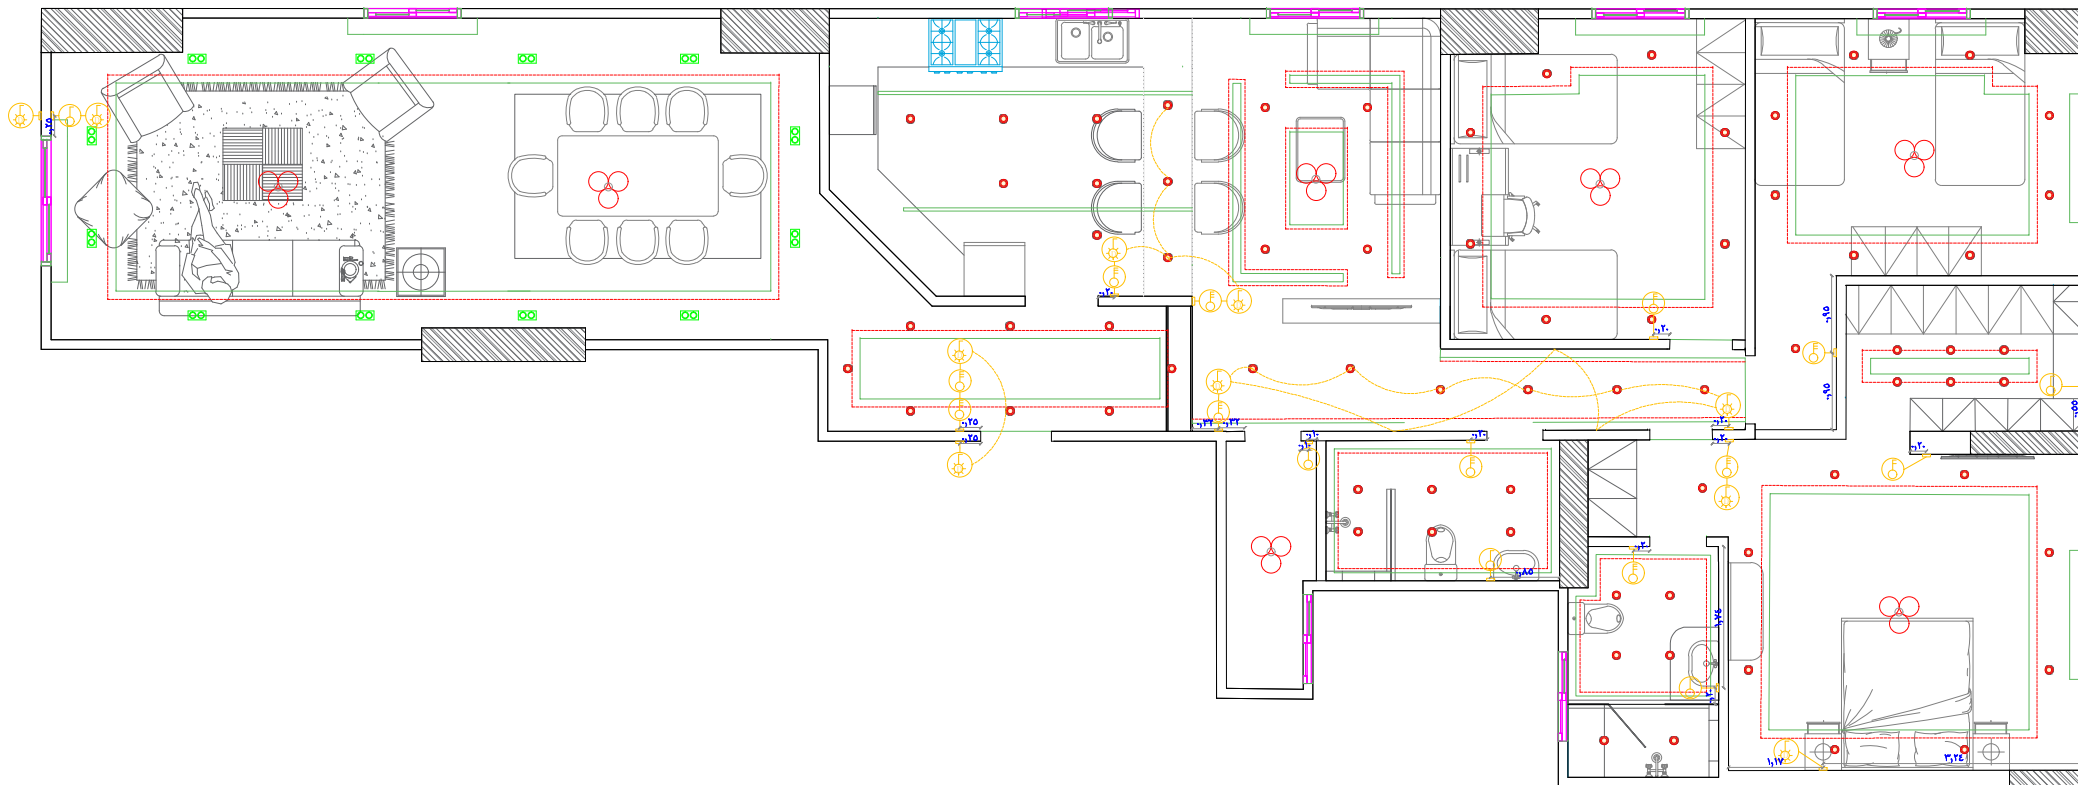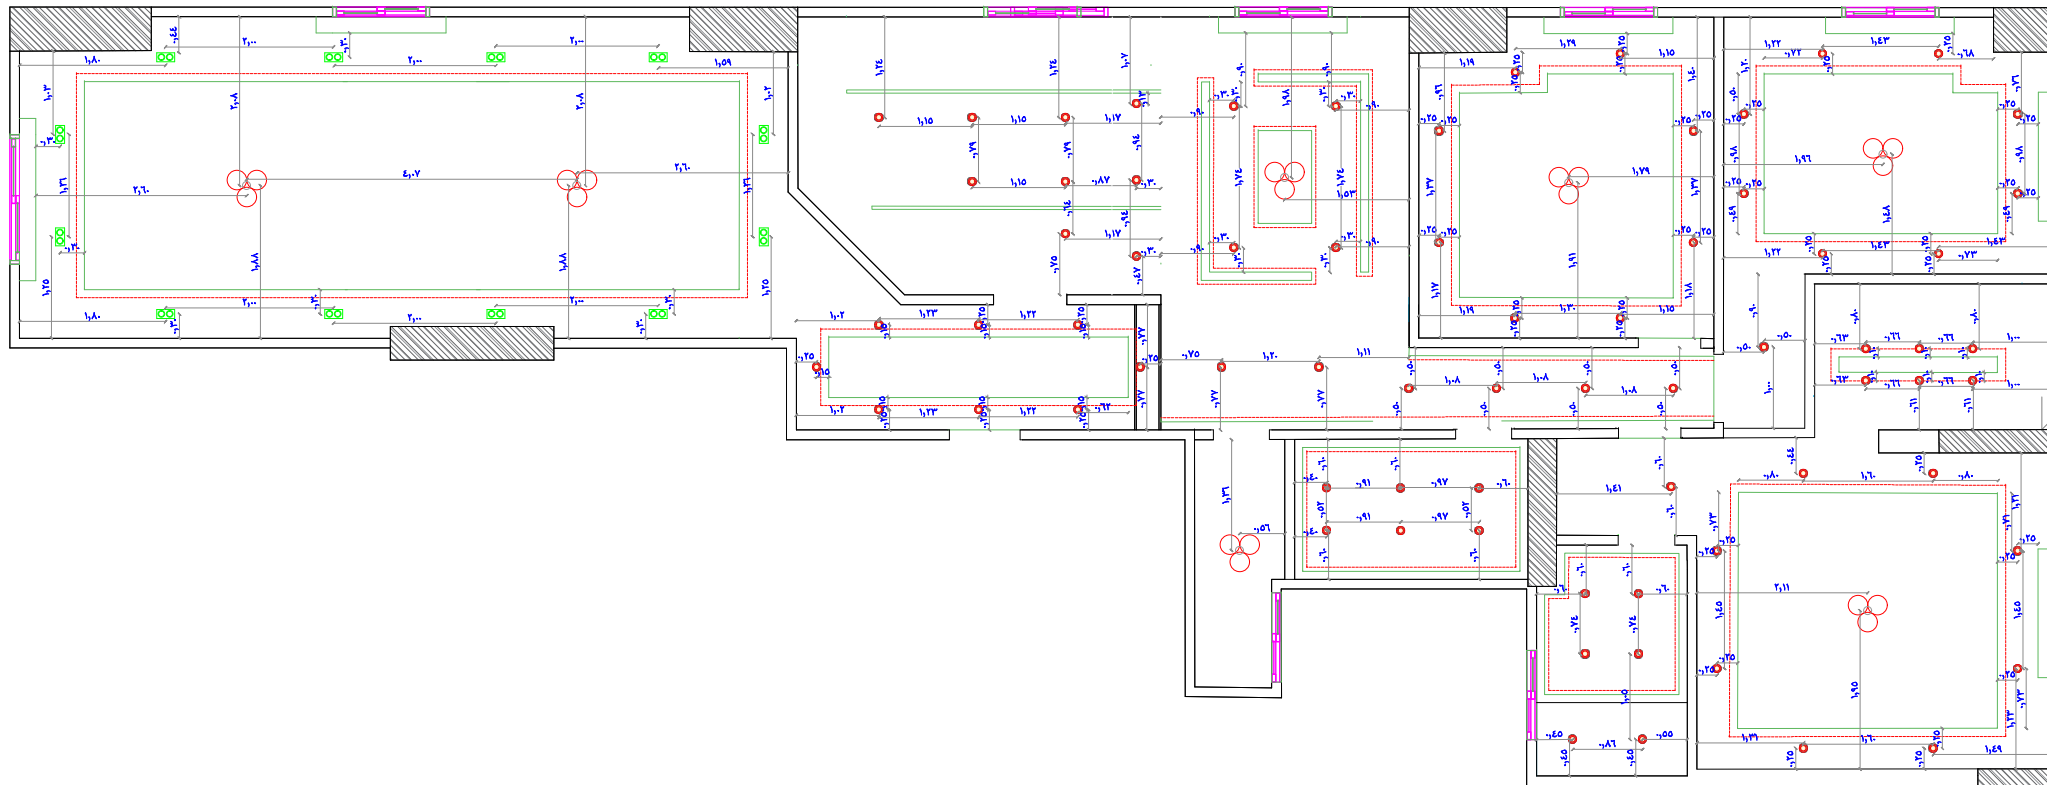

Lighting Switches

Symbol	Designation
	Electrical single switch (110 cm)h
	Electrical double switch (110 cm)h
	Electrical Three way Switch (110 cm)h
	Fan switch
	DEVIATOR switch (110 cm)H

Lighting Codes

Symbol	Designation
	Spot Light – Ceiling Level
	Chandelier – Ceiling Level
	Lighting Outlet – Ceiling Level
	Up light spot – Floor level
	Uplight spot water proof – Floor level
	False ceiling outlet – Ceiling level
	Led Light outlet – Cabinets level
	Sconce – (190 cm)H – wall
	Electrical outlet – wall
	Picture outlet – wall
	Stairs Electrical outlet – wall
	Stairs Electrical outlet water proof – Wall
	Garden electrical outlet – Floor level
	Stairs Electrical outlet water proof – Floor level

ADDRESS:
3 Hossam El-deen Bassiouny ST.
Block No.29 - 9th district Nasr city

CLIENT NAME:

Ahmed Gamal

TELEPHONE #:
(+20)1020325050

PROJECT NAME:

Elsafwa Tower

DRAWINGS TITLE:

Sheet Size: A3

Rev : 0

DRAWN BY:

Ahmed Hesham

TELEPHONE #:
(+20)1116030118

SCALE:

APPROVED BY:


Hesham Zayed

TELEPHONE #:
(+20)102032244

DATE: 16/11/2021

DESCRIPTION:

lighting & Switches &
Lighting Tracks Plan

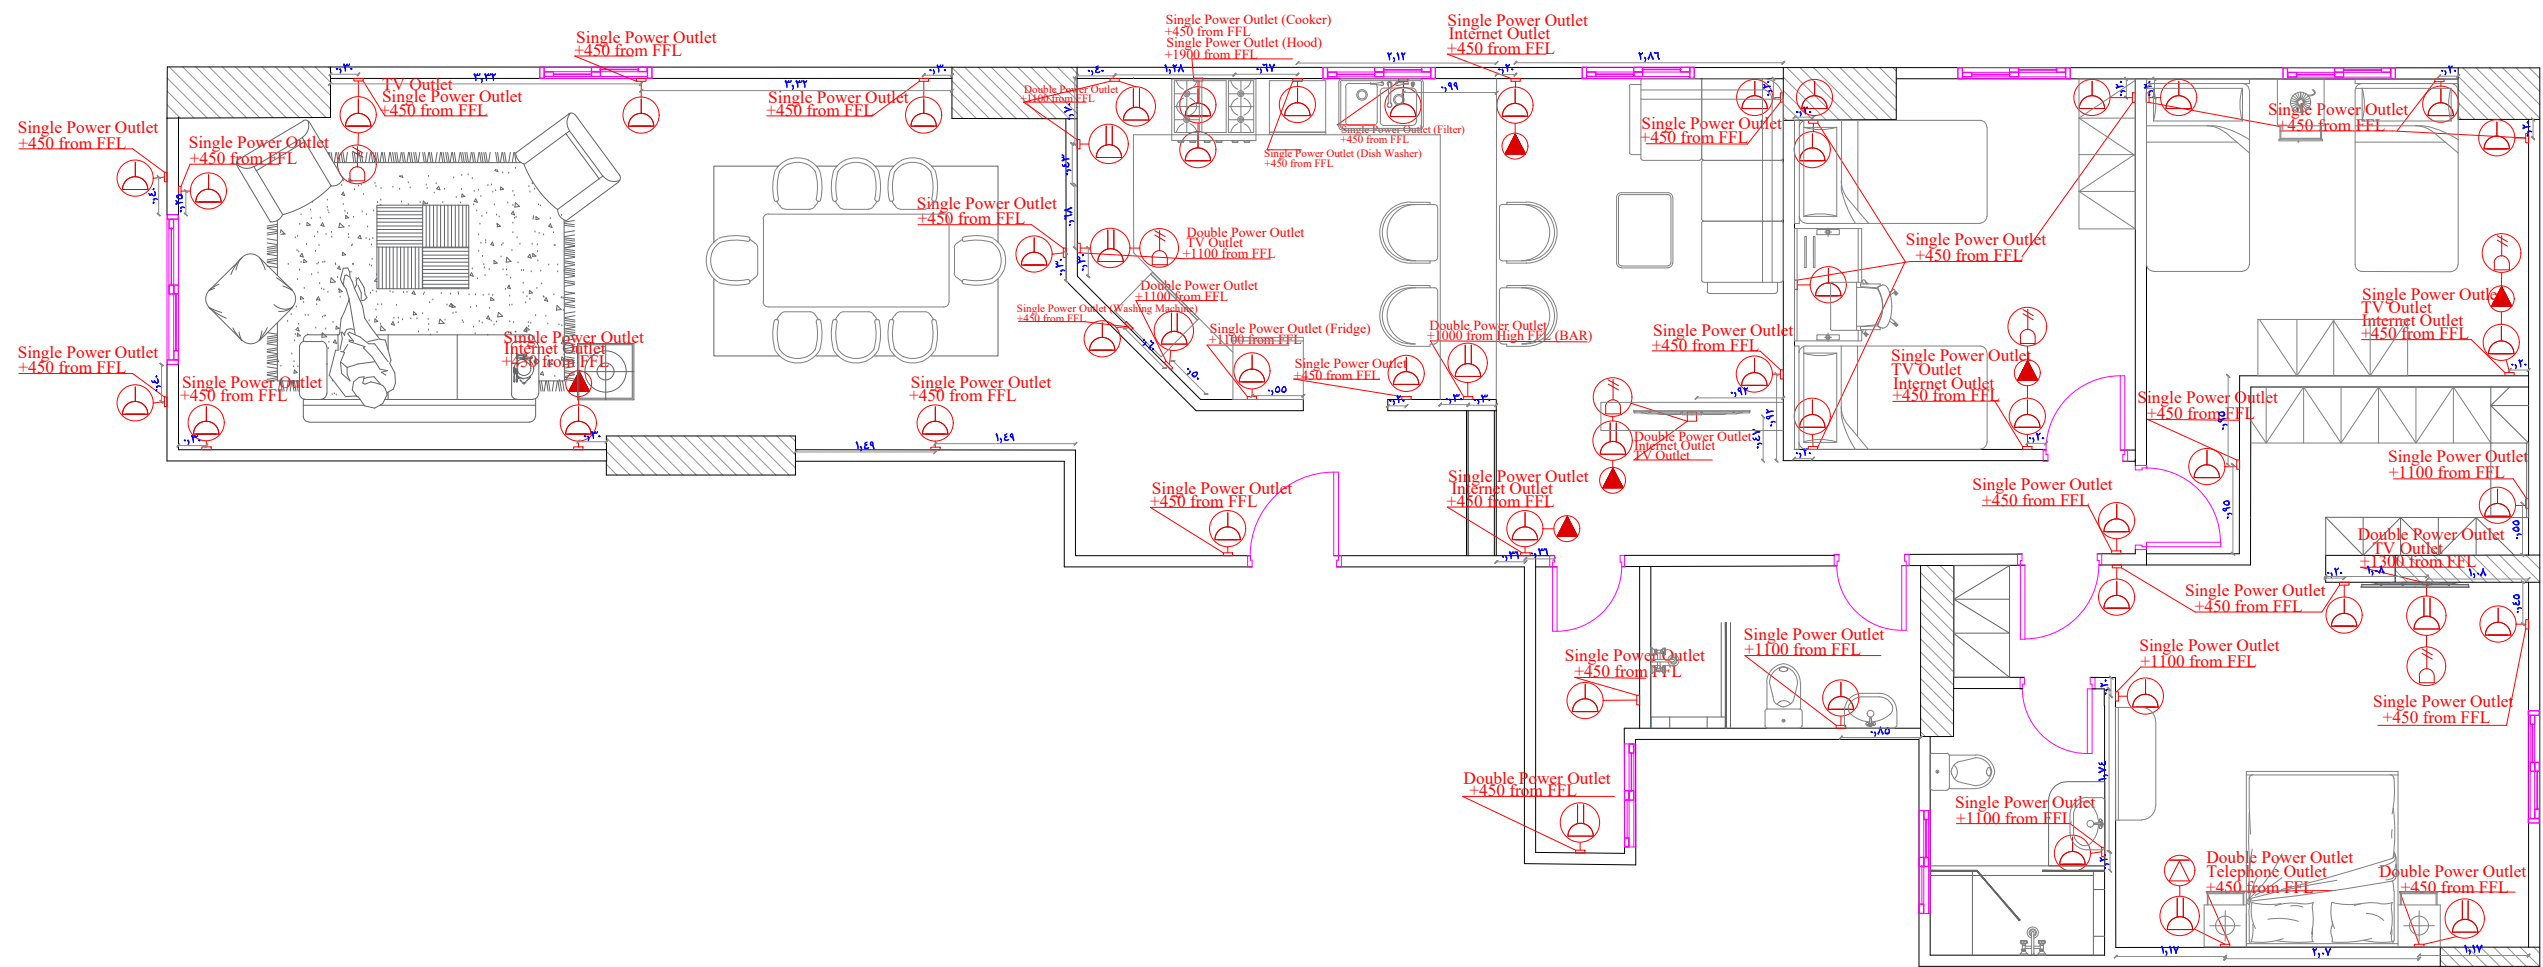

Electrical Codes

Symbol	Designation
	Telephone outlet - (30 cm)H
	Data outlet - INTERNET SOCKET (30 cm)H
	TV outlet - (30 cm)H
	Ceiling Speakers
	Wall Speakers
	Fan
	Bell outlet
	Intercome

Power codes

Symbol	Designation
	Single Socket (30 cm)h
	Power Single Socket (60 cm) h
	Double Socket (30 cm)h
	Power Double Socket (60 cm) h
	A/C switch - (115cm)H
	Bathtub/Jacuzzi motor Switch H=30cm
	Heater switch

ADDRESS:
3 Hossam El-deen Bassiouny ST.
Block No.29 - 9th district Nasr city

CLIENT NAME:

Ahmed Gamal

TELEPHONE #:
(+20)1020325050

PROJECT NAME:

Elsafwa Tower

DRAWINGS TITLE:

DRAWN BY:

Ahmed Hesham
TELEPHONE #:
(+20)1116030118

Sheet Size: A3

Rev : 0


APPROVED BY:

Hesham Zayed
TELEPHONE #:
(+20)1020232244

DATE: 16/11/2021

DESCRIPTION:

Power plan

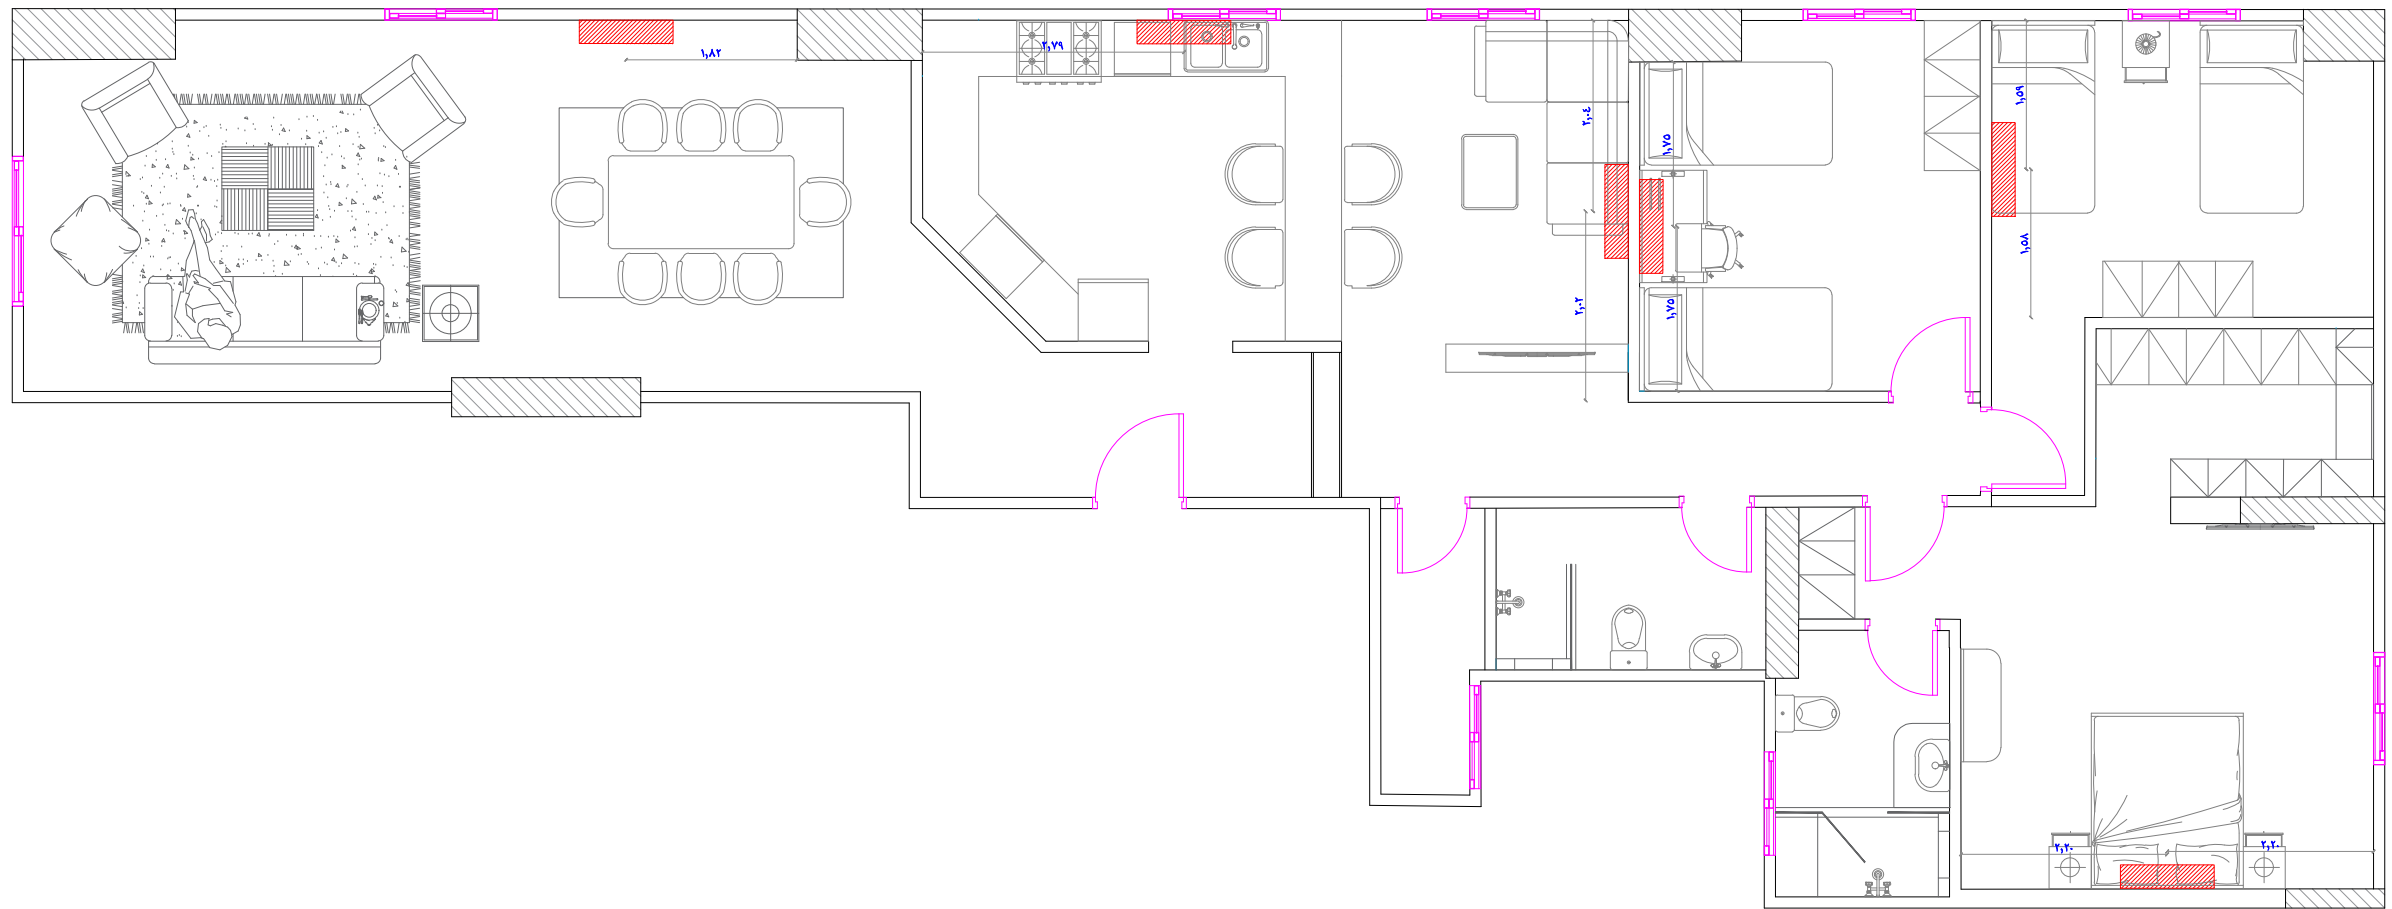

ADDRESS: 3 Hossam El-deen Bassiouny ST. Block No.29 - 9th district Nasr city	CLIENT NAME:	PROJECT NAME:	DRAWINGS TITLE:	DRAWN BY:	APPROVED BY:	DESCRIPTION:
	Ahmed Gamal	Elsafwa Tower		Ahmed Hesham	Hesham Zayed	AC Plan
	TELEPHONE #: (+20)1020325050		Sheet Size: A3	TELEPHONE #: (+20)1116030118	TELEPHONE #: (+20)1020232244	
			Rev : 0	SCALE:	DATE: 16/11/2021	