

Great
Home

The Best Design For your Great Home

ADDRESS:

CLIENT NAME:

PROJECT NAME:

DRAWINGS TITLE:

DRAWN BY:

APPROVED BY:

DESCRIPTION:

Abdallah Taher

TELEPHONE #:
(+20)1010081423

Sheet Size: A3

Rev : 0

Ahmed Hesham

TELEPHONE #:
(+20)1116030118

SCALE:

Hesham Zayed

TELEPHONE #:
(+20)102032244


DATE: 15-8-2024

As Built Plan



Great Home

The Best Design For your Great Home

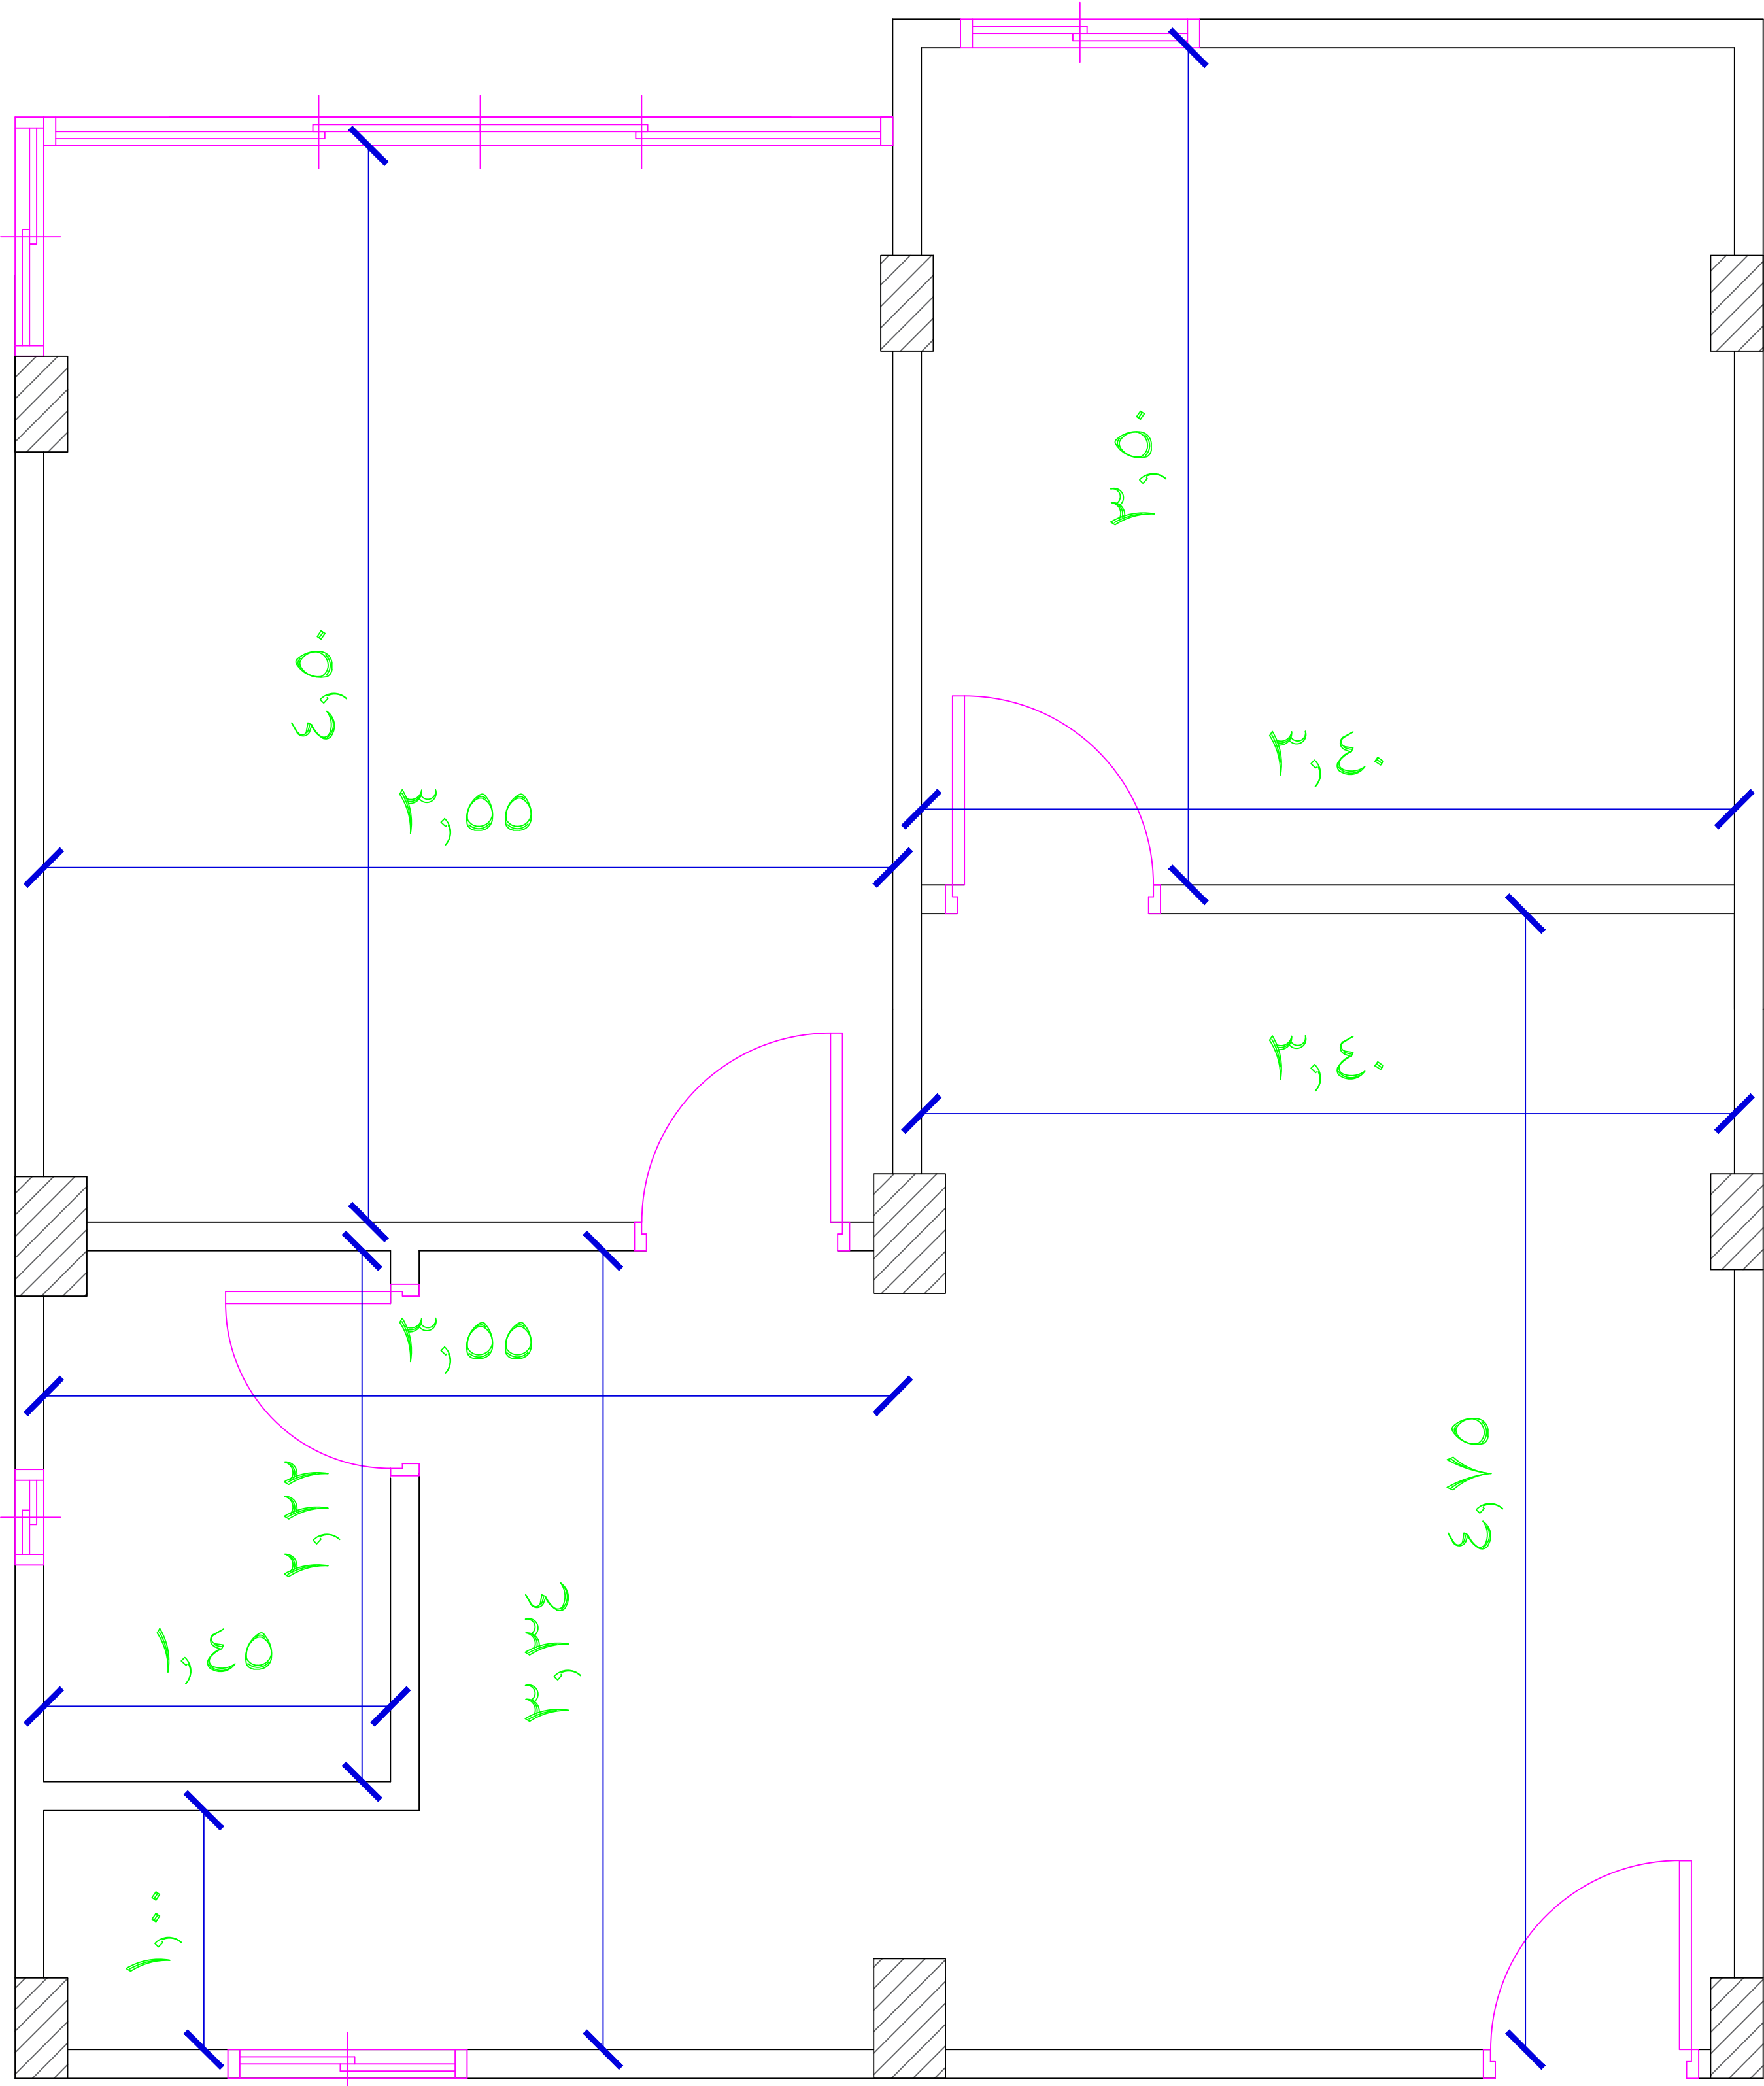

ADDRESS:

CLIENT NAME:

PROJECT NAME:

DRAWINGS TITLE:

DRAWN BY:

APPROVED BY:

DESCRIPTION:

Abdallah Taher

TELEPHONE #:
(+20)1010081423

Sheet Size: A3

Rev : 0

Ahmed Hesham
TELEPHONE #:
(+20)1116030118

SCALE:

Hesham Zayed
TELEPHONE #:
(+20)102032244


DATE: 18-8-2024

Dimension plan



Great
Home

The Best Design For your Great Home

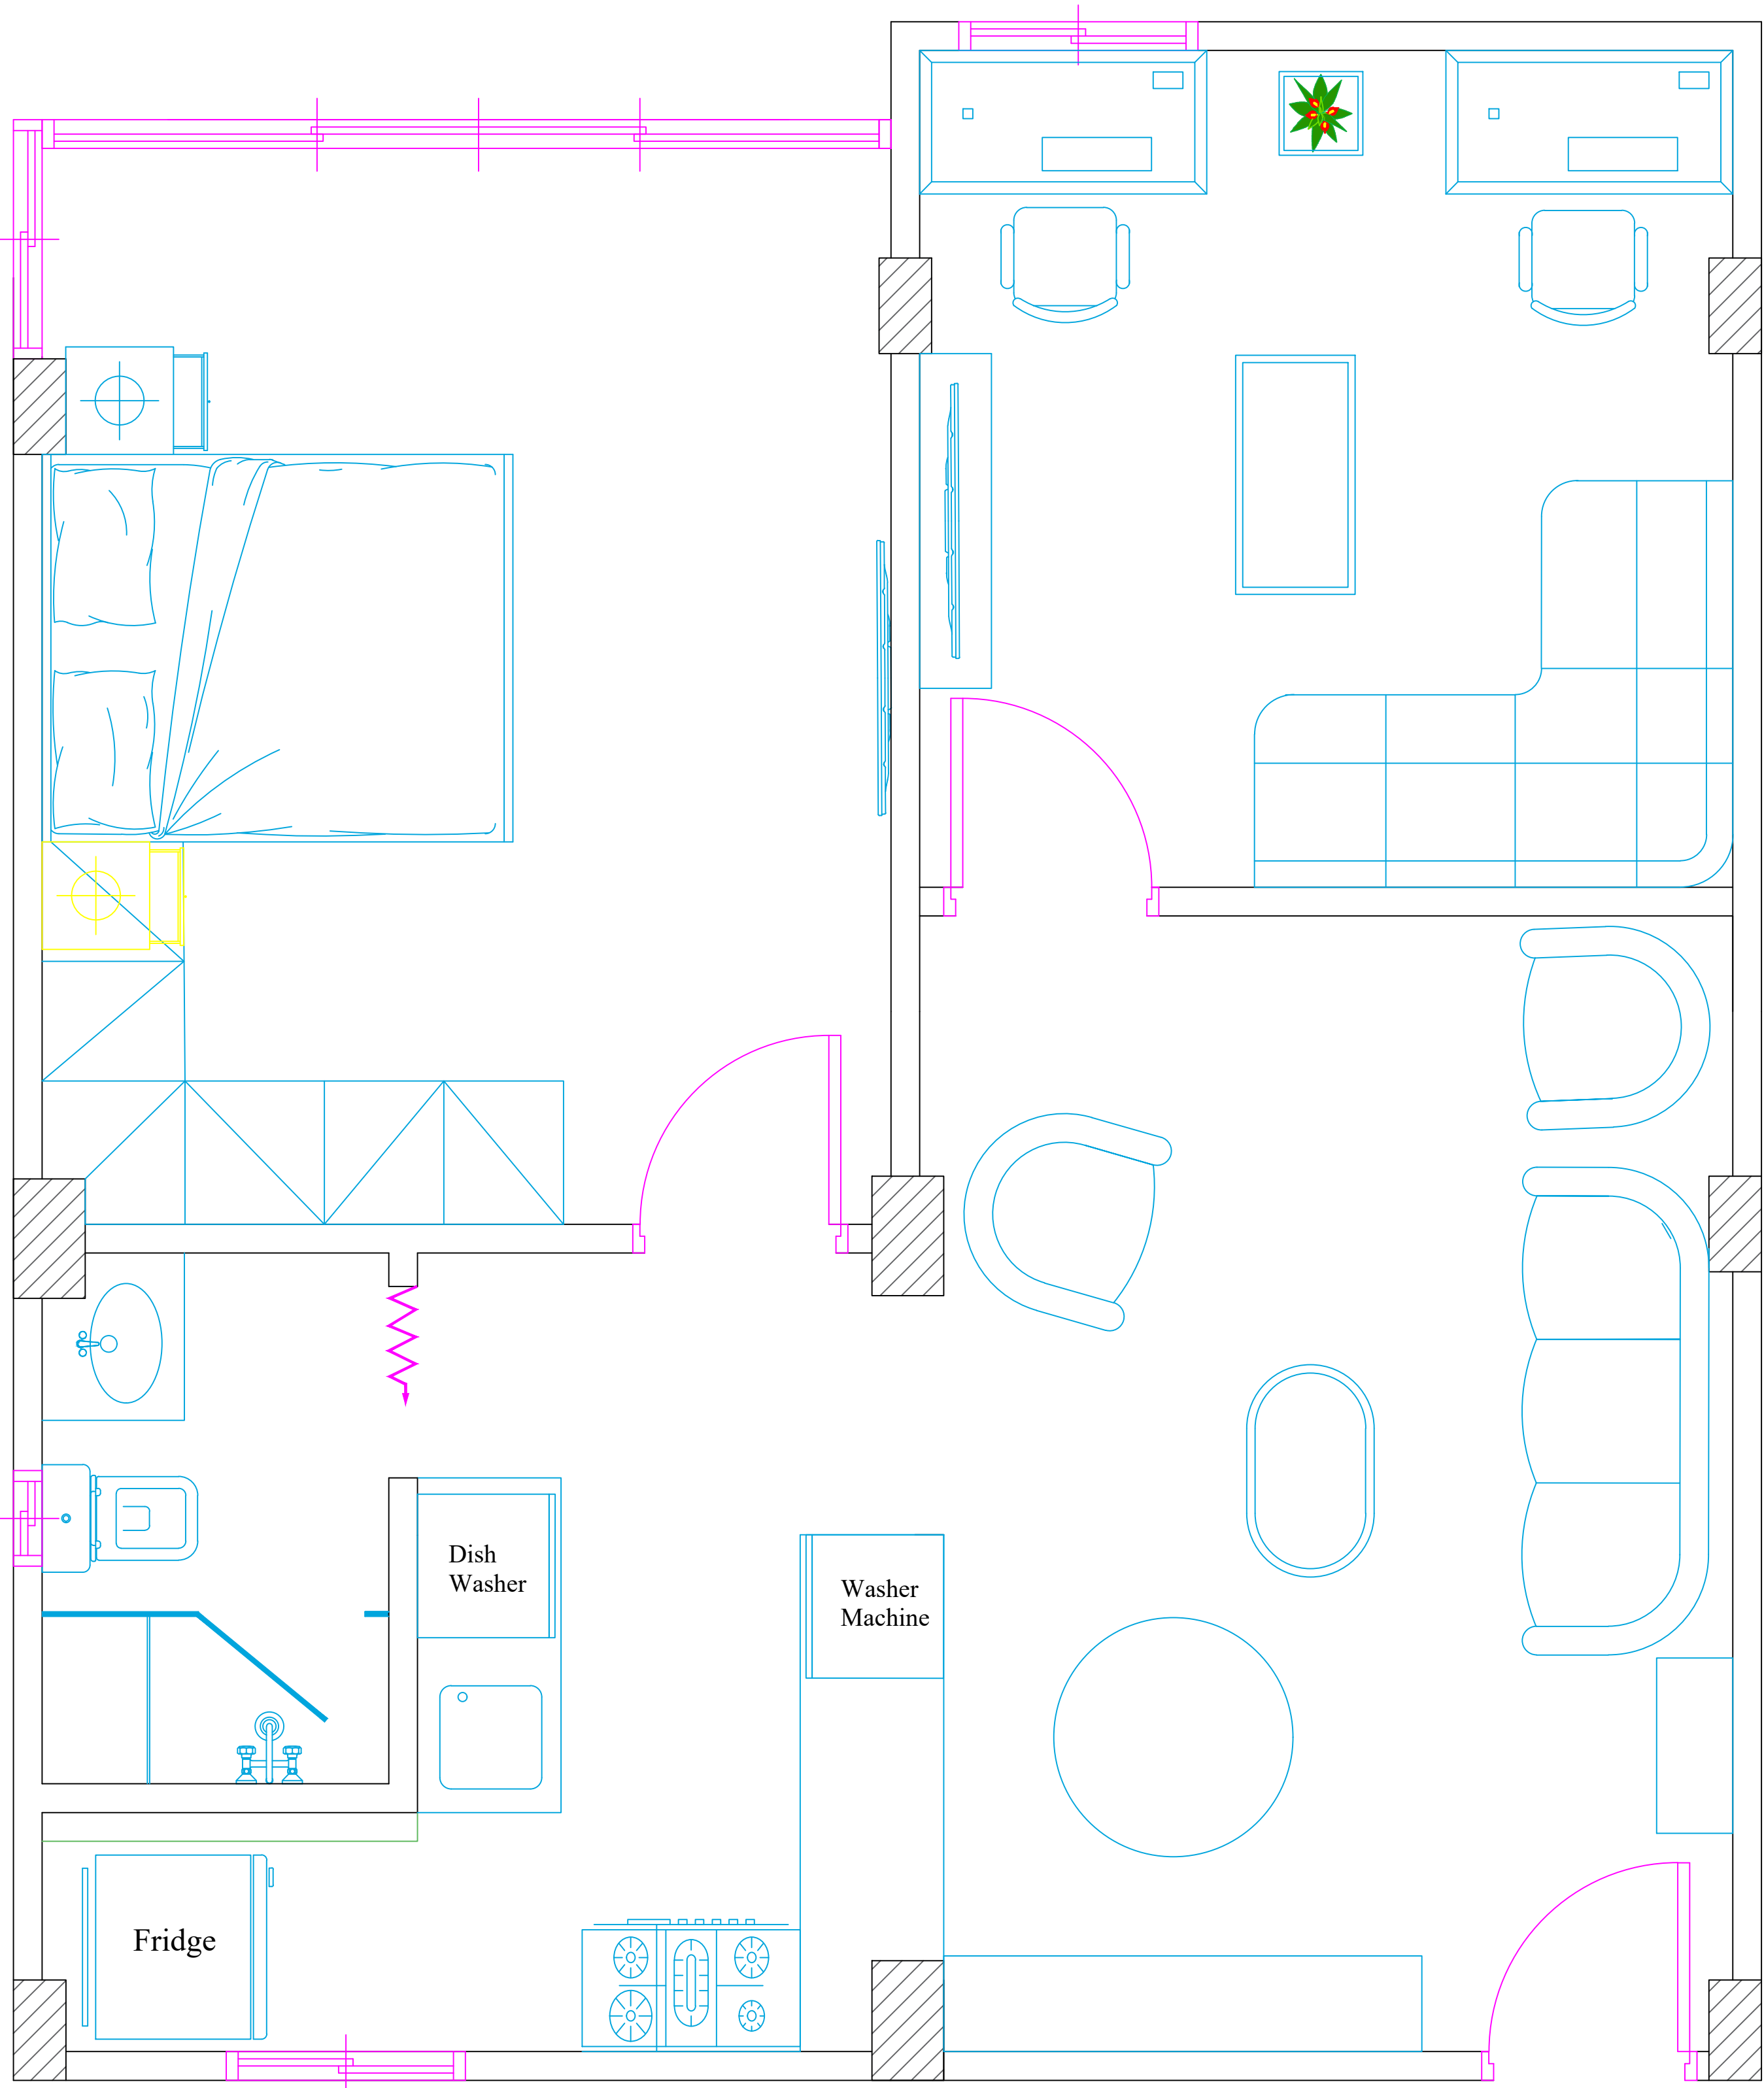

ADDRESS:

CLIENT NAME:

PROJECT NAME:

DRAWINGS TITLE:

DRAWN BY:

APPROVED BY:

DESCRIPTION:

Abdallah Taher

TELEPHONE #:
(+20)1010081423

Sheet Size: A3

Rev : 0

Ahmed Hesham

TELEPHONE #:
(+20)1116030118

SCALE:

Hesham Zayed

TELEPHONE #:
(+20)102032244


DATE: 20-8-2024

Furniture plan



Great Home

The Best Design For your Great Home

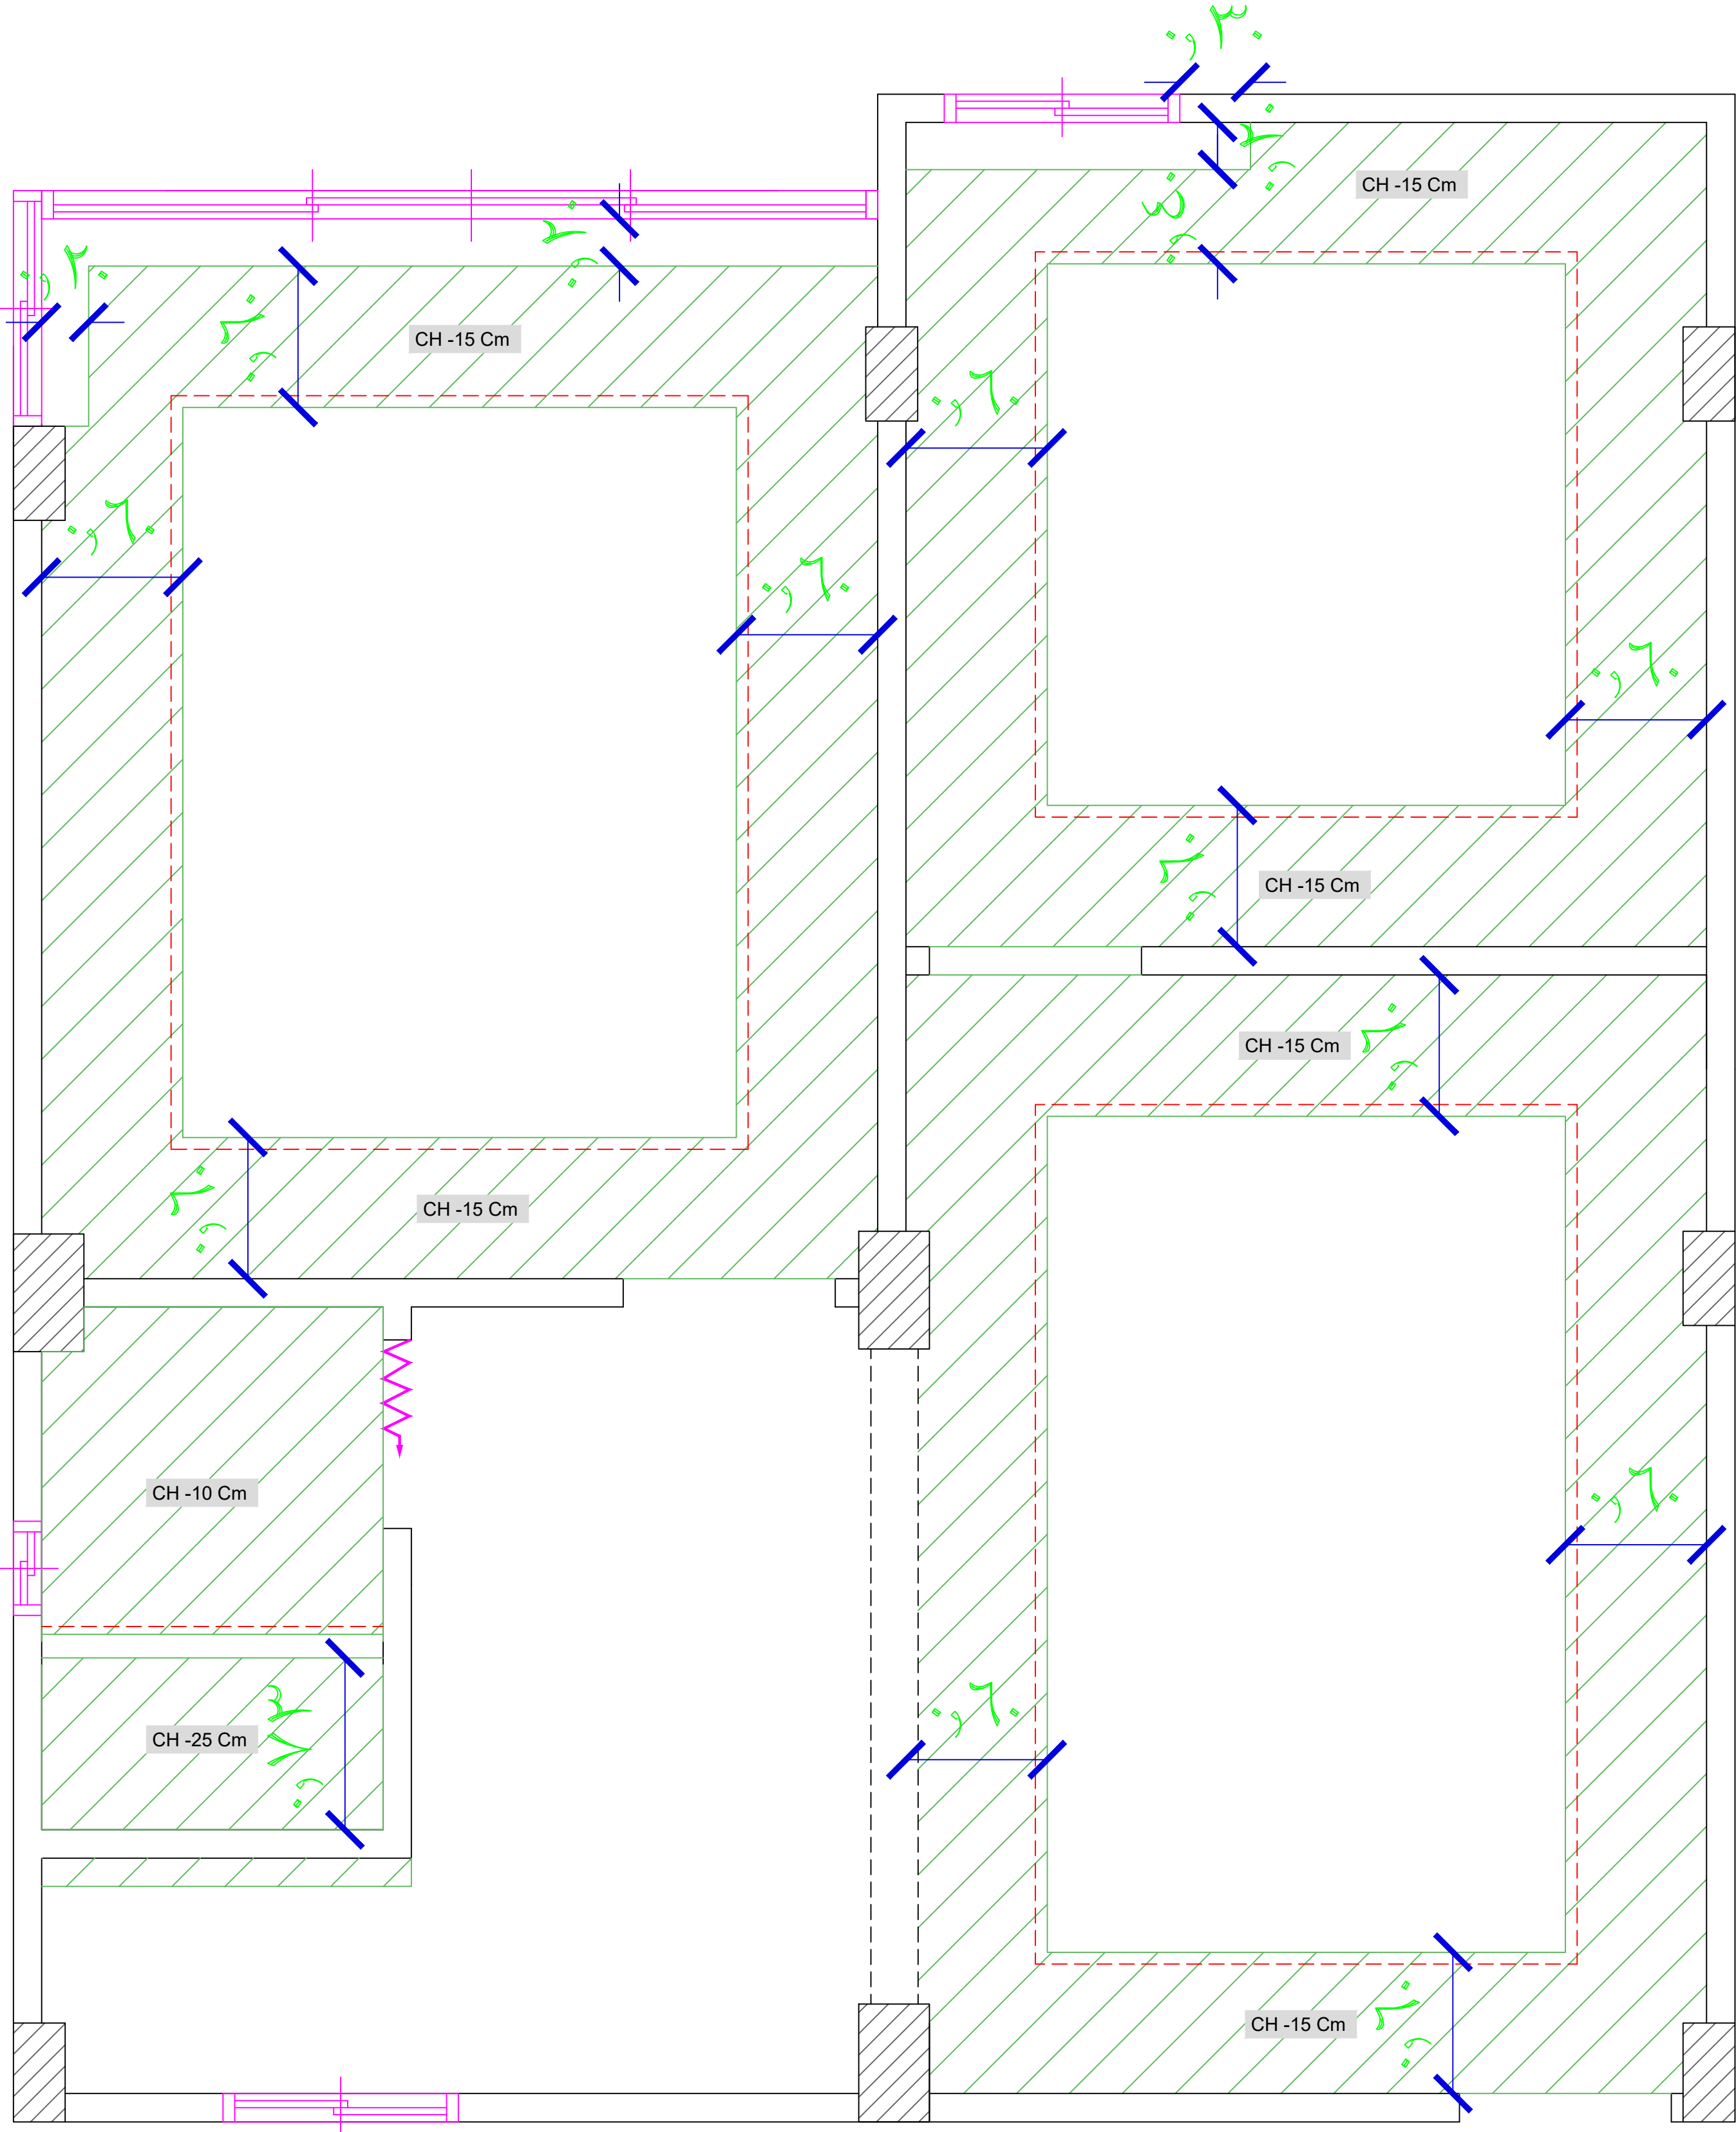

ADDRESS:

CLIENT NAME:

PROJECT NAME:

DRAWINGS TITLE:

DRAWN BY:

APPROVED BY:

DESCRIPTION:

Abdallah Taher

TELEPHONE #:
(+20)1010081423

Sheet Size: A3

Rev : 0

Ahmed Hesham

TELEPHONE #:
(+20)1116030118

SCALE:

Hesham Zayed

TELEPHONE #:
(+20)1020232244


DATE: 25-8-2024

Ceiling Plan



Great Home

The Best Design For your Great Home

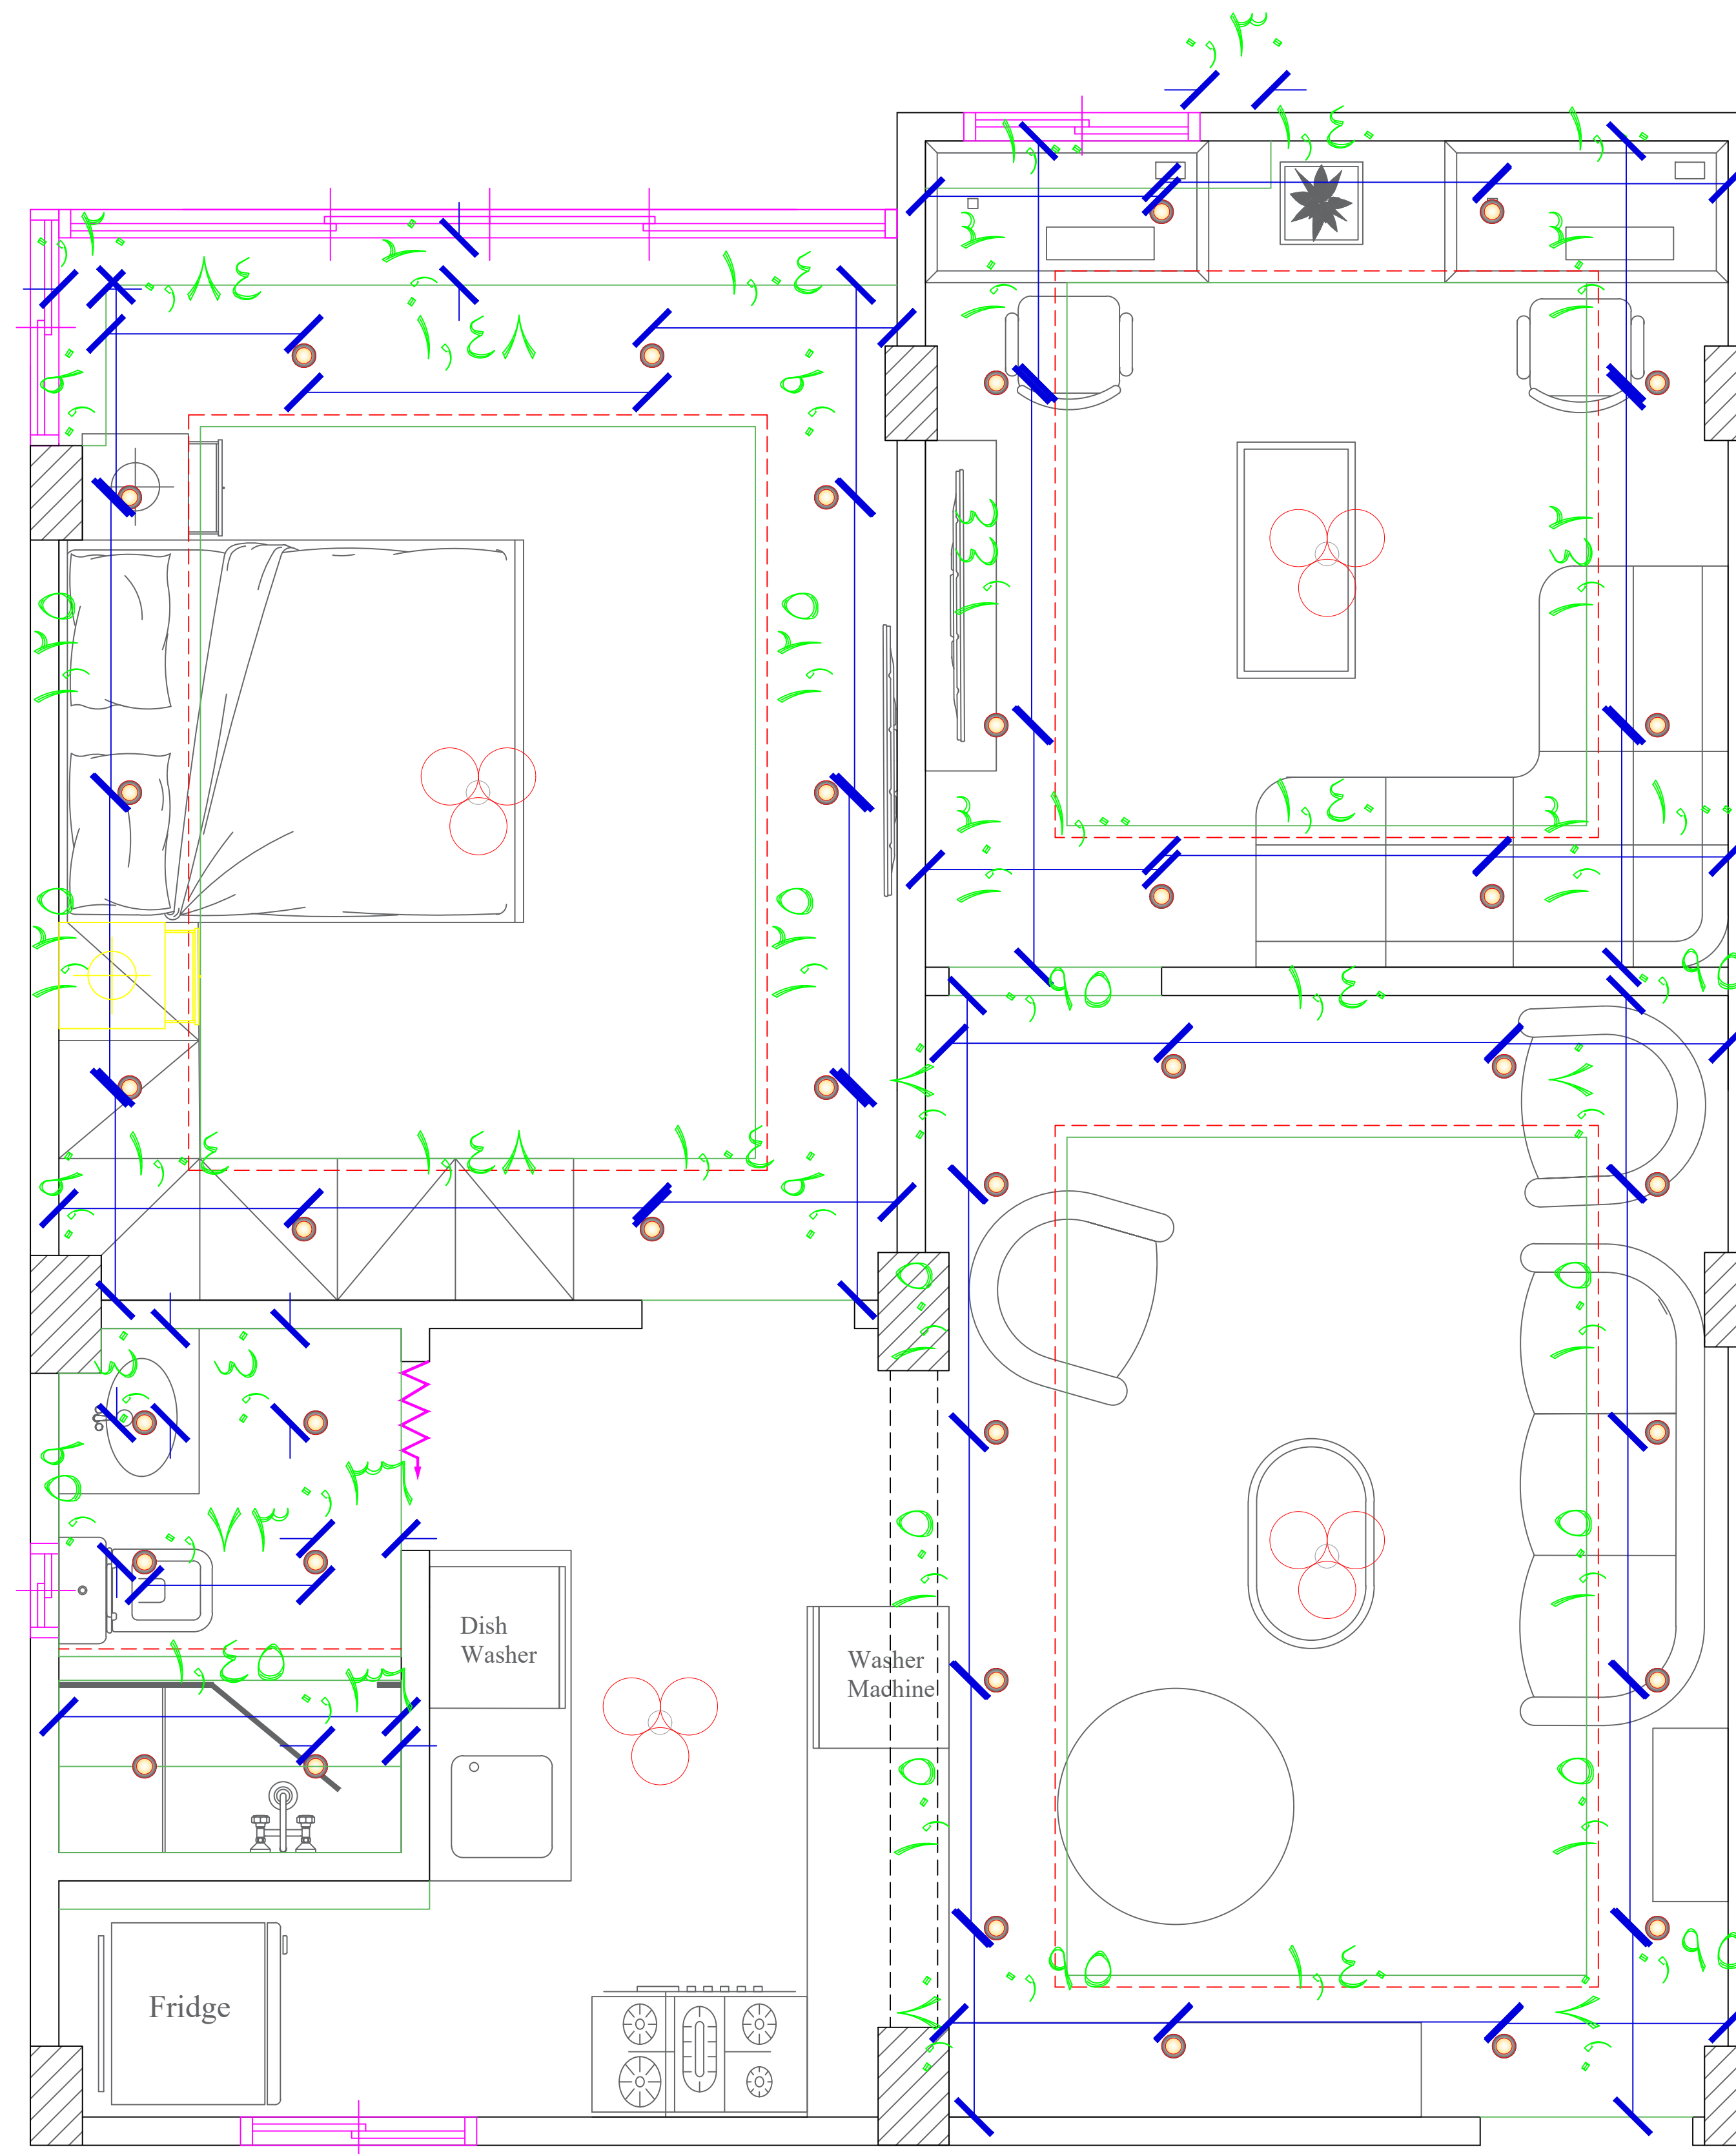


ADDRESS:		CLIENT NAME:	PROJECT NAME:	DRAWINGS TITLE:	DRAWN BY:	APPROVED BY:	DESCRIPTION:
		Abdallah Taher			Ahmed Hesham	Hesham Zayed	Ceiling Lighting plan
		TELEPHONE #: (+20)1010081423		Sheet Size: A3	TELEPHONE #: (+20)1116030118	TELEPHONE #: (+20)102032244	
				Rev : 0	SCALE:	DATE: 27-8-2024	



Great Home

The Best Design For your Great Home

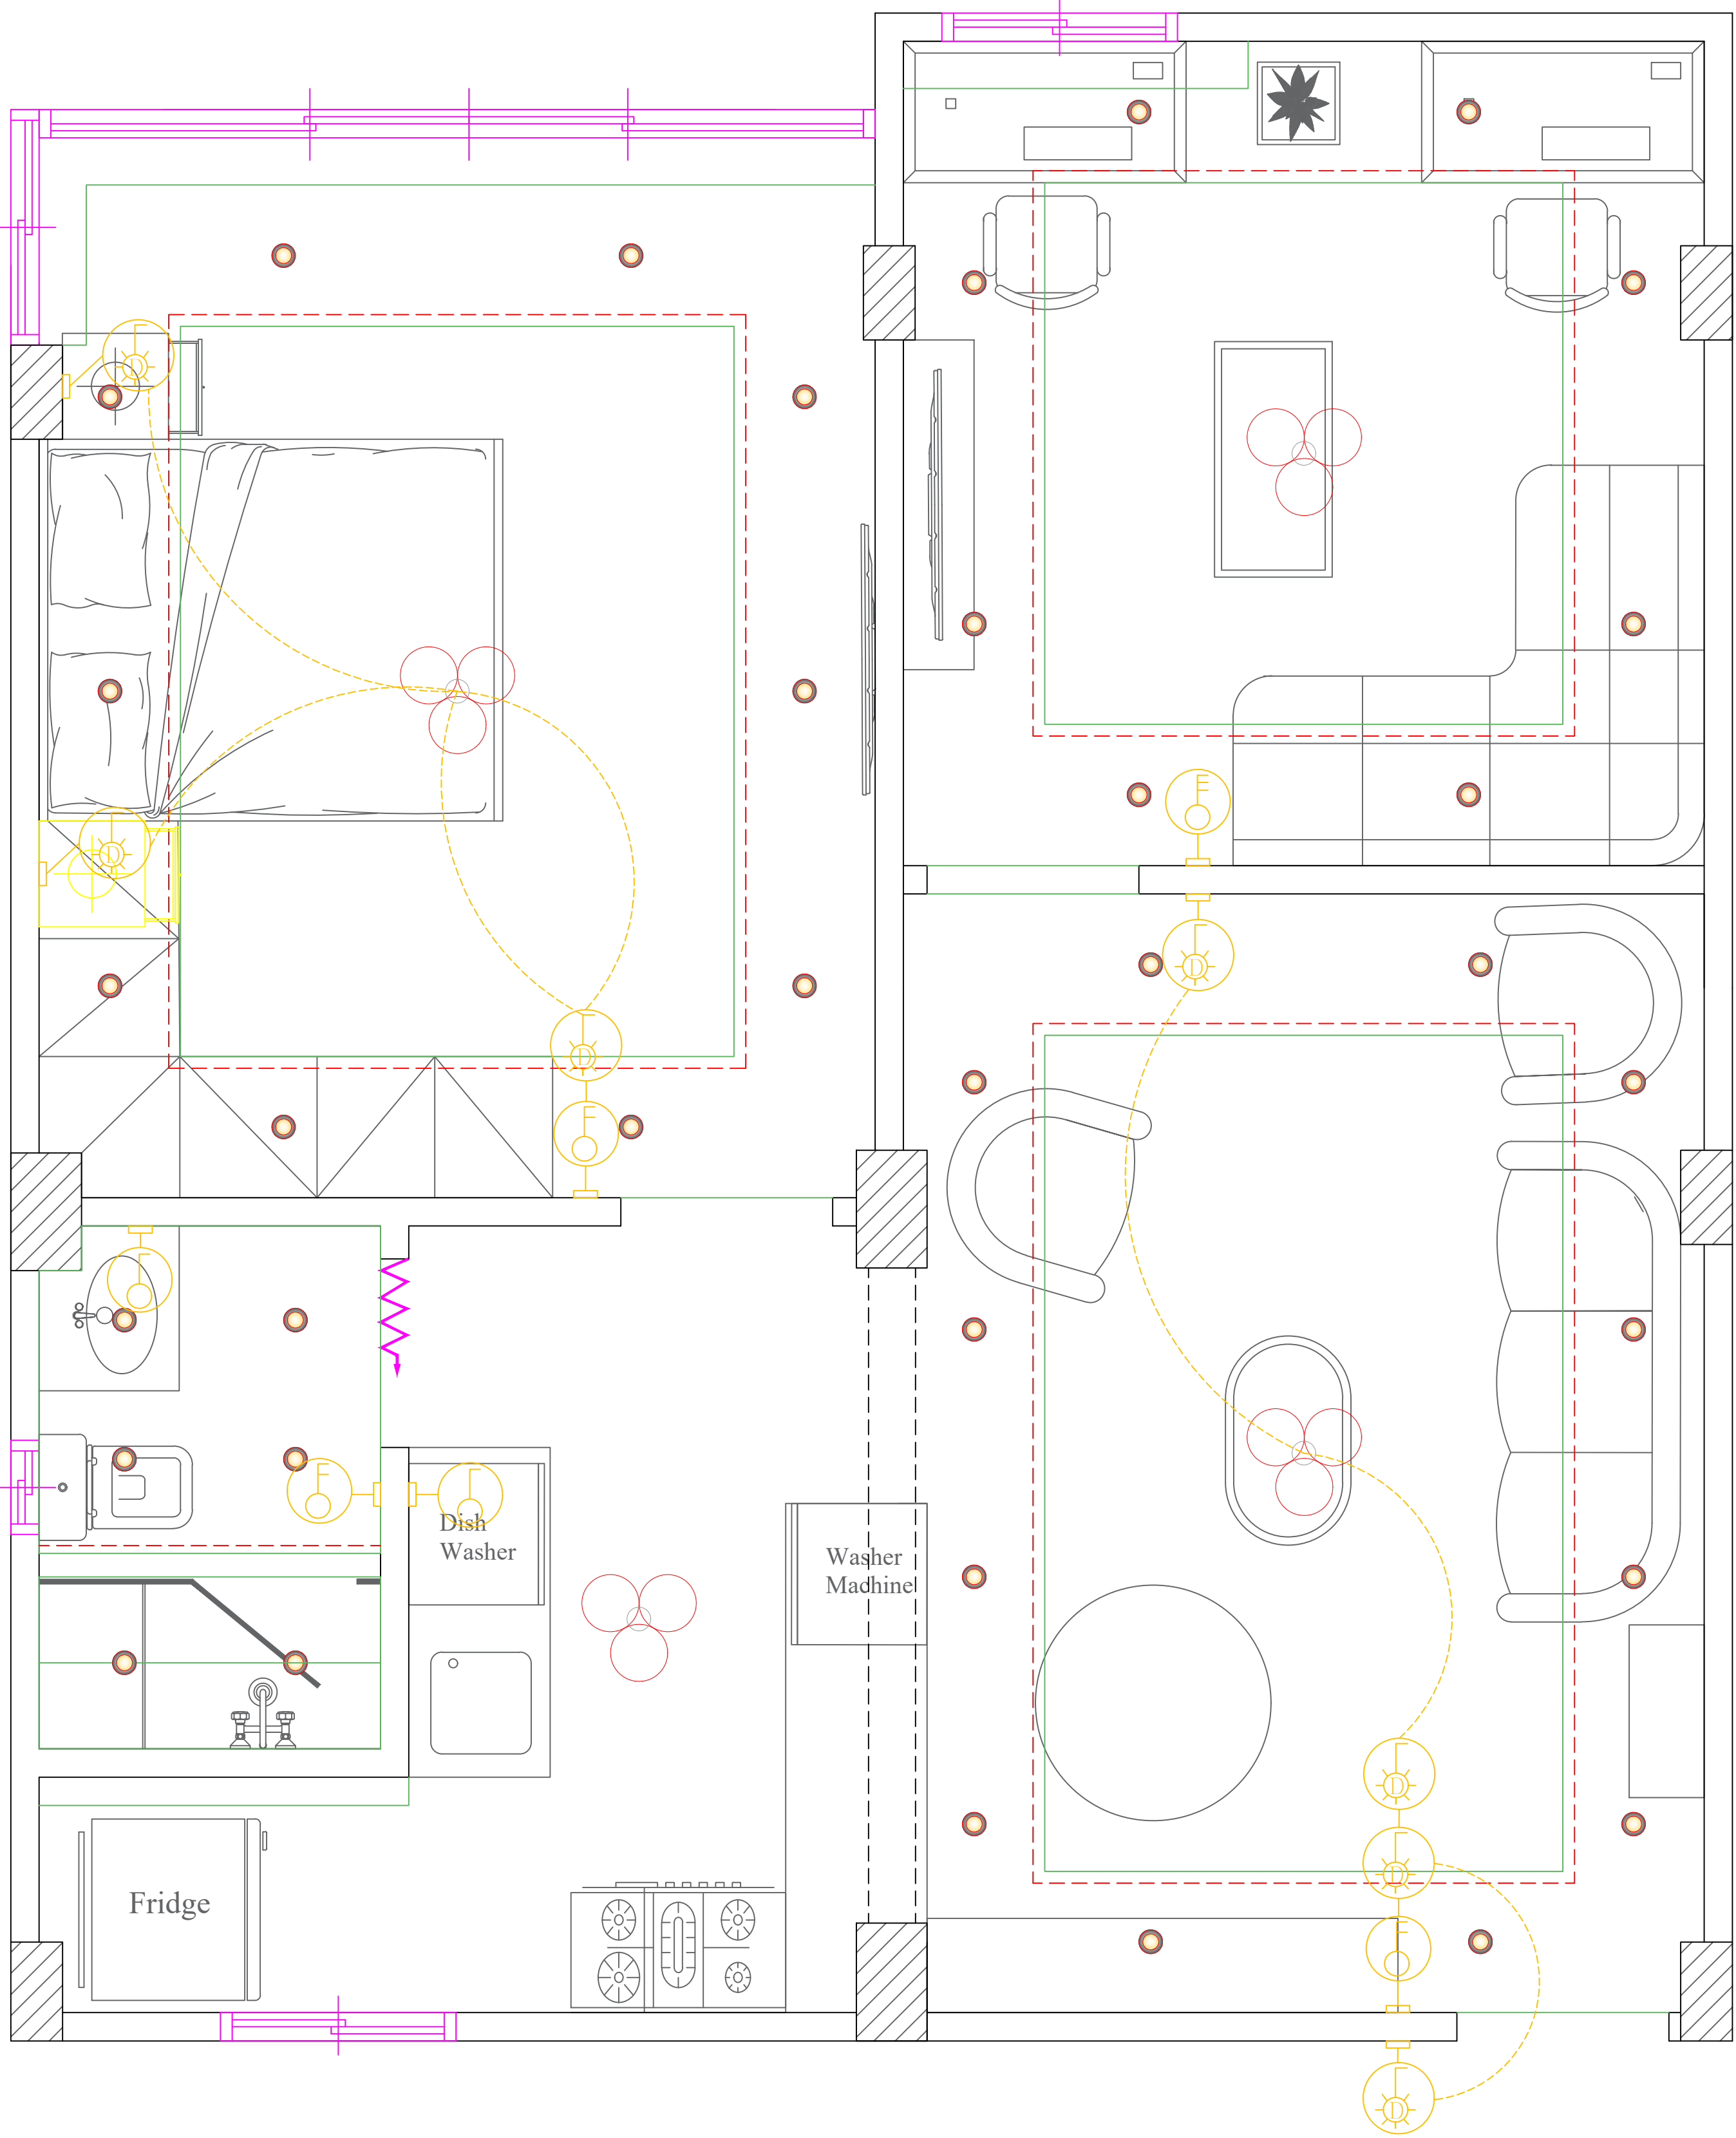

ADDRESS:

CLIENT NAME:

PROJECT NAME:

DRAWINGS TITLE:

DRAWN BY:

APPROVED BY:

DESCRIPTION:

Abdallah Taher

TELEPHONE #:
(+20)1010081423

Sheet Size: A3

Rev : 0

Ahmed Hesham

TELEPHONE #:
(+20)1116030118

SCALE:

Hesham Zayed

TELEPHONE #:
(+20)102032244

DATE: 29-8-2024

Light Switches and Lighting
tracks plan



This architectural floor plan illustrates a kitchen and living area with detailed plumbing and electrical specifications. The kitchen features a sink with a main drain, a dishwasher, and a refrigerator. The living area includes a sofa, a coffee table, and a television. The plan also shows a bathroom with a toilet and a shower. The plumbing system is color-coded: red for hot water supply, green for cold water supply, and blue for drains. The electrical system is shown with black lines and symbols for outlets and switches. The plan includes various dimensions and notes for construction and installation.

Plumbing Details:

- Sink:** Cold Water Supply, Hot Water Supply, Sink Drain, Main Drain.
- Dishwasher:** Dish Washer Drain, Water Supply.
- Shower:** Shower Drain, Cold Water Supply, Sink Drain, Hot Water Supply.
- Toilet:** Toilet Supply, Toilet Drain.
- Washer:** Washer Drain, Water Supply.

Electrical Details:

- Outlet symbols are shown in the living area and kitchen.
- Switch symbols are shown near the entrance and in the living area.

Dimensions and Notes:

- Dimensions are provided for various elements, such as the sink (1.11), dishwasher (1.11), and shower (1.11).
- Notes include "Fridge" and "TV" indicating the placement of these appliances.

ADDRESS:	CLIENT NAME:	PROJECT NAME:	DRAWINGS TITLE:	DRAWN BY:	APPROVED BY:	DESCRIPTION:
	Abdallah Taher TELEPHONE #: (+20)1010081423			Ahmed Hesham TELEPHONE #: (+20)1116030118	Hesham Zayed TELEPHONE #: (+20)1020232244	Plumbing plan
			Sheet Size: A3	SCALE:	DATE: 1-9-2024	
			Rev : 0			