

ADDRESS:
Interception of George Apyad with Abd-Elwareth Asr St
9th district Nasr city

CLIENT NAME:

Eng/ Ashraf Farag

TELEPHONE #:
(+20)1001689916

PROJECT NAME:

DRAWINGS TITLE:

Sheet Size: A3

Rev : 0

DRAWN BY:

Ahmed Hesham
TELEPHONE #:
(+20)1116030118

SCALE:


APPROVED BY:

Hesham Zayed
TELEPHONE #:
(+20)102032244

DATE: 22-08-2022

DESCRIPTION:

Furniture Plan

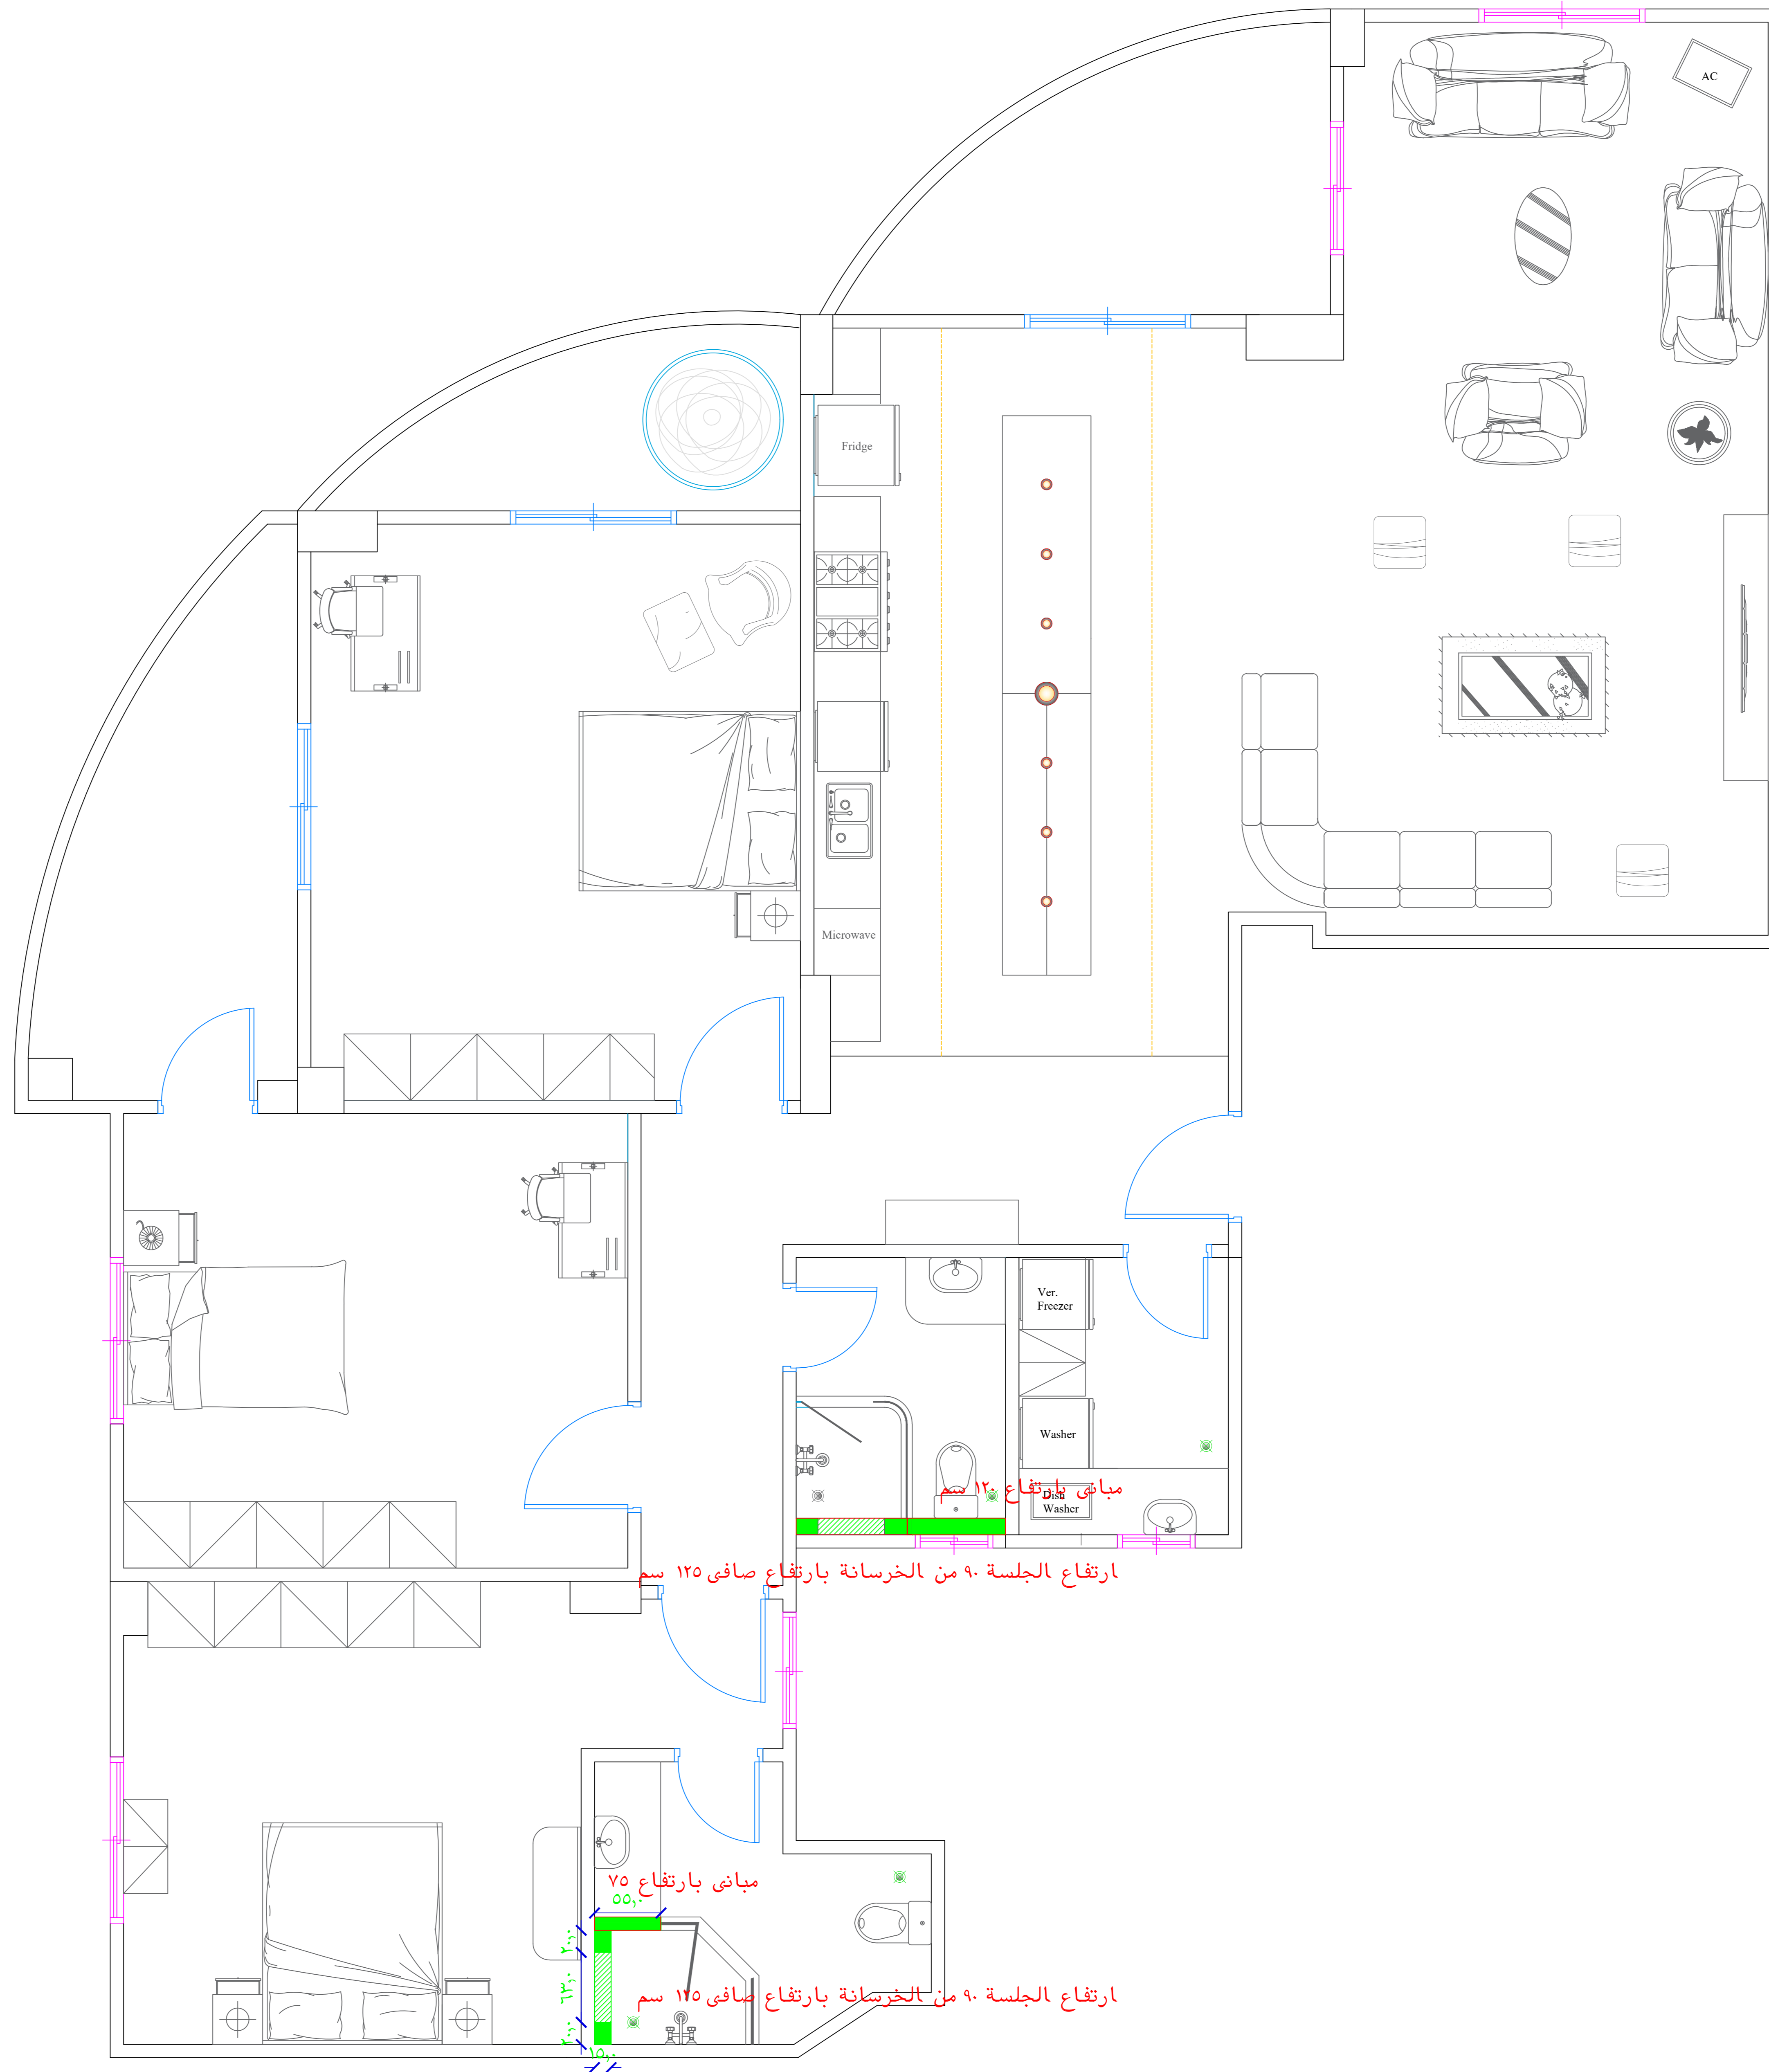

CLIENT NAME:

PROJECT NAME:

DRAWINGS TITLE:

DRAWN BY:

APPROVED BY:

DESCRIPTION:

Eng/ Ashraf Farag

TELEPHONE #:
(+20)1001689916

Ahmed Hesham

TELEPHONE #:
(+20)1116030118

SCALE:

Hesham Zayed

TELEPHONE #:
(+20)102032244

DATE: 10-09-2022

Masonry Plan

ADDRESS:
Interception of George Apyad with Abd-Elwareth Asr St
9th district Nasr city


Sheet Size: A3

Rev : 0



Great Home

The Best Design For your Great Home

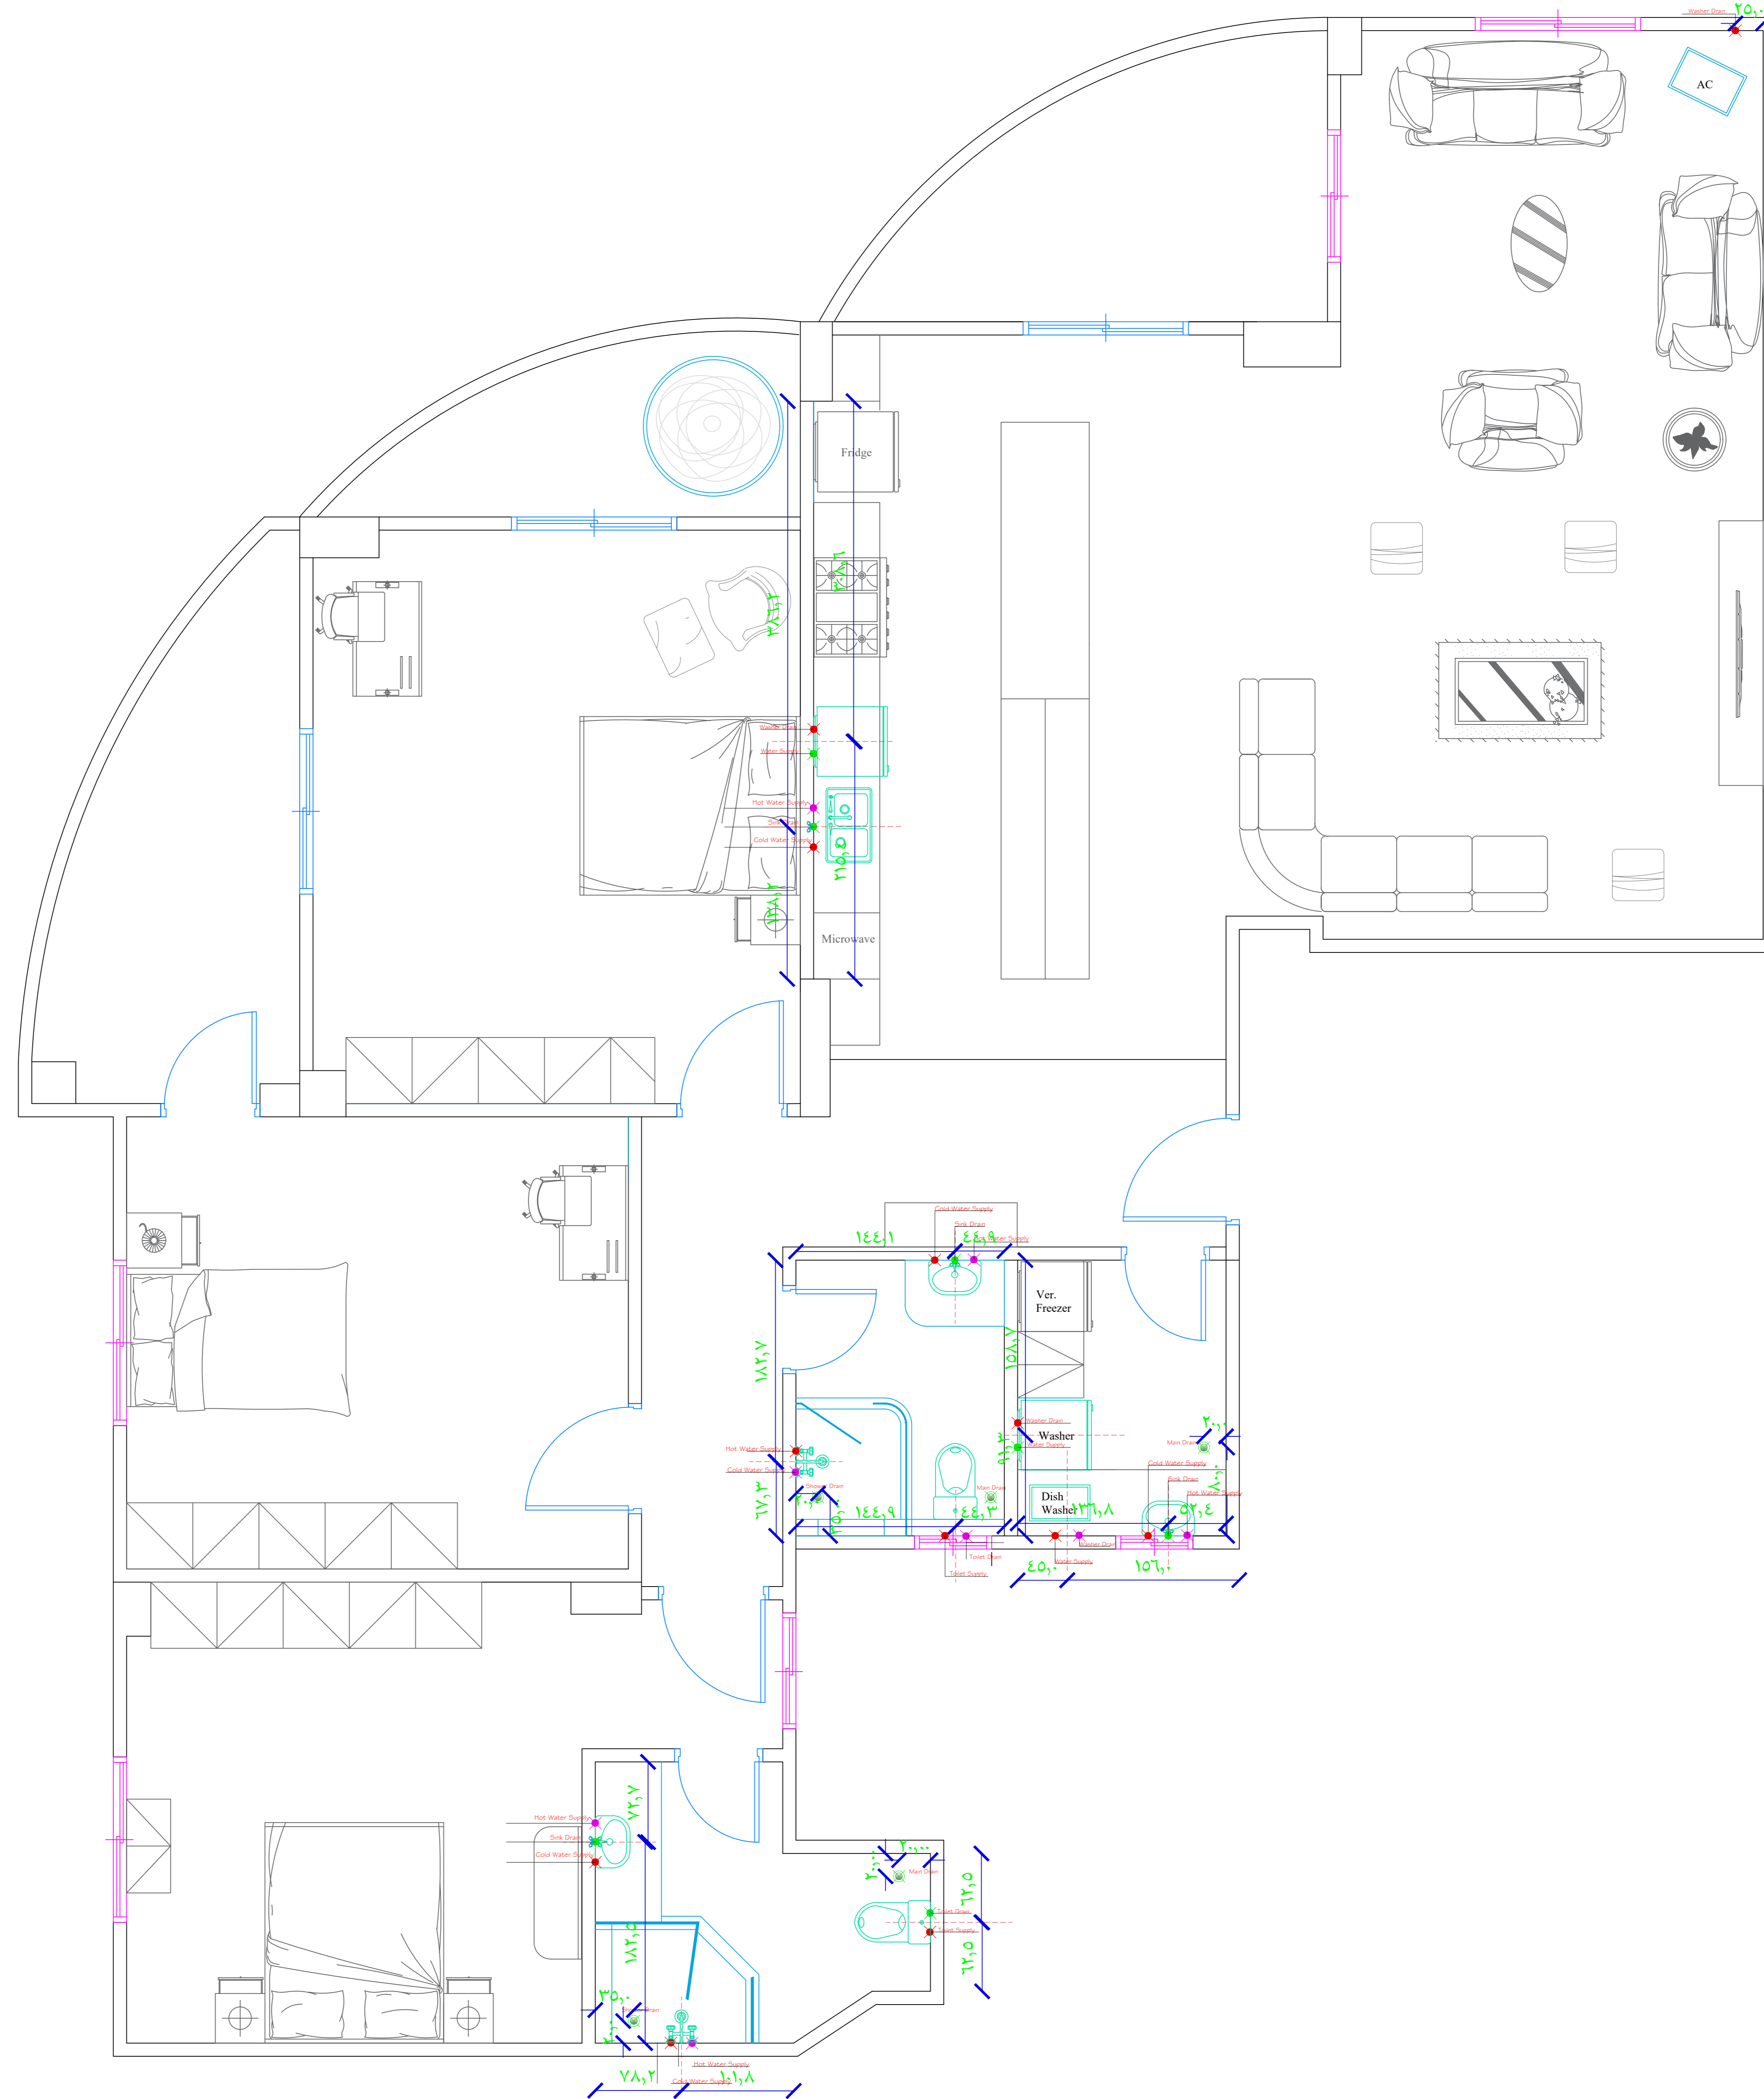

ADDRESS:
Interception of George Apyad with Abd-Elwareth Asr St
9th district Nasr city

CLIENT NAME:

Eng/ Ashraf Farag

TELEPHONE #:
(+20)1001689916

PROJECT NAME:

DRAWINGS TITLE:

Sheet Size: A3

Rev : 0

DRAWN BY:

Ahmed Hesham
TELEPHONE #:
(+20)1116030118

SCALE:


APPROVED BY:

Hesham Zayed
TELEPHONE #:
(+20)102032244

DATE: 22-08-2022

DESCRIPTION:

Plumbing Plan

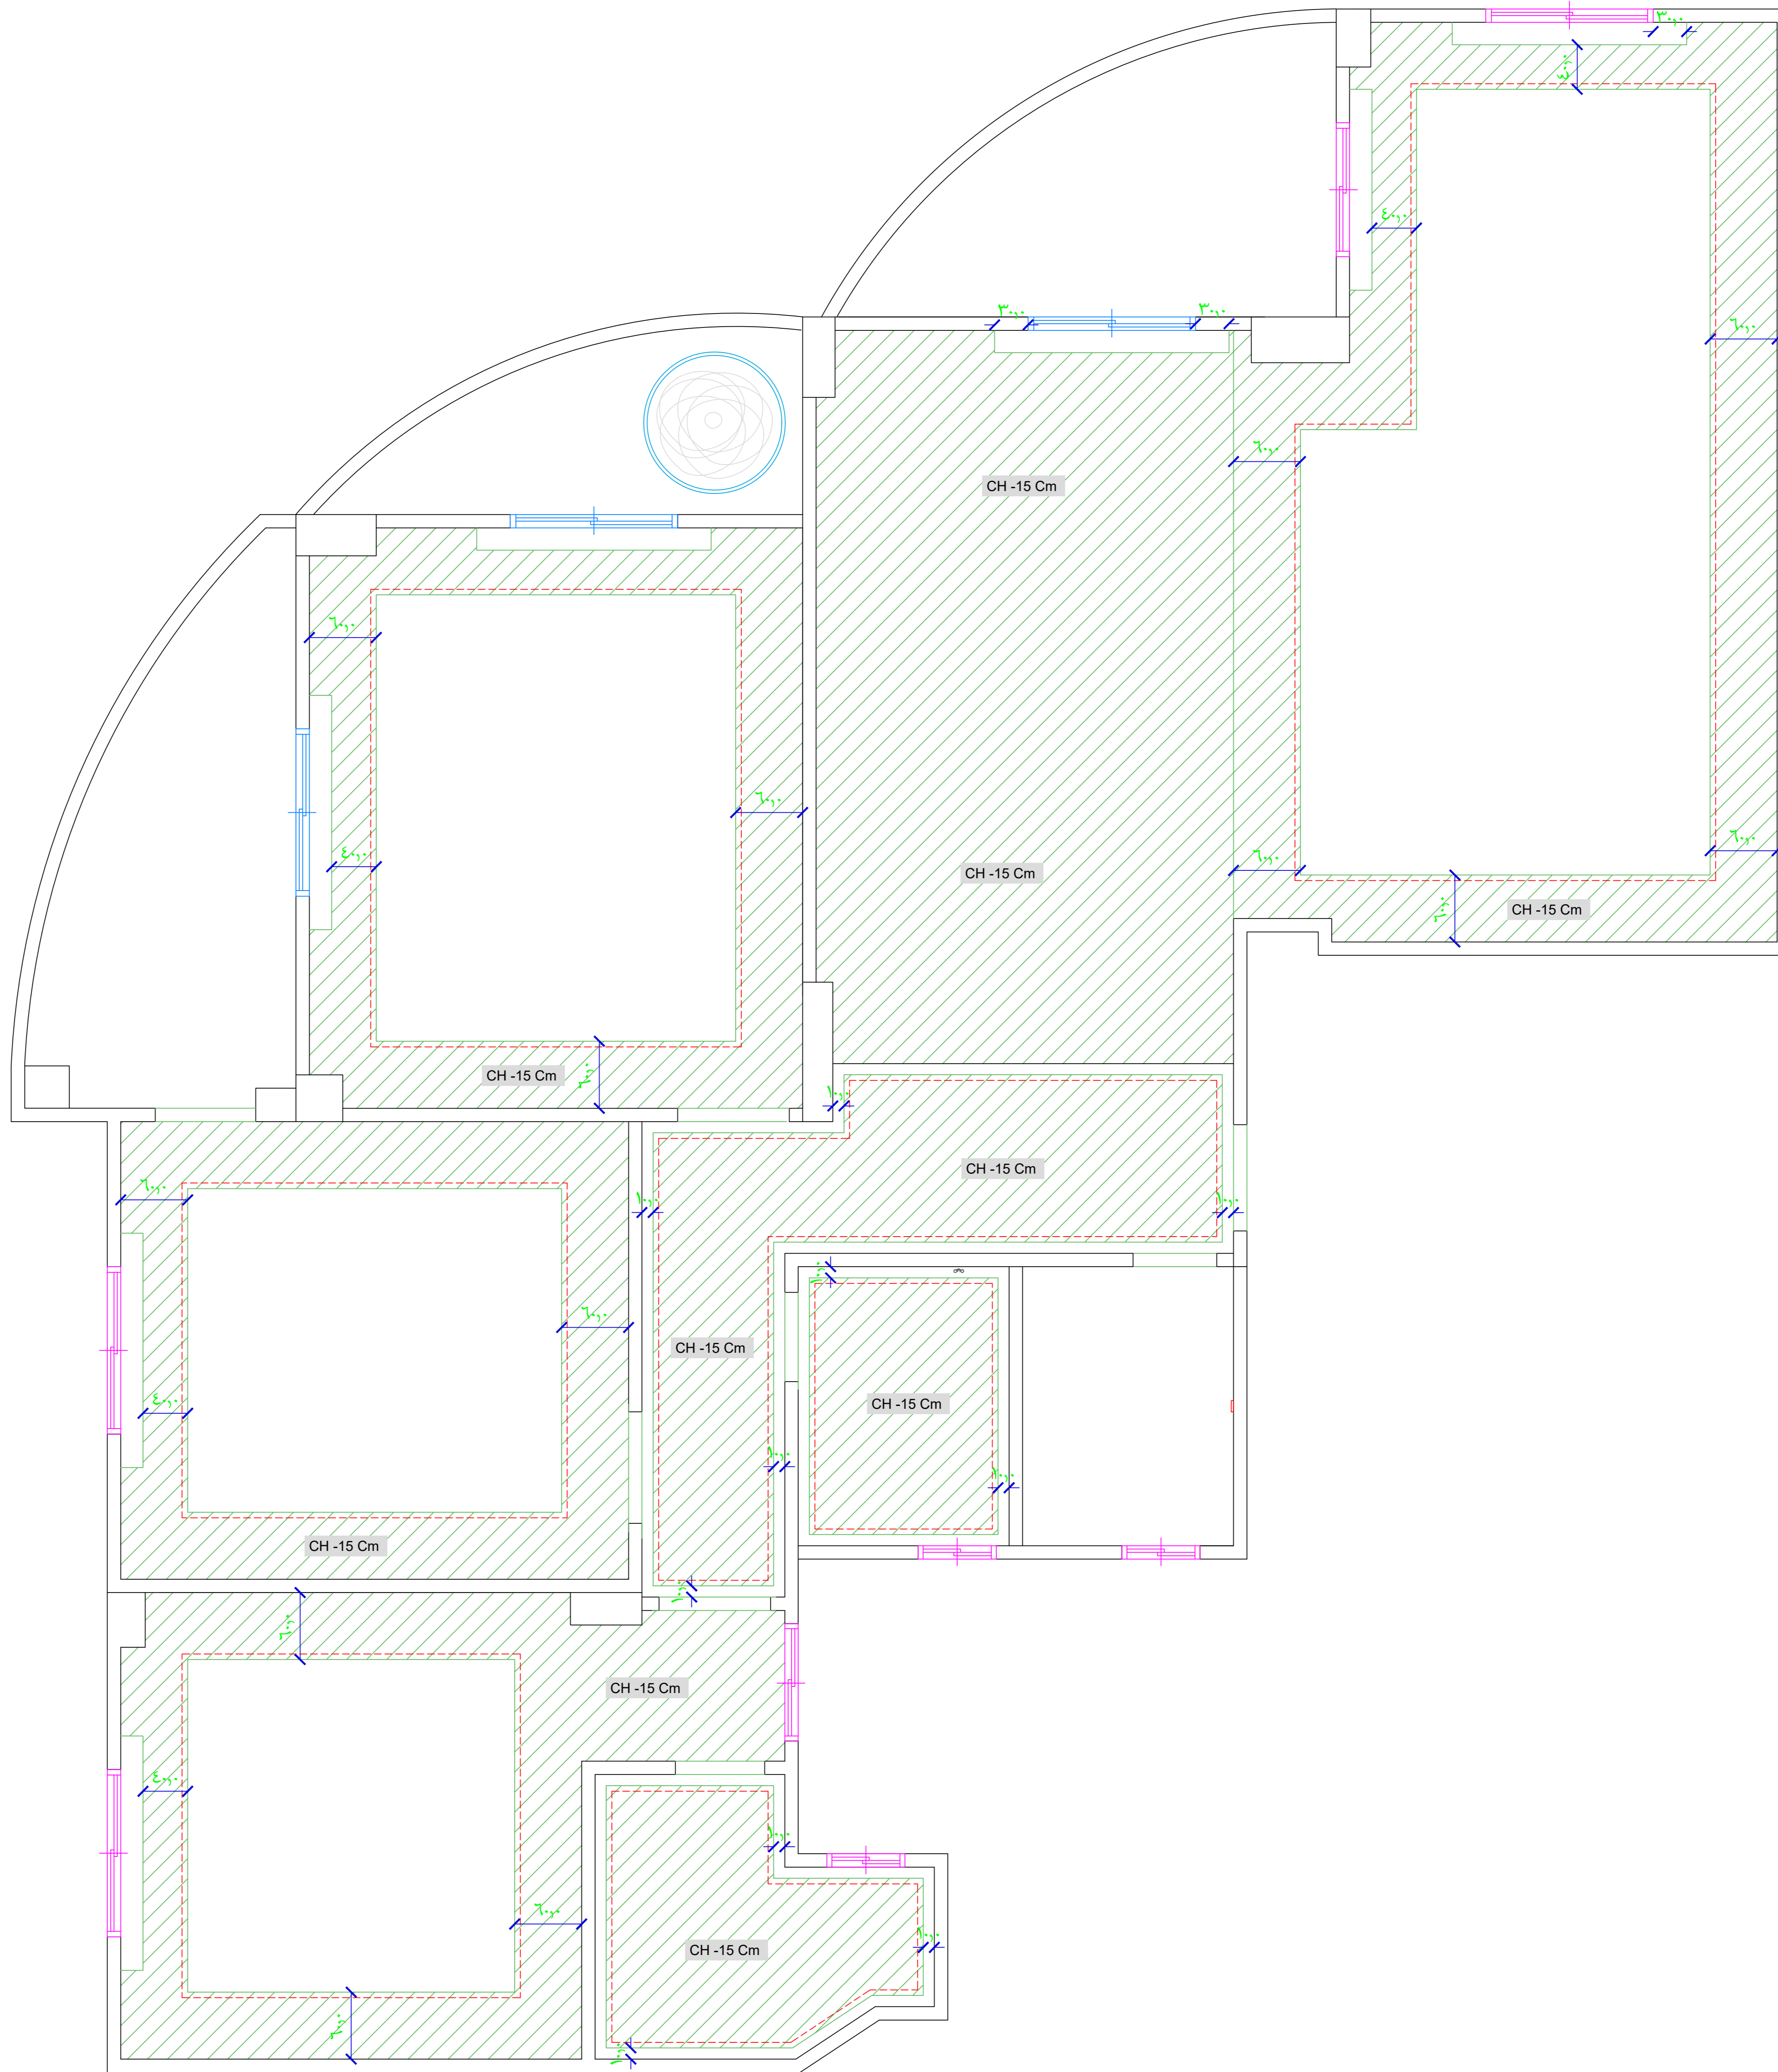

ADDRESS:
Interception of George Apyad with Abd-Elwareth Asr St
9th district Nasr city

CLIENT NAME:

Eng/ Ashraf Farag

TELEPHONE #:
(+20)1001689916

PROJECT NAME:

DRAWINGS TITLE:

Sheet Size: A3

Rev : 0

DRAWN BY:

Ahmed Hesham

TELEPHONE #:
(+20)1116030118

SCALE:

APPROVED BY:


Hesham Zayed

TELEPHONE #:
(+20)1020232244

DATE: 04-09-2022

DESCRIPTION:

Gypsum Board Ceiling Plan

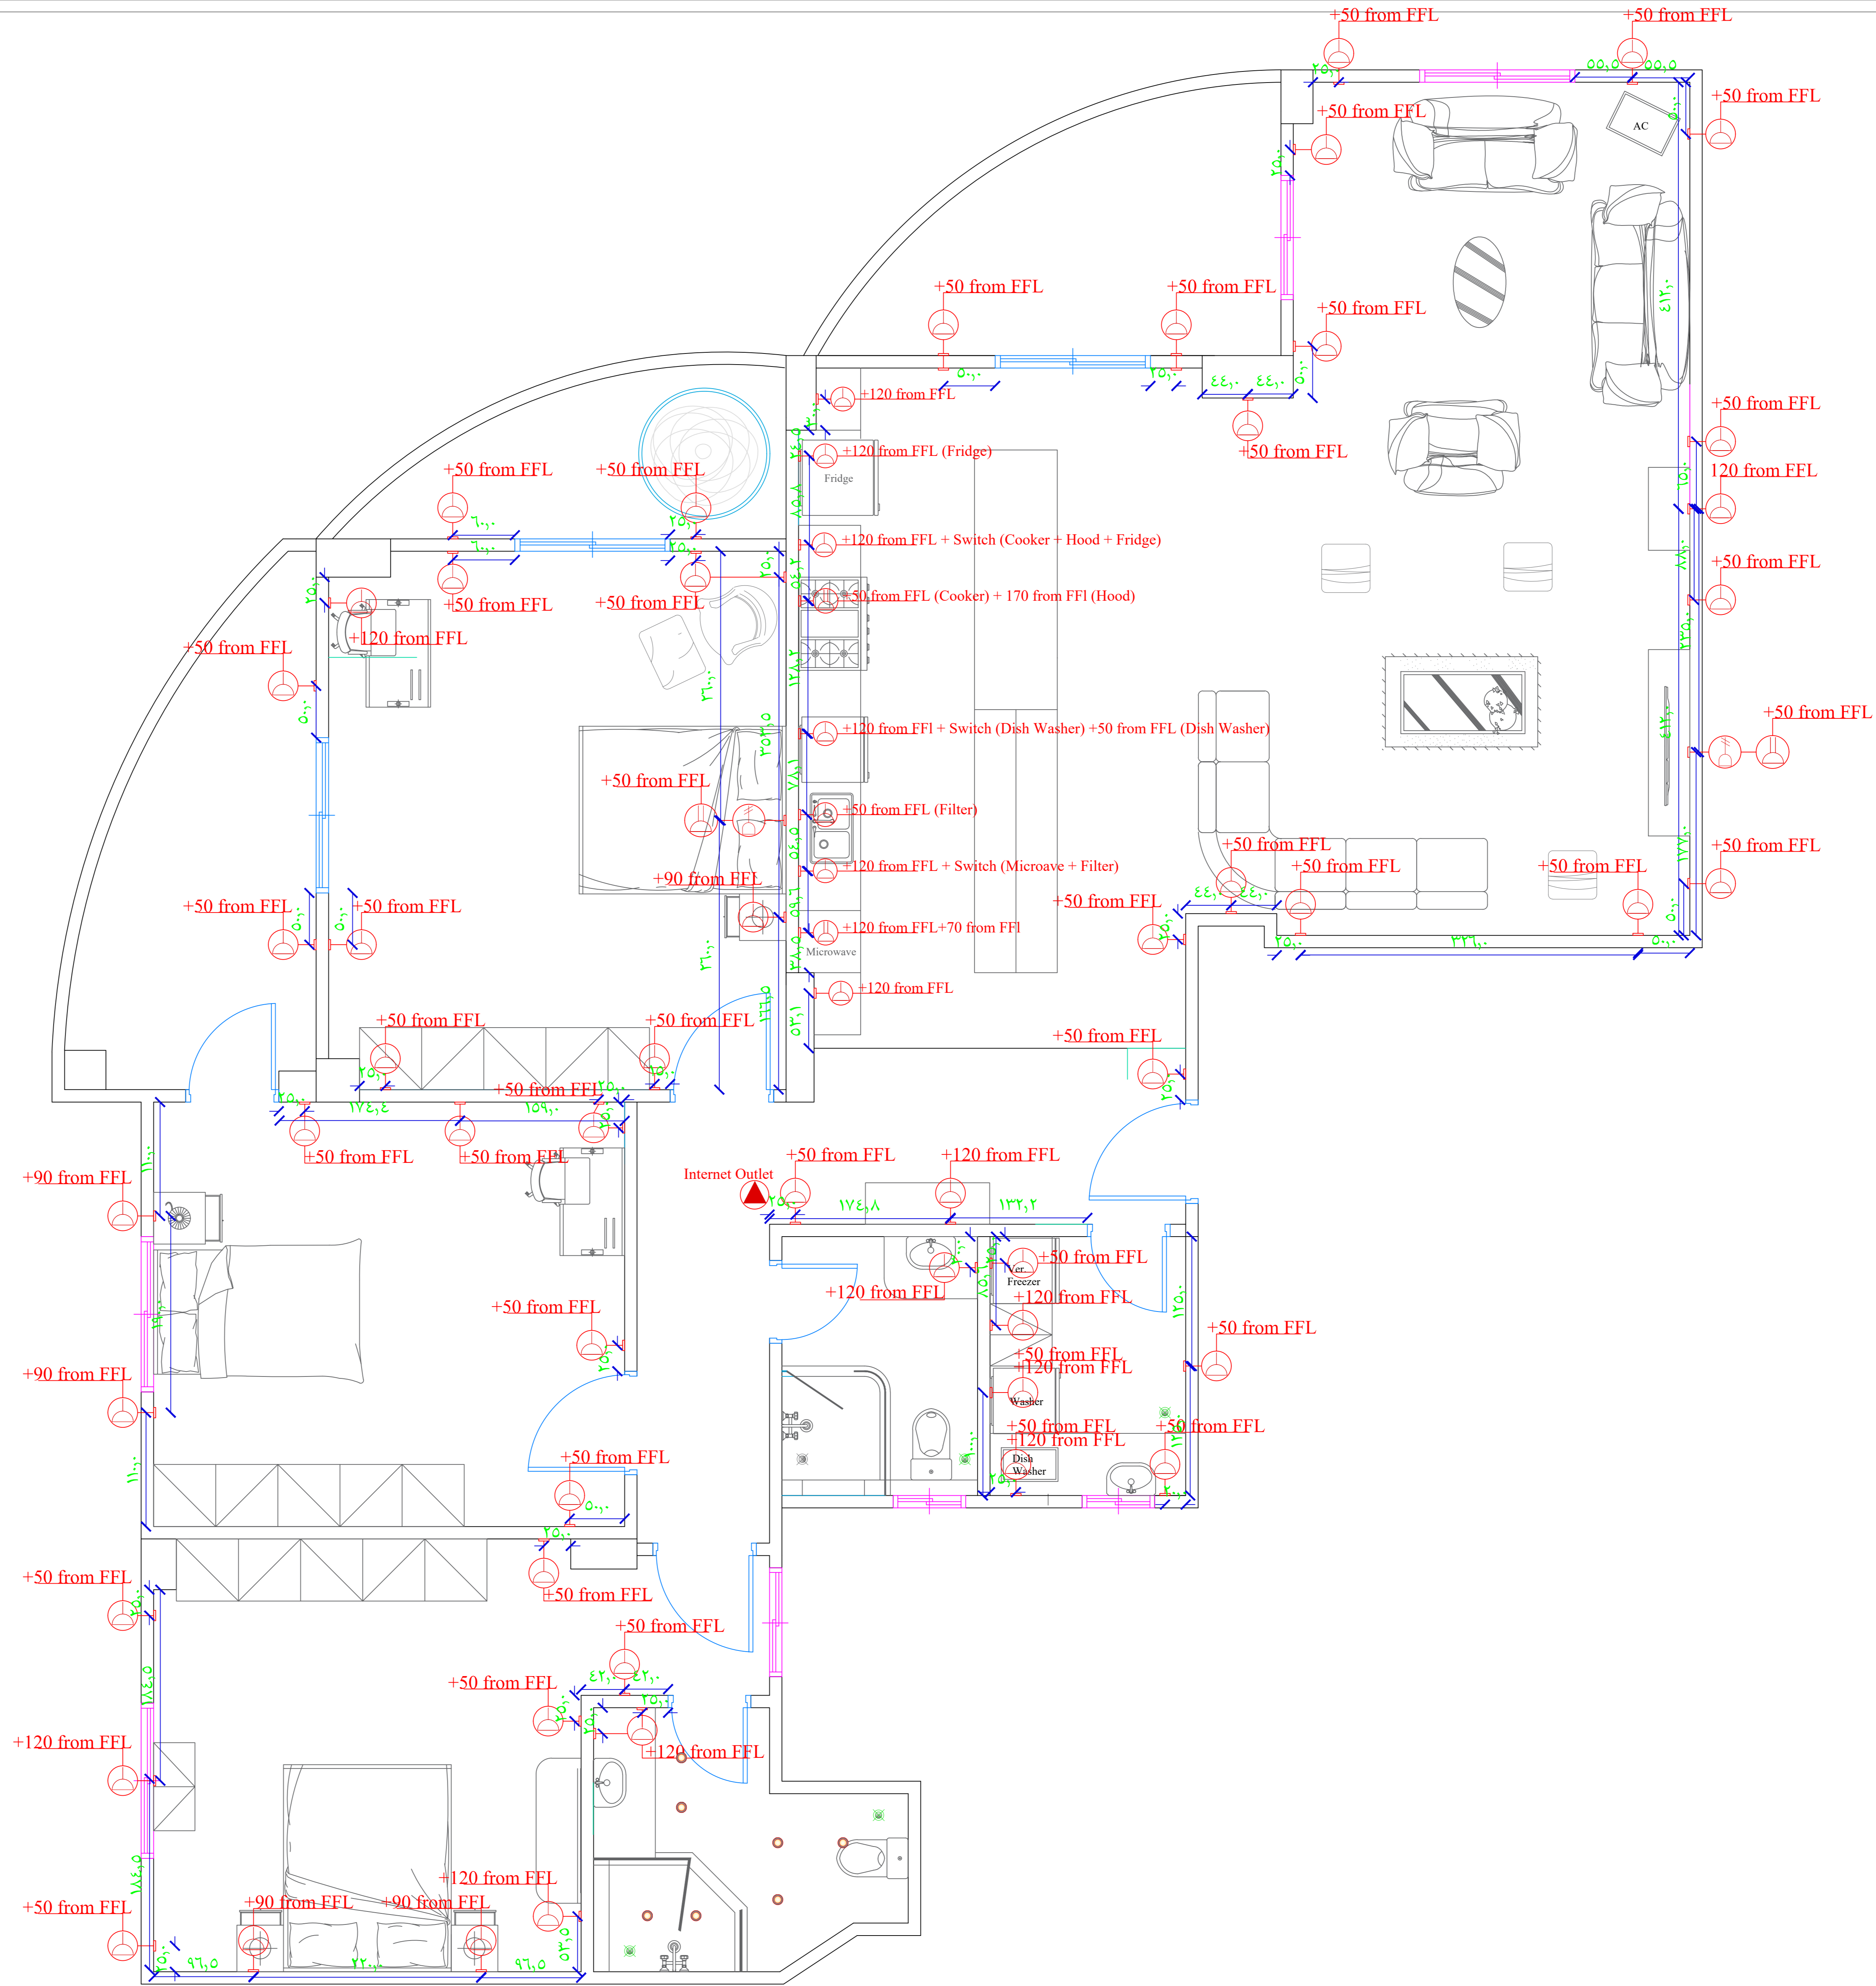

ADDRESS:
Interception of George Apyad with Abd-Elwareth Asr St
9th district Nasr city

CLIENT NAME:

Eng/ Ashraf Farag

TELEPHONE #:
(+20)1001689916

PROJECT NAME:

DRAWINGS TITLE:

Sheet Size: A3

Rev : 0

DRAWN BY:

Ahmed Hesham
TELEPHONE #:
(+20)1116030118

SCALE:

APPROVED BY:

Hesham Zayed
TELEPHONE #:
(+20)102032244

DATE: 05-09-2022

DESCRIPTION:

Power Plan



يُنْتَمِ رَمِي خَرْطُوم لِّلشِّفَاطِ وَتَوْصِيْلُهُ مَعَ
الْإِنَارَةِ الدَّرِيئِيَّةِ يَسِيْرَةٌ لِّلْحَمَامِ

| | | | | | | |
|---|--|---------------|-----------------|---|---|---|
| ADDRESS: Interception of George Apyad with Abd-Elwareth Asr St 9th district Nasr city | CLIENT NAME: | PROJECT NAME: | DRAWINGS TITLE: | DRAWN BY: | APPROVED BY: | DESCRIPTION: lighting & Switches & Lighting Tracks Plan |
| | Eng/ Ashraf Farag TELEPHONE #: (+20)1001689916 | | | Ahmed Hesham TELEPHONE #: (+20)1116030118 | Hesham Zayed TELEPHONE #: (+20)1020232244 | |
| | | | Sheet Size: A3 | SCALE: | DATE: 07-09-2022 | |
| | | | Rev : 0 | | | |