

ADDRESS:

CLIENT NAME:

PROJECT NAME:

DRAWINGS TITLE:

DRAWN BY:

APPROVED BY:

DESCRIPTION:

Abdallah Taher

TELEPHONE #:
(+20)1010081423

Sheet Size: A3

Rev : 0


Ahmed Hesham
TELEPHONE #:
(+20)1116030118


SCALE:

Hesham Zayed
TELEPHONE #:
(+20)1020232244

DATE: 15-8-2024

As Built Plan

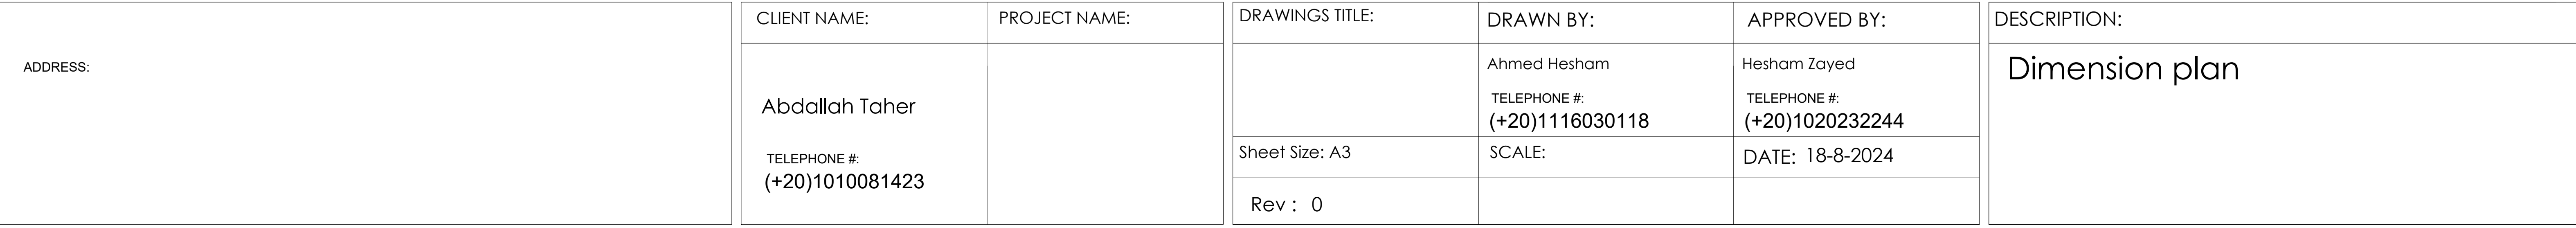

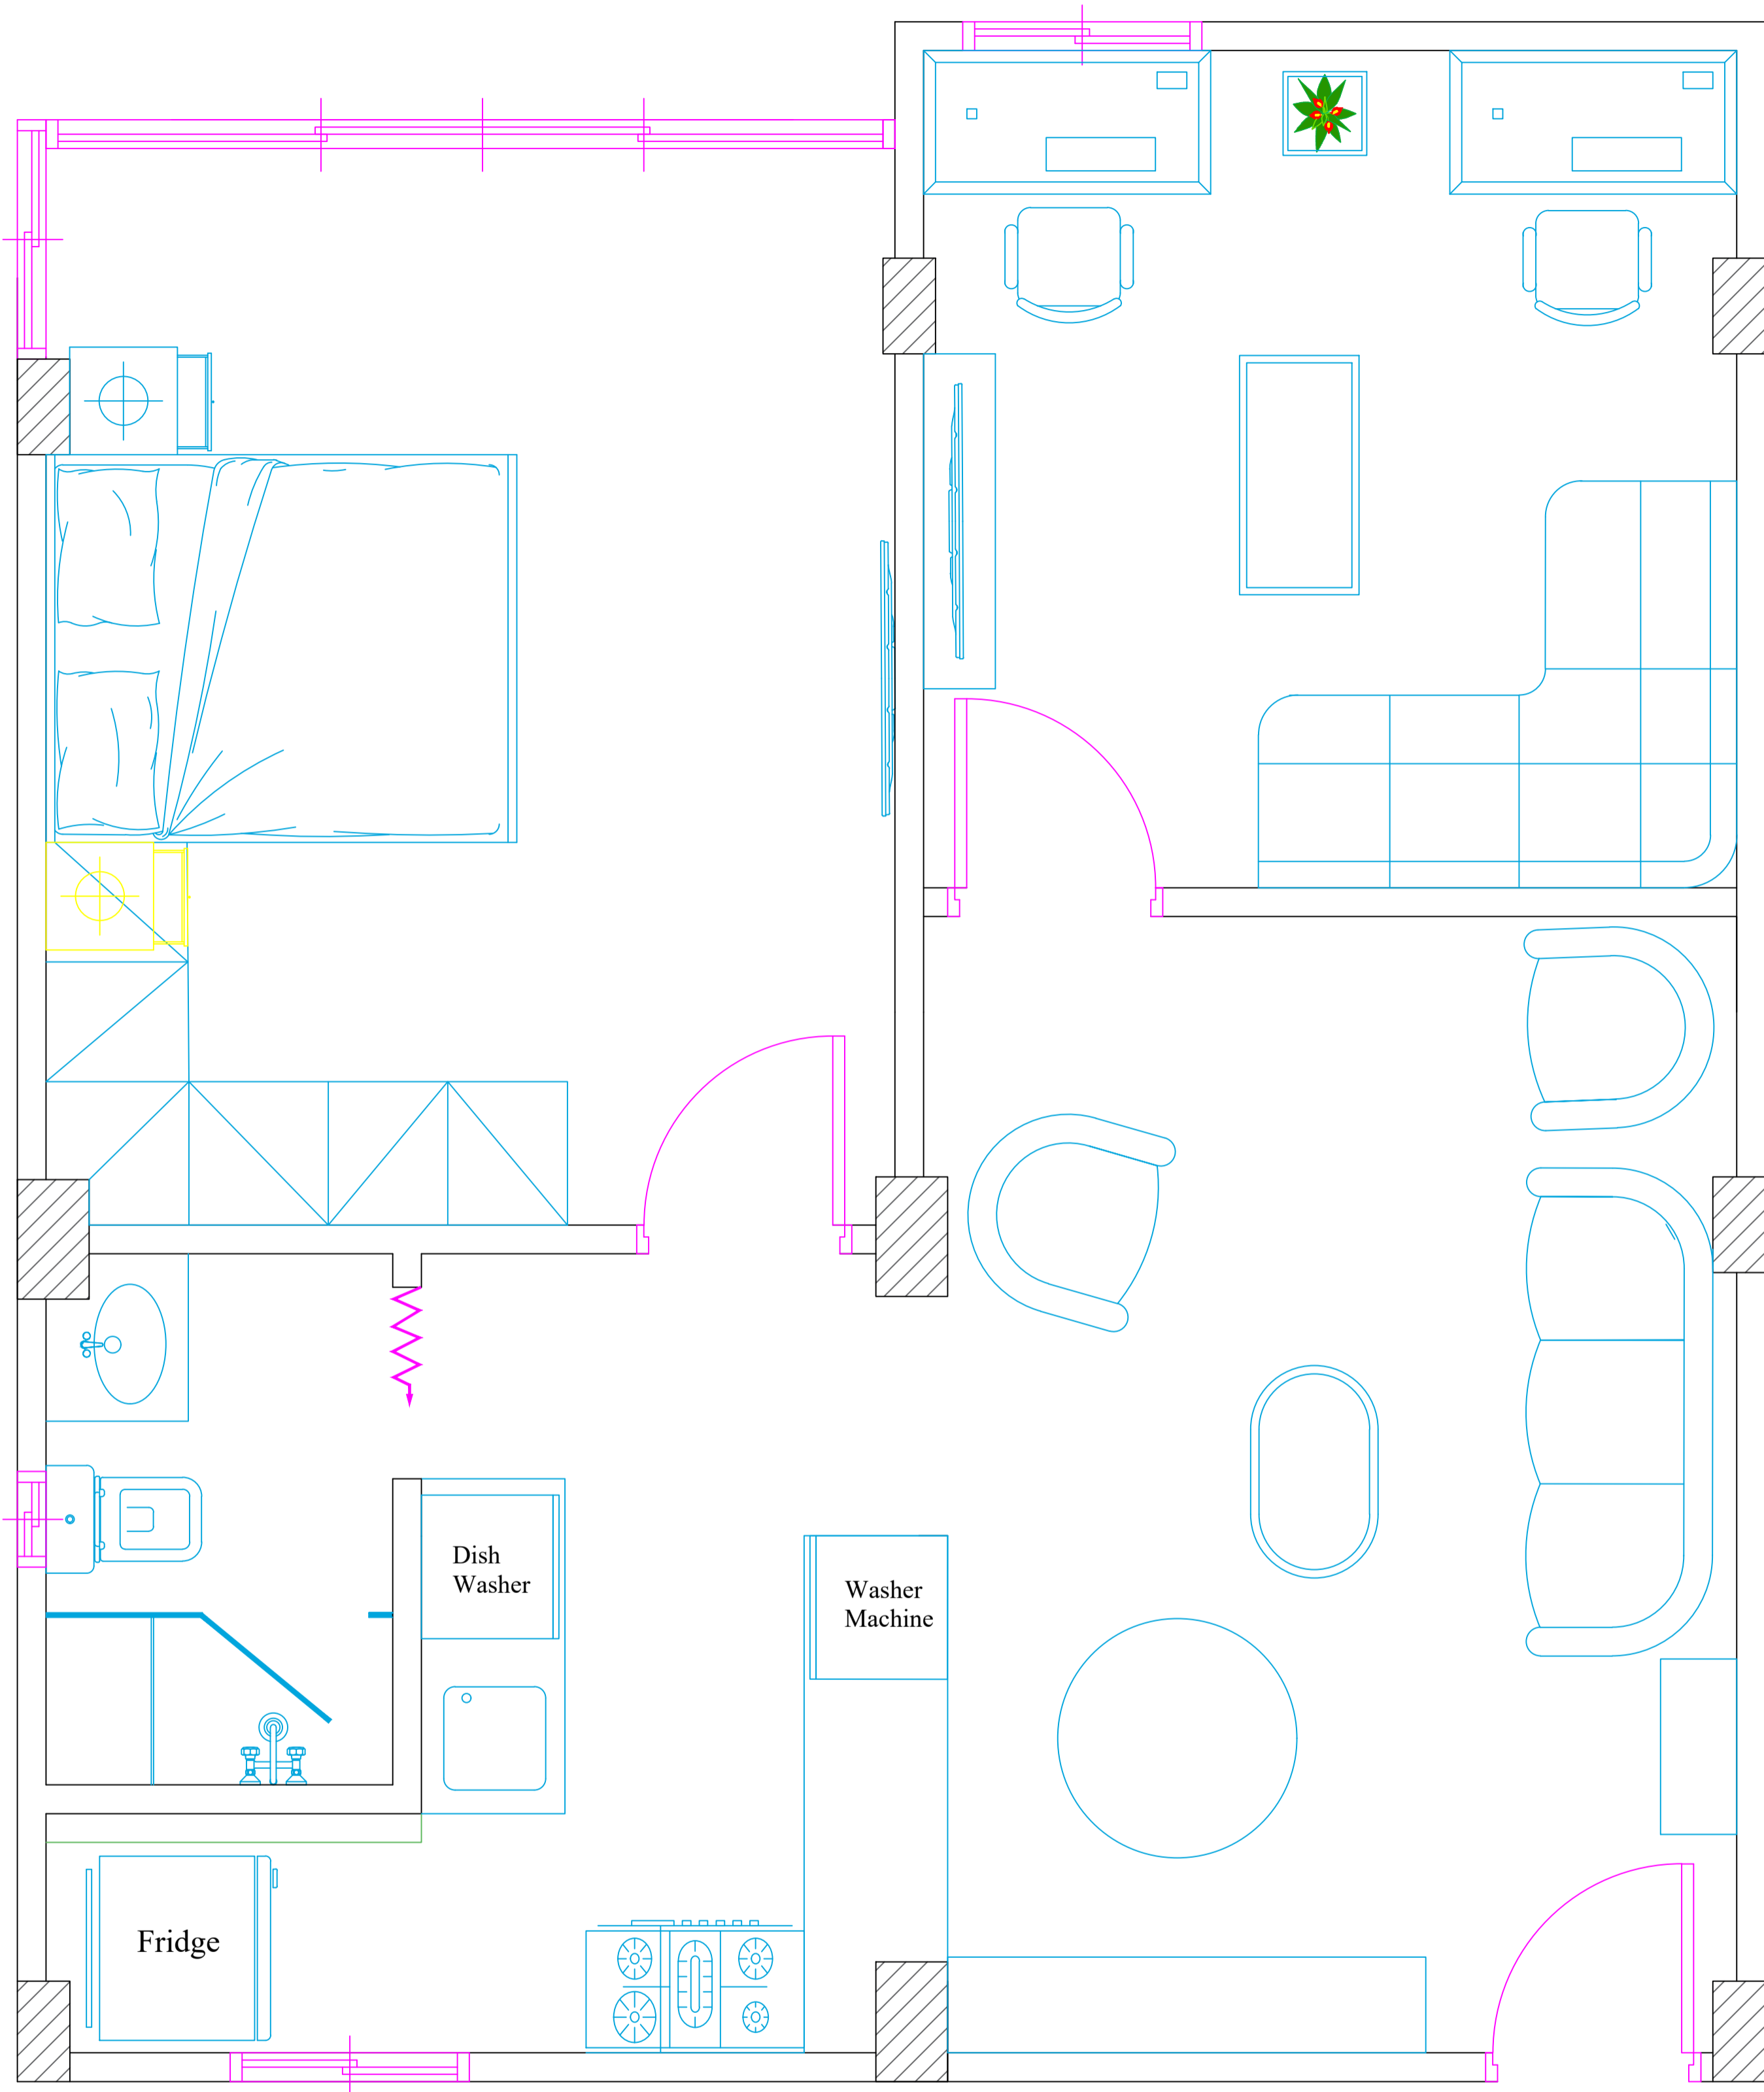

ADDRESS:


CLIENT NAME:	PROJECT NAME:
Abdallah Taher	
TELEPHONE #: (+20)1010081423	

DRAWINGS TITLE:
Sheet Size: A3
Rev : 0


DRAWN BY:
Ahmed Hesham
TELEPHONE #: (+20)1116030118
SCALE:

APPROVED BY:
Hesham Zayed
TELEPHONE #: (+20)102032244
DATE: 20-8-2024

DESCRIPTION:
Furniture plan

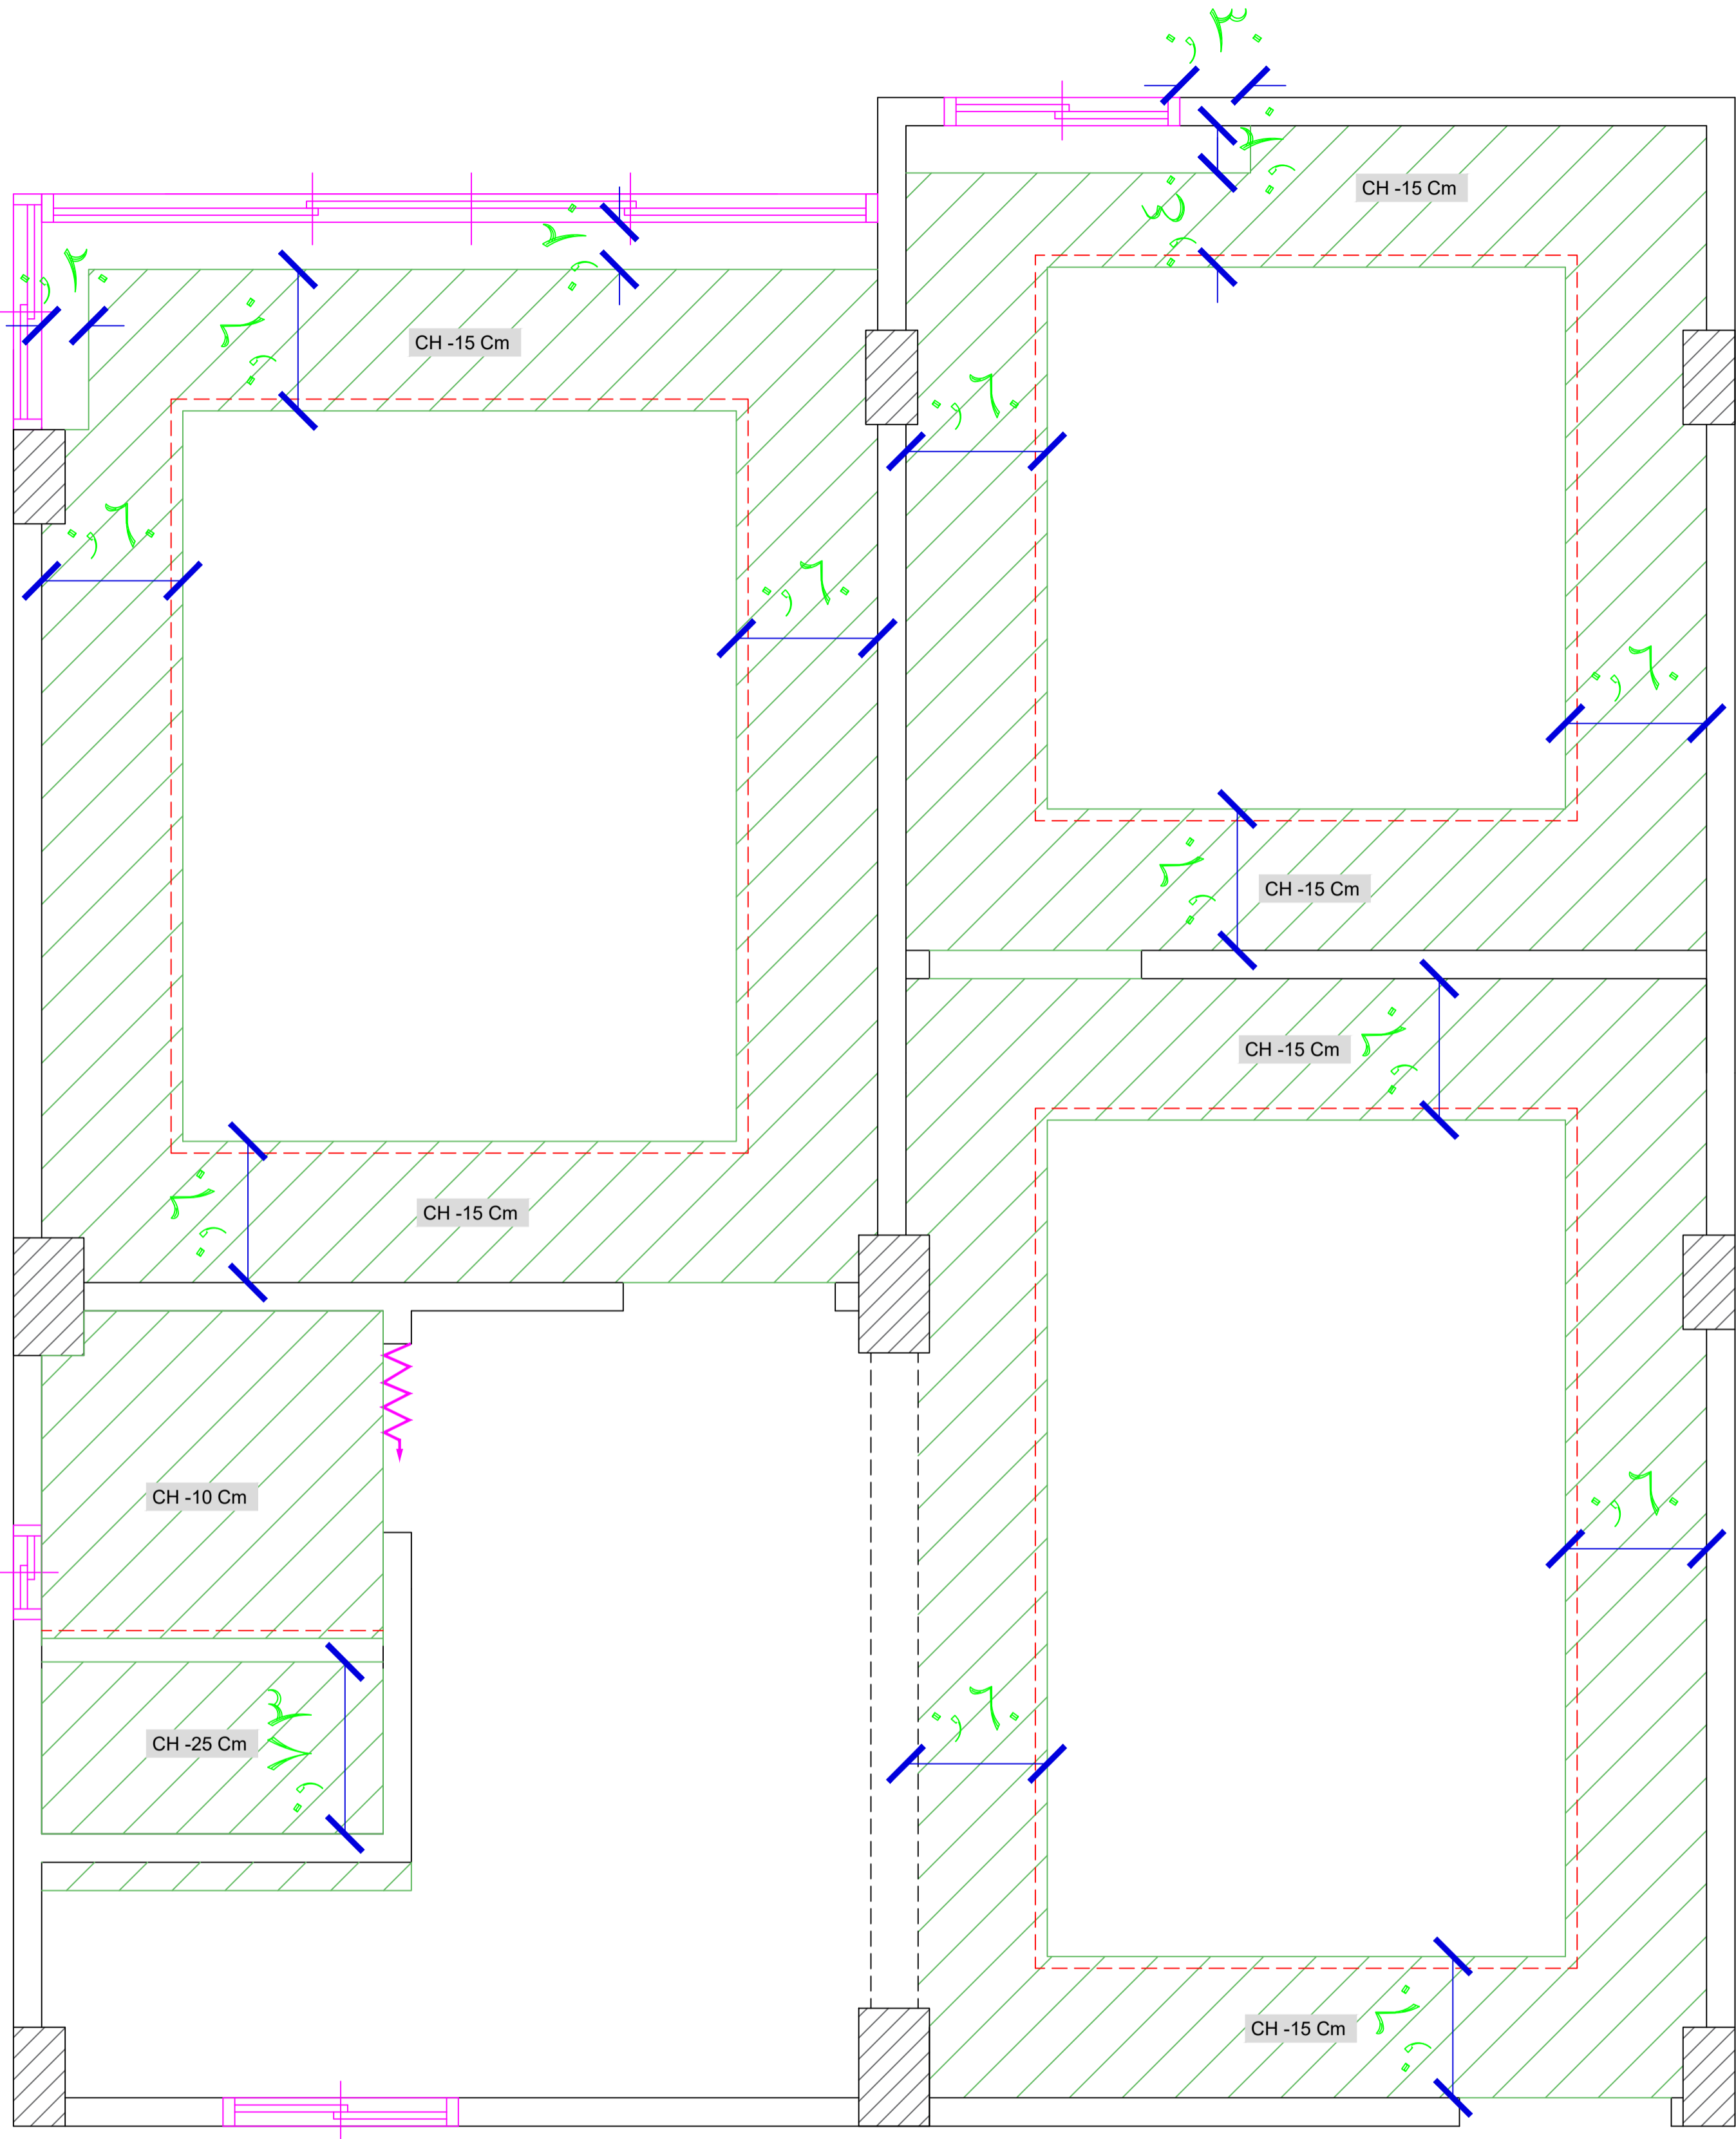

ADDRESS:	CLIENT NAME:	PROJECT NAME:	DRAWINGS TITLE:	DRAWN BY:	APPROVED BY:	DESCRIPTION: Ceiling Plan
	Abdallah Taher			Ahmed Hesham	Hesham Zayed	
	TELEPHONE #: (+20)1010081423		Sheet Size: A3	TELEPHONE #: (+20)1116030118	TELEPHONE #: (+20)1020232244	
			Rev : 0	SCALE:	DATE: 25-8-2024	

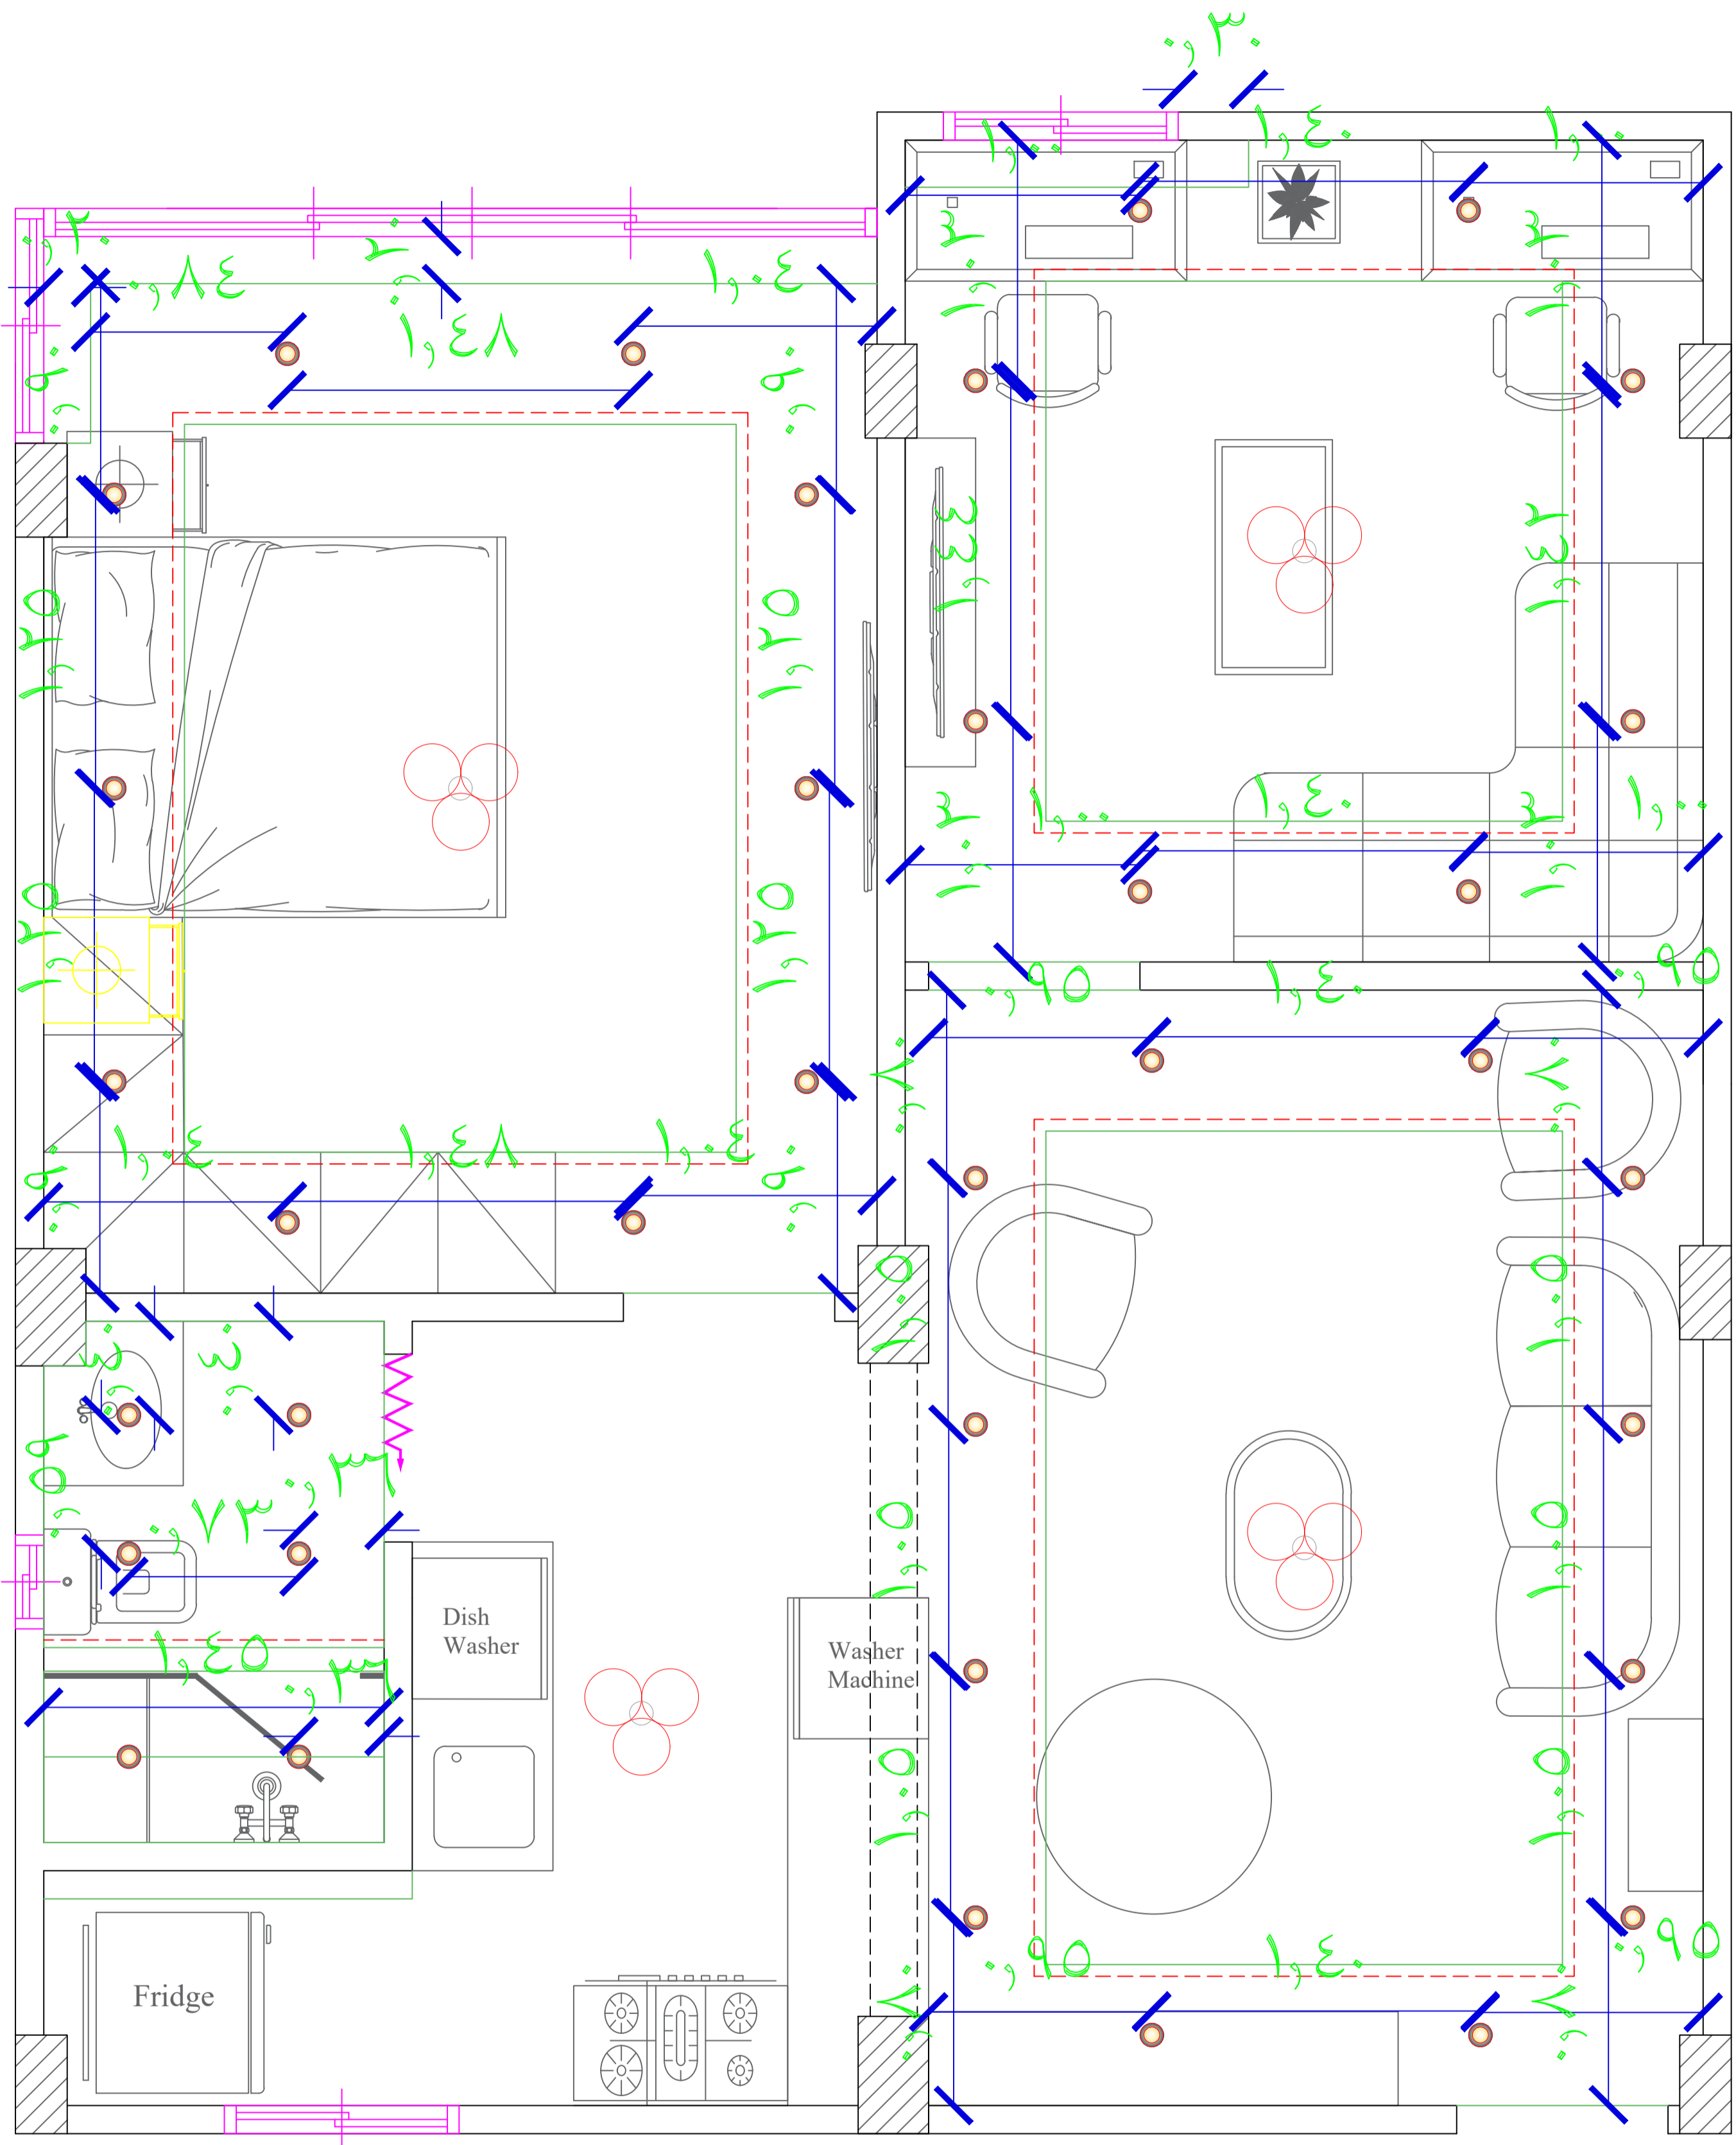

ADDRESS:

CLIENT NAME:

Abdallah Taher

TELEPHONE #:
(+20)1010081423

PROJECT NAME:

DRAWINGS TITLE:

Sheet Size: A3

Rev : 0

DRAWN BY:

Ahmed Hesham
TELEPHONE #:
(+20)1116030118

SCALE:


APPROVED BY:

Hesham Zayed
TELEPHONE #:
(+20)102032244


DATE: 27-8-2024

DESCRIPTION:


Ceiling Lighting plan

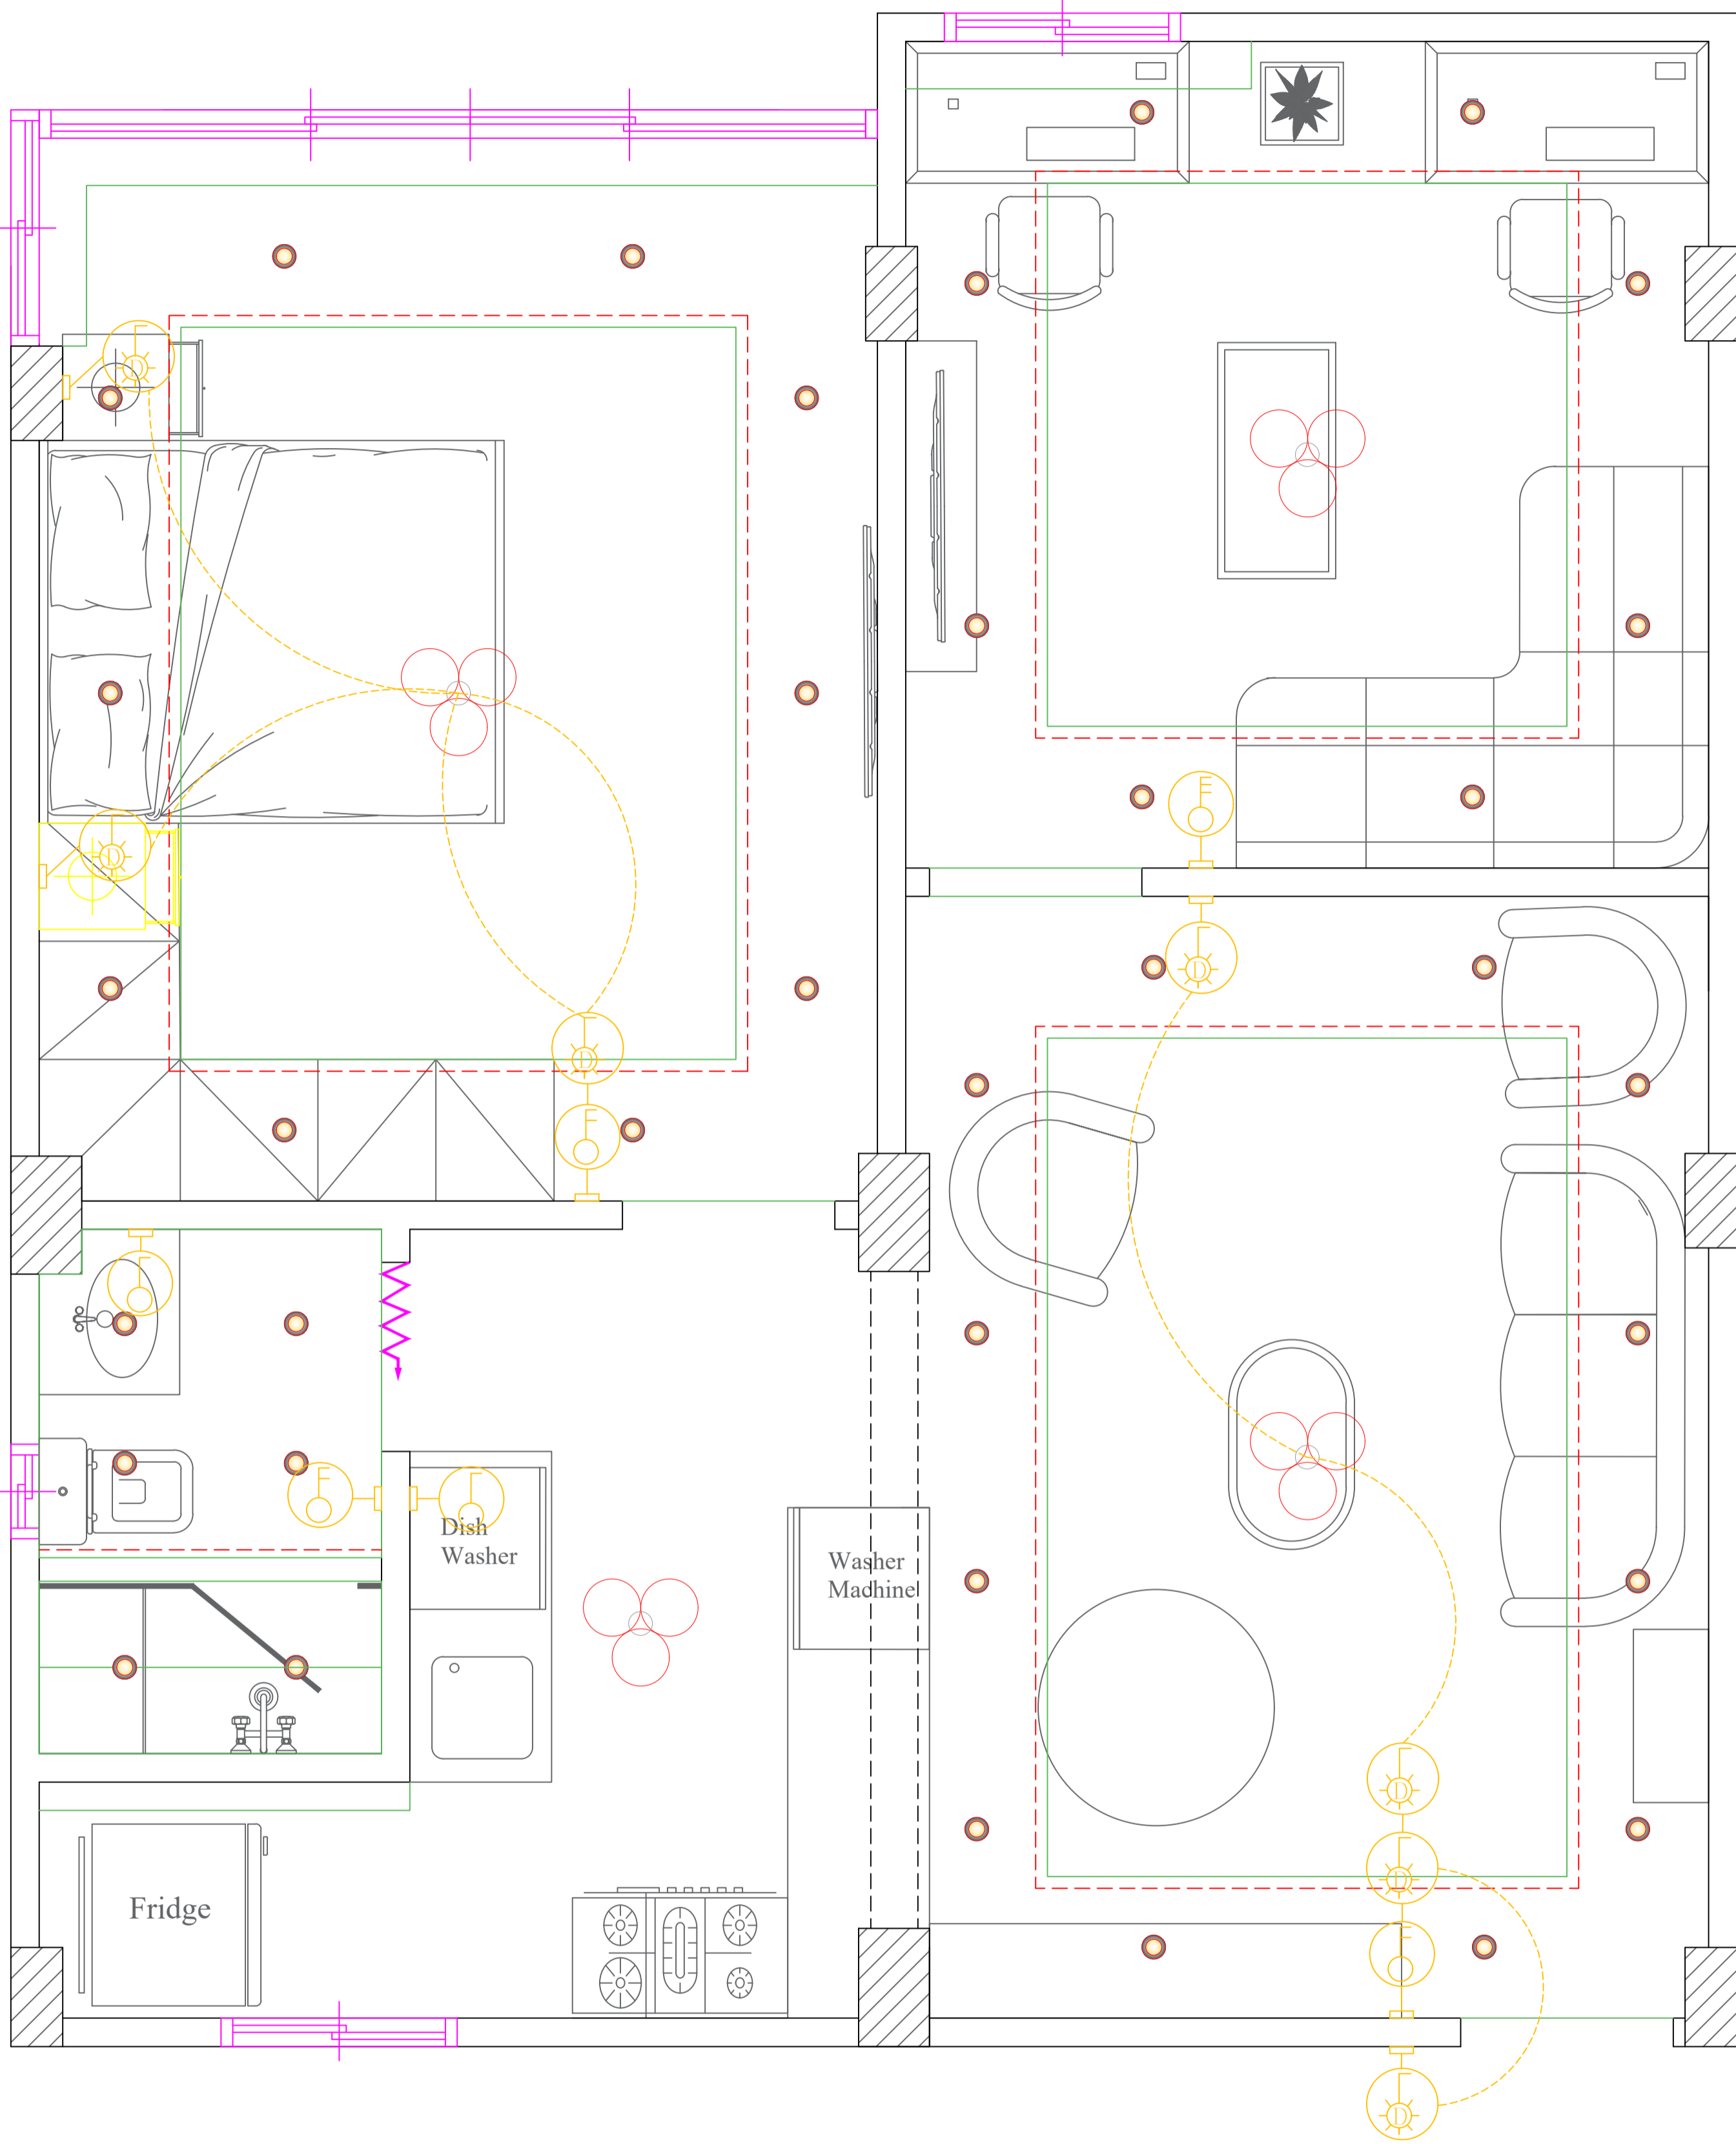

ADDRESS:	CLIENT NAME:	PROJECT NAME:	DRAWINGS TITLE:	DRAWN BY:	APPROVED BY:	DESCRIPTION: Light Switches and Lighting tracks plan
	Abdallah Taher			Ahmed Hesham	Hesham Zayed	
	TELEPHONE #: (+20)1010081423		Sheet Size: A3	TELEPHONE #: (+20)1116030118 SCALE:	TELEPHONE #: (+20)1020232244 DATE: 29-8-2024	
			Rev : 0			

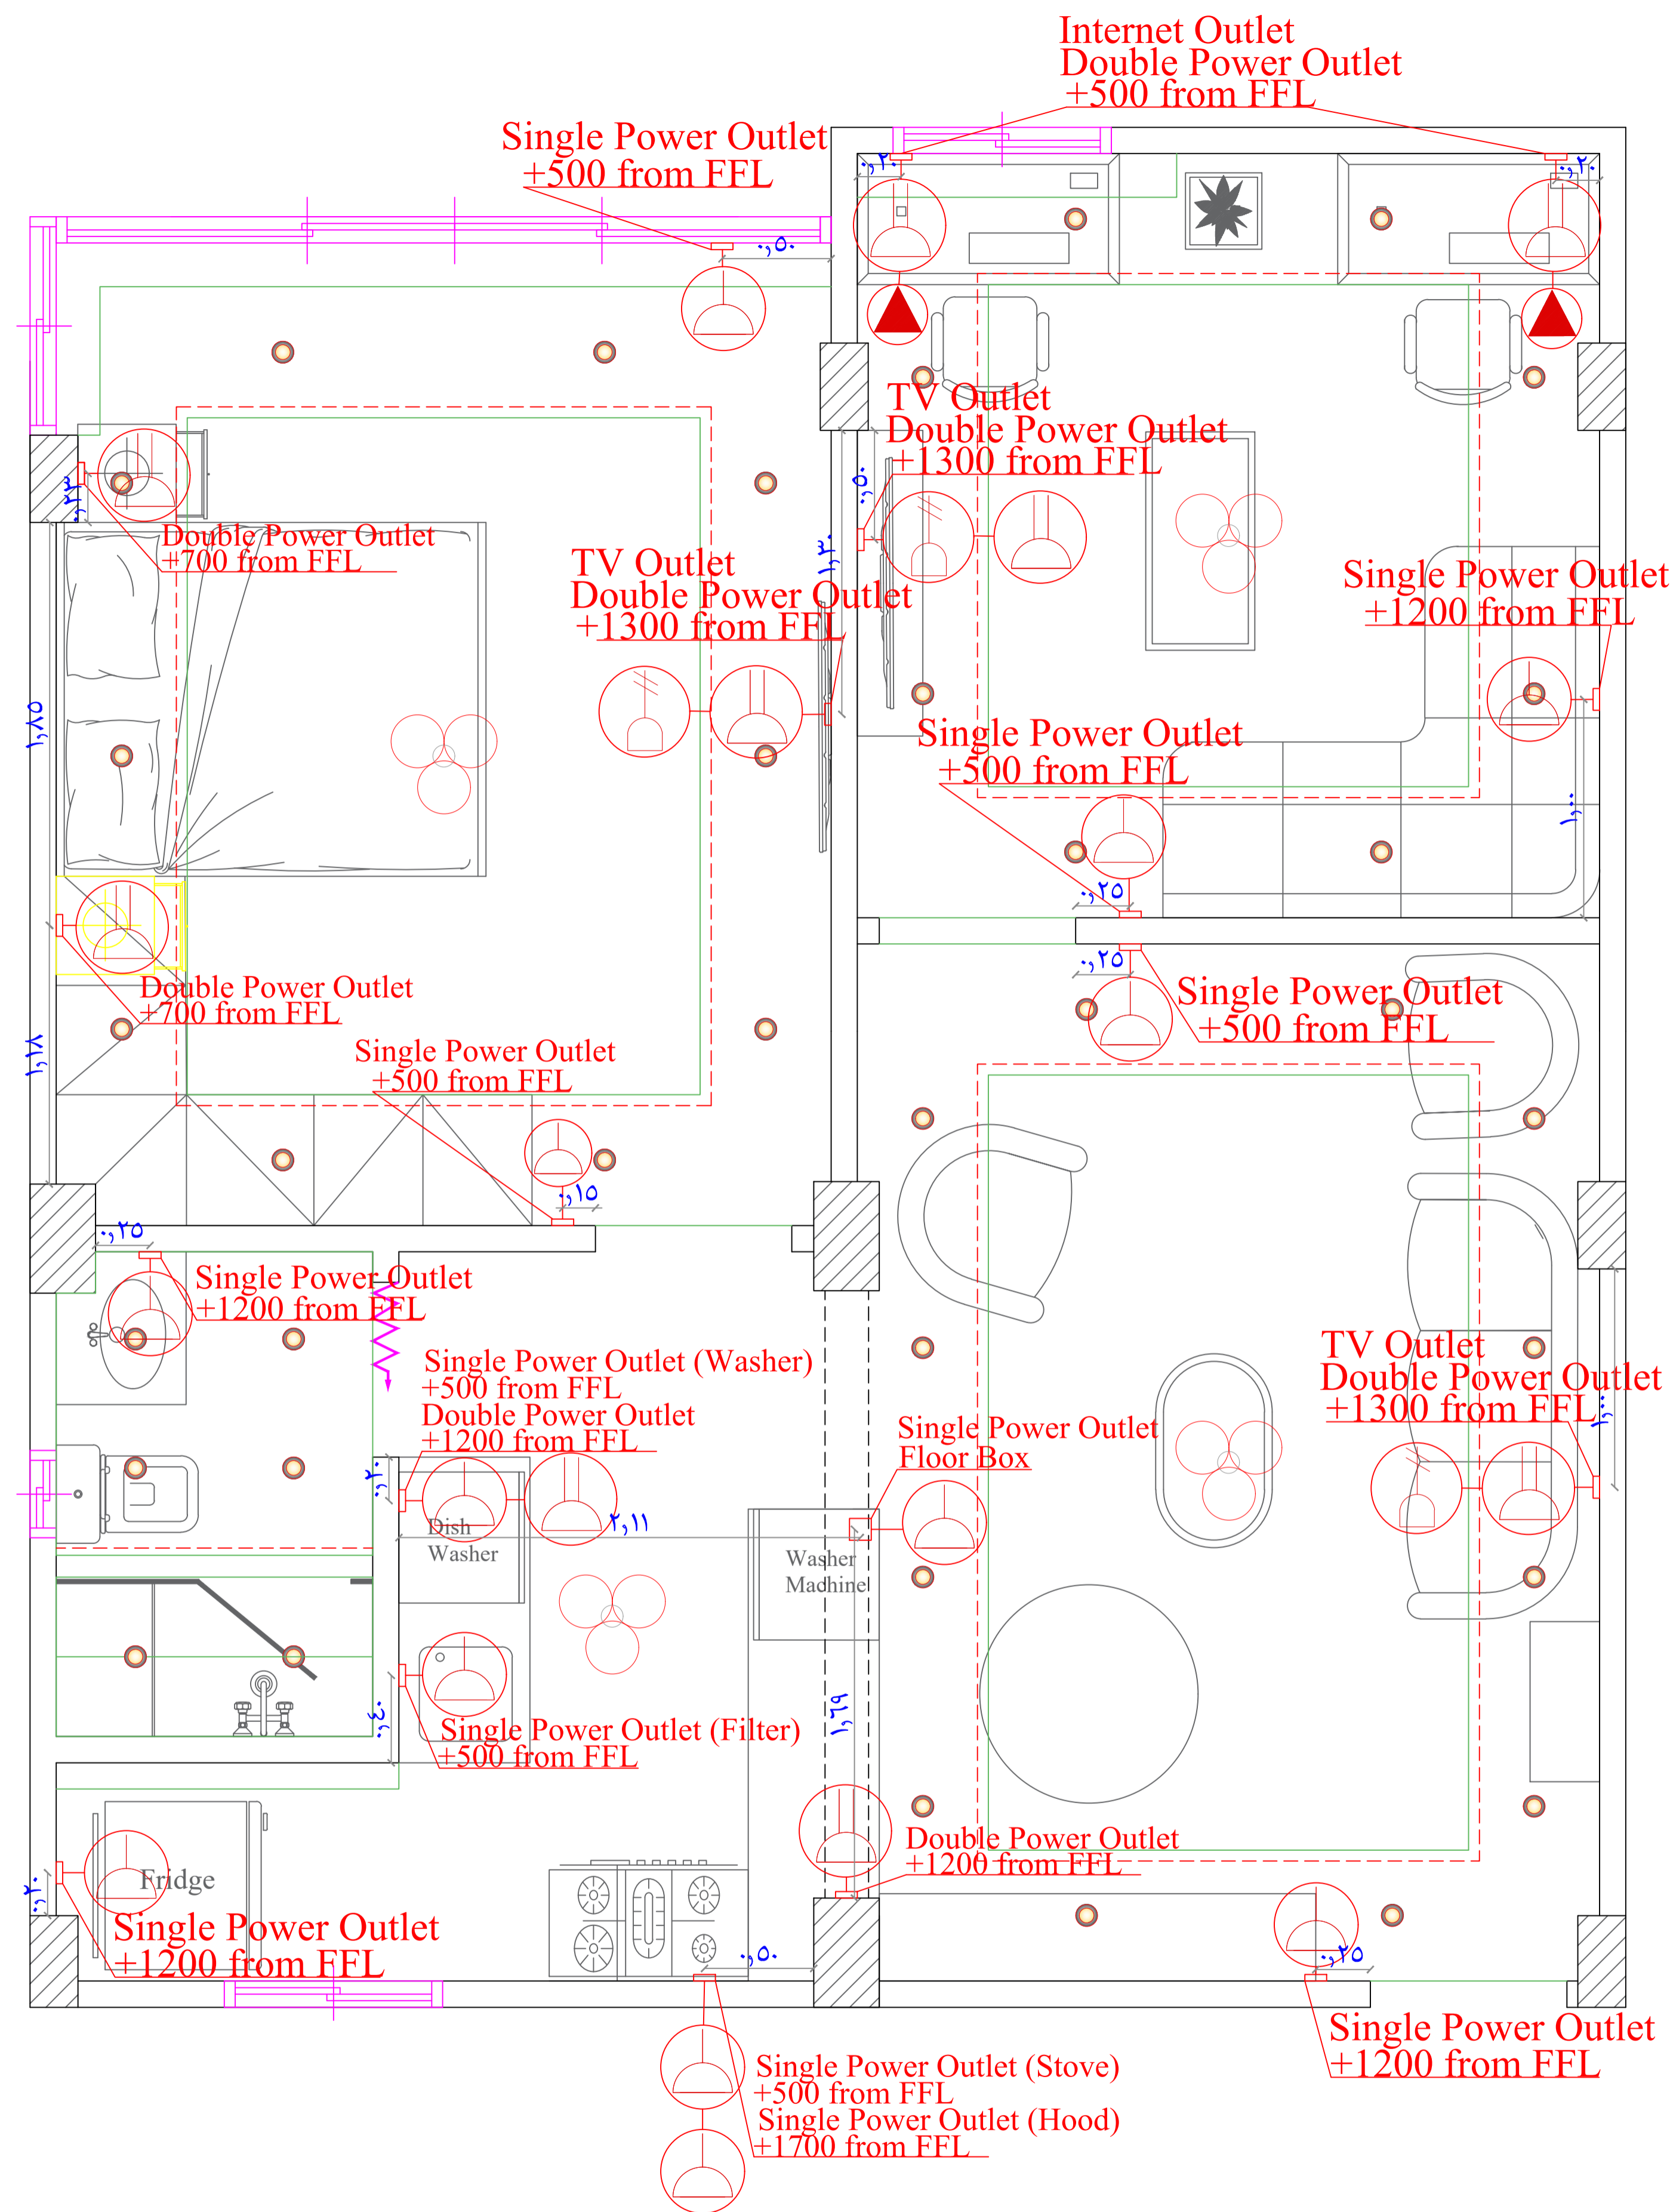

ADDRESS:	CLIENT NAME:	PROJECT NAME:	DRAWINGS TITLE:	DRAWN BY:	APPROVED BY:	DESCRIPTION: Power plan
	Abdallah Taher			Ahmed Hesham	Hesham Zayed	
	TELEPHONE #: (+20)1010081423		Sheet Size: A3	TELEPHONE #: (+20)1116030118	TELEPHONE #: (+20)102032244	
			Rev : 0	SCALE:	DATE: 29-8-2024	

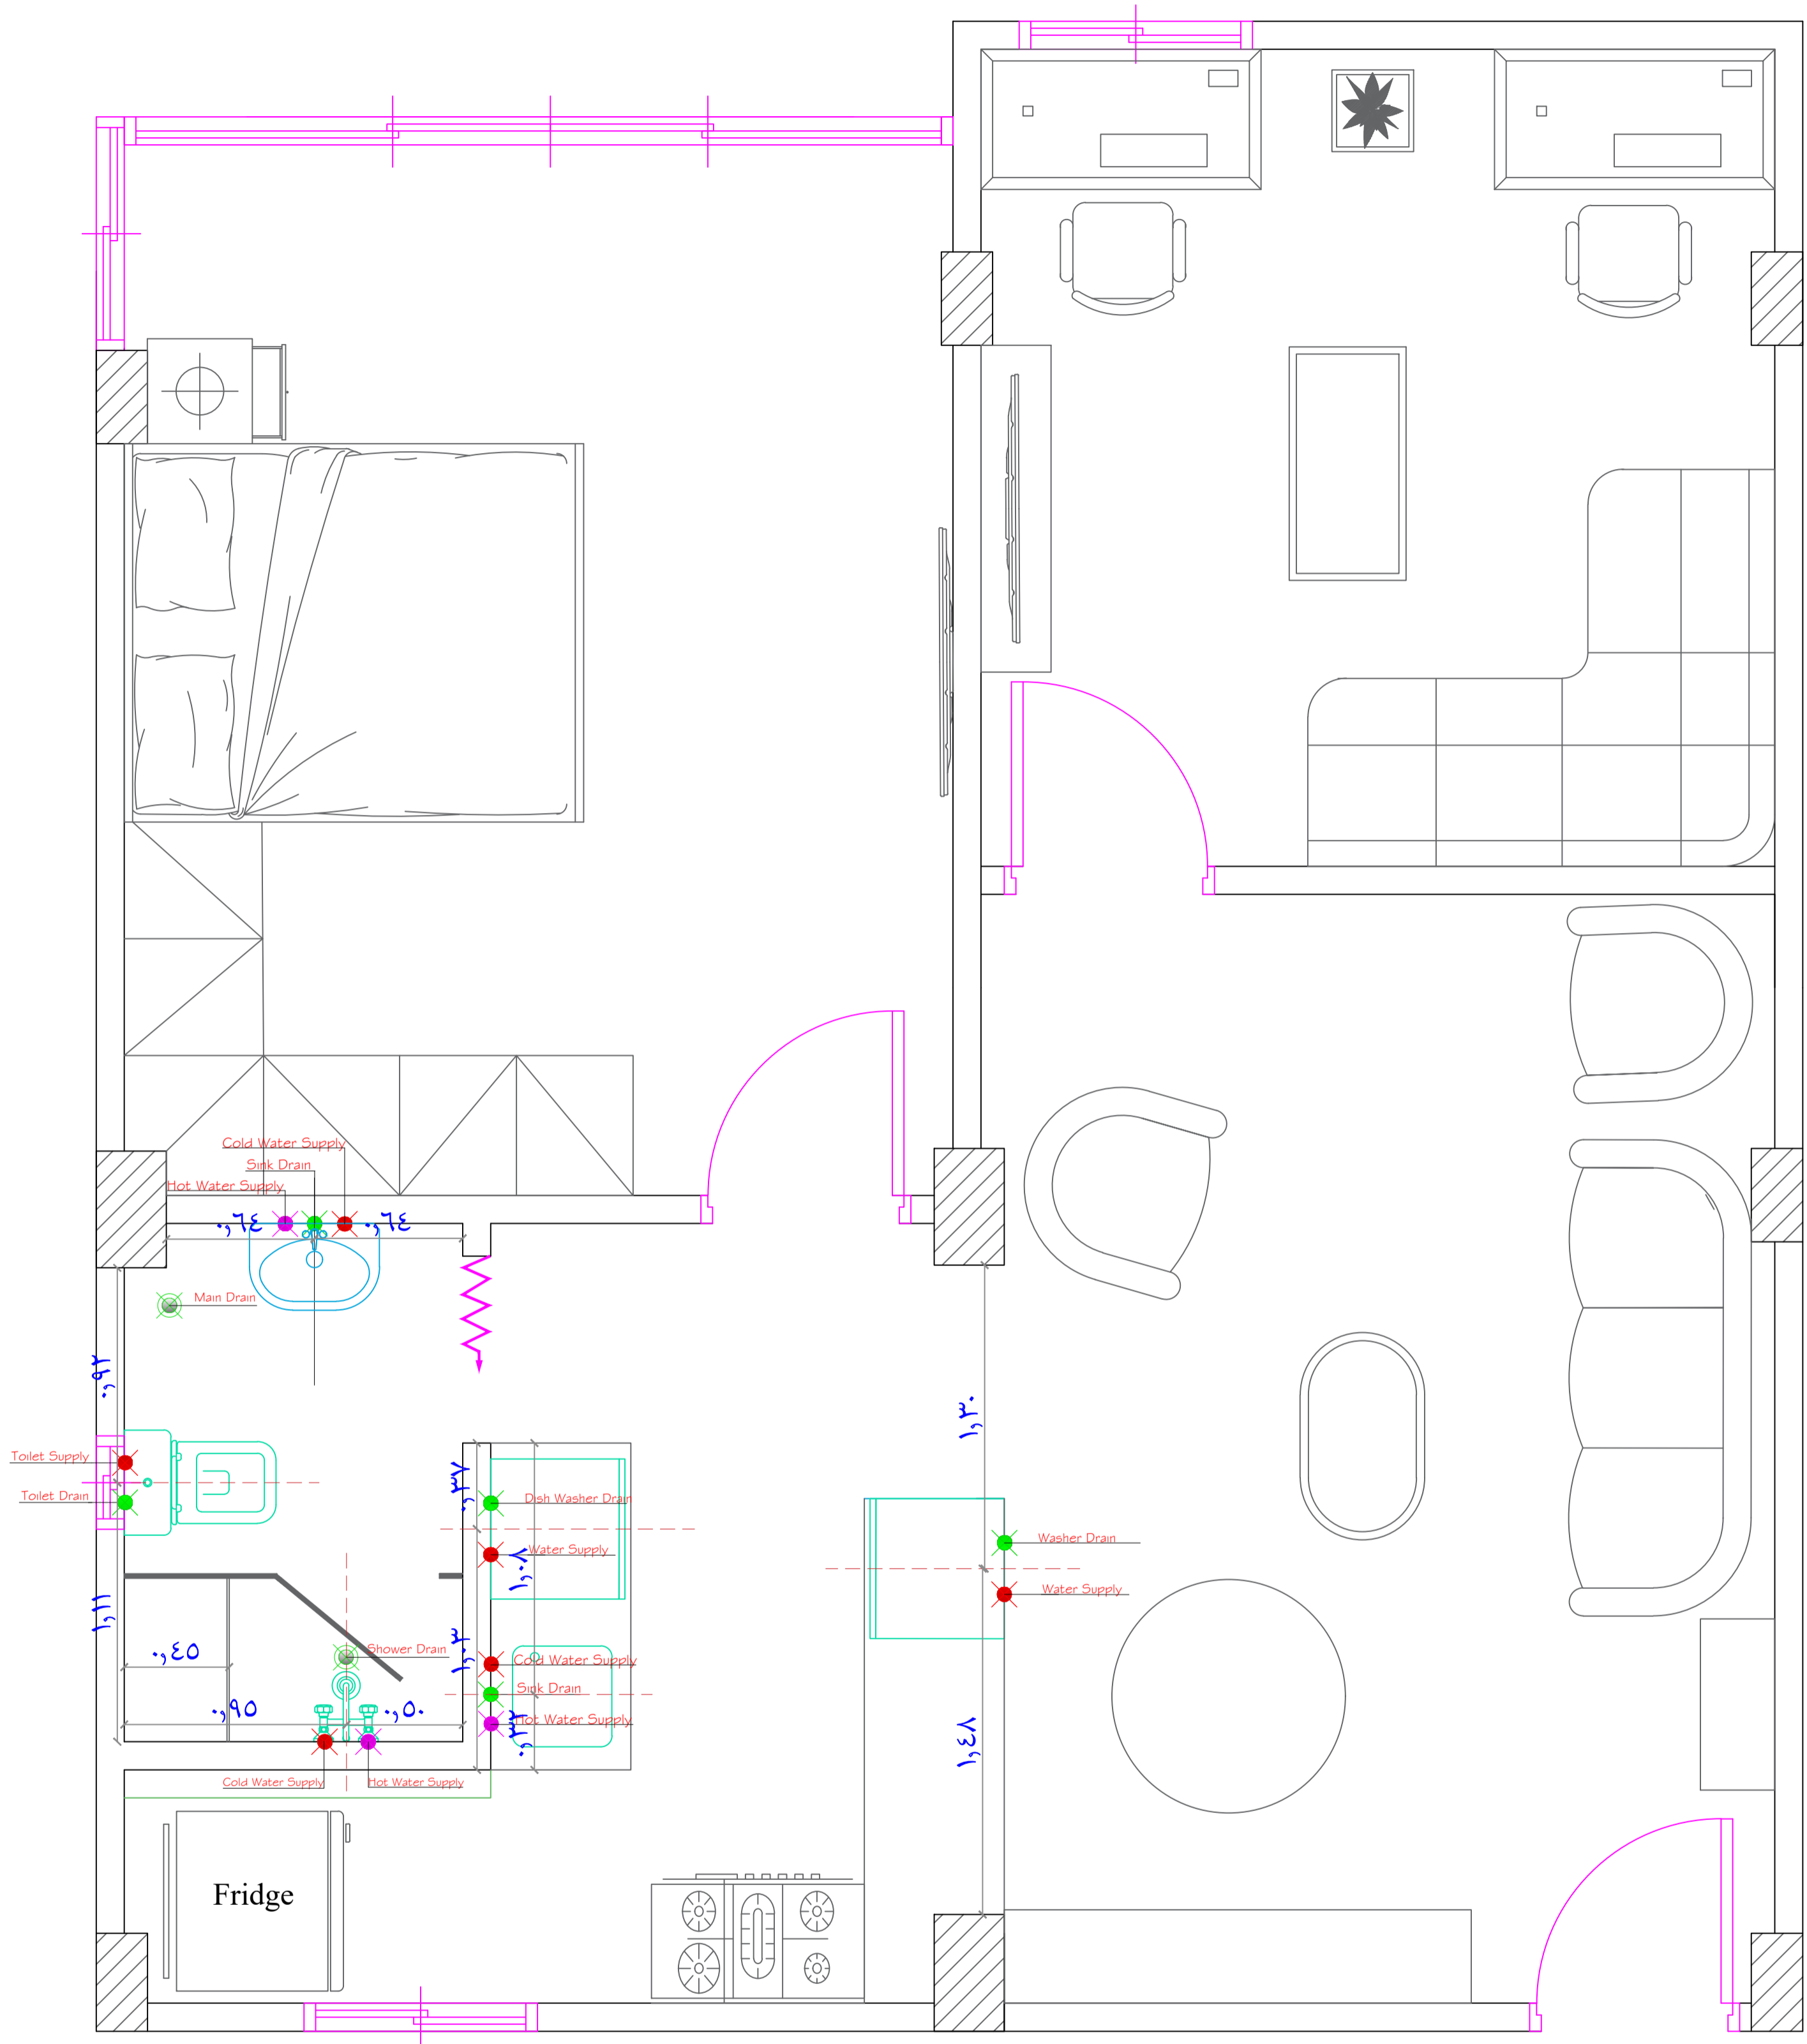

ADDRESS:

CLIENT NAME:

Abdallah Taher

TELEPHONE #:
(+20)1010081423

PROJECT NAME:

DRAWINGS TITLE:

Sheet Size: A3

Rev : 0

DRAWN BY:

Ahmed Hesham
TELEPHONE #:
(+20)1116030118

SCALE:

APPROVED BY:

Hesham Zayed
TELEPHONE #:
(+20)102032244

DATE: 1-9-2024

DESCRIPTION:

Plumbing plan