


Un	[V]	22000
Ik LLL	[kA]	
P	[kW]	
Q	[kvar]	

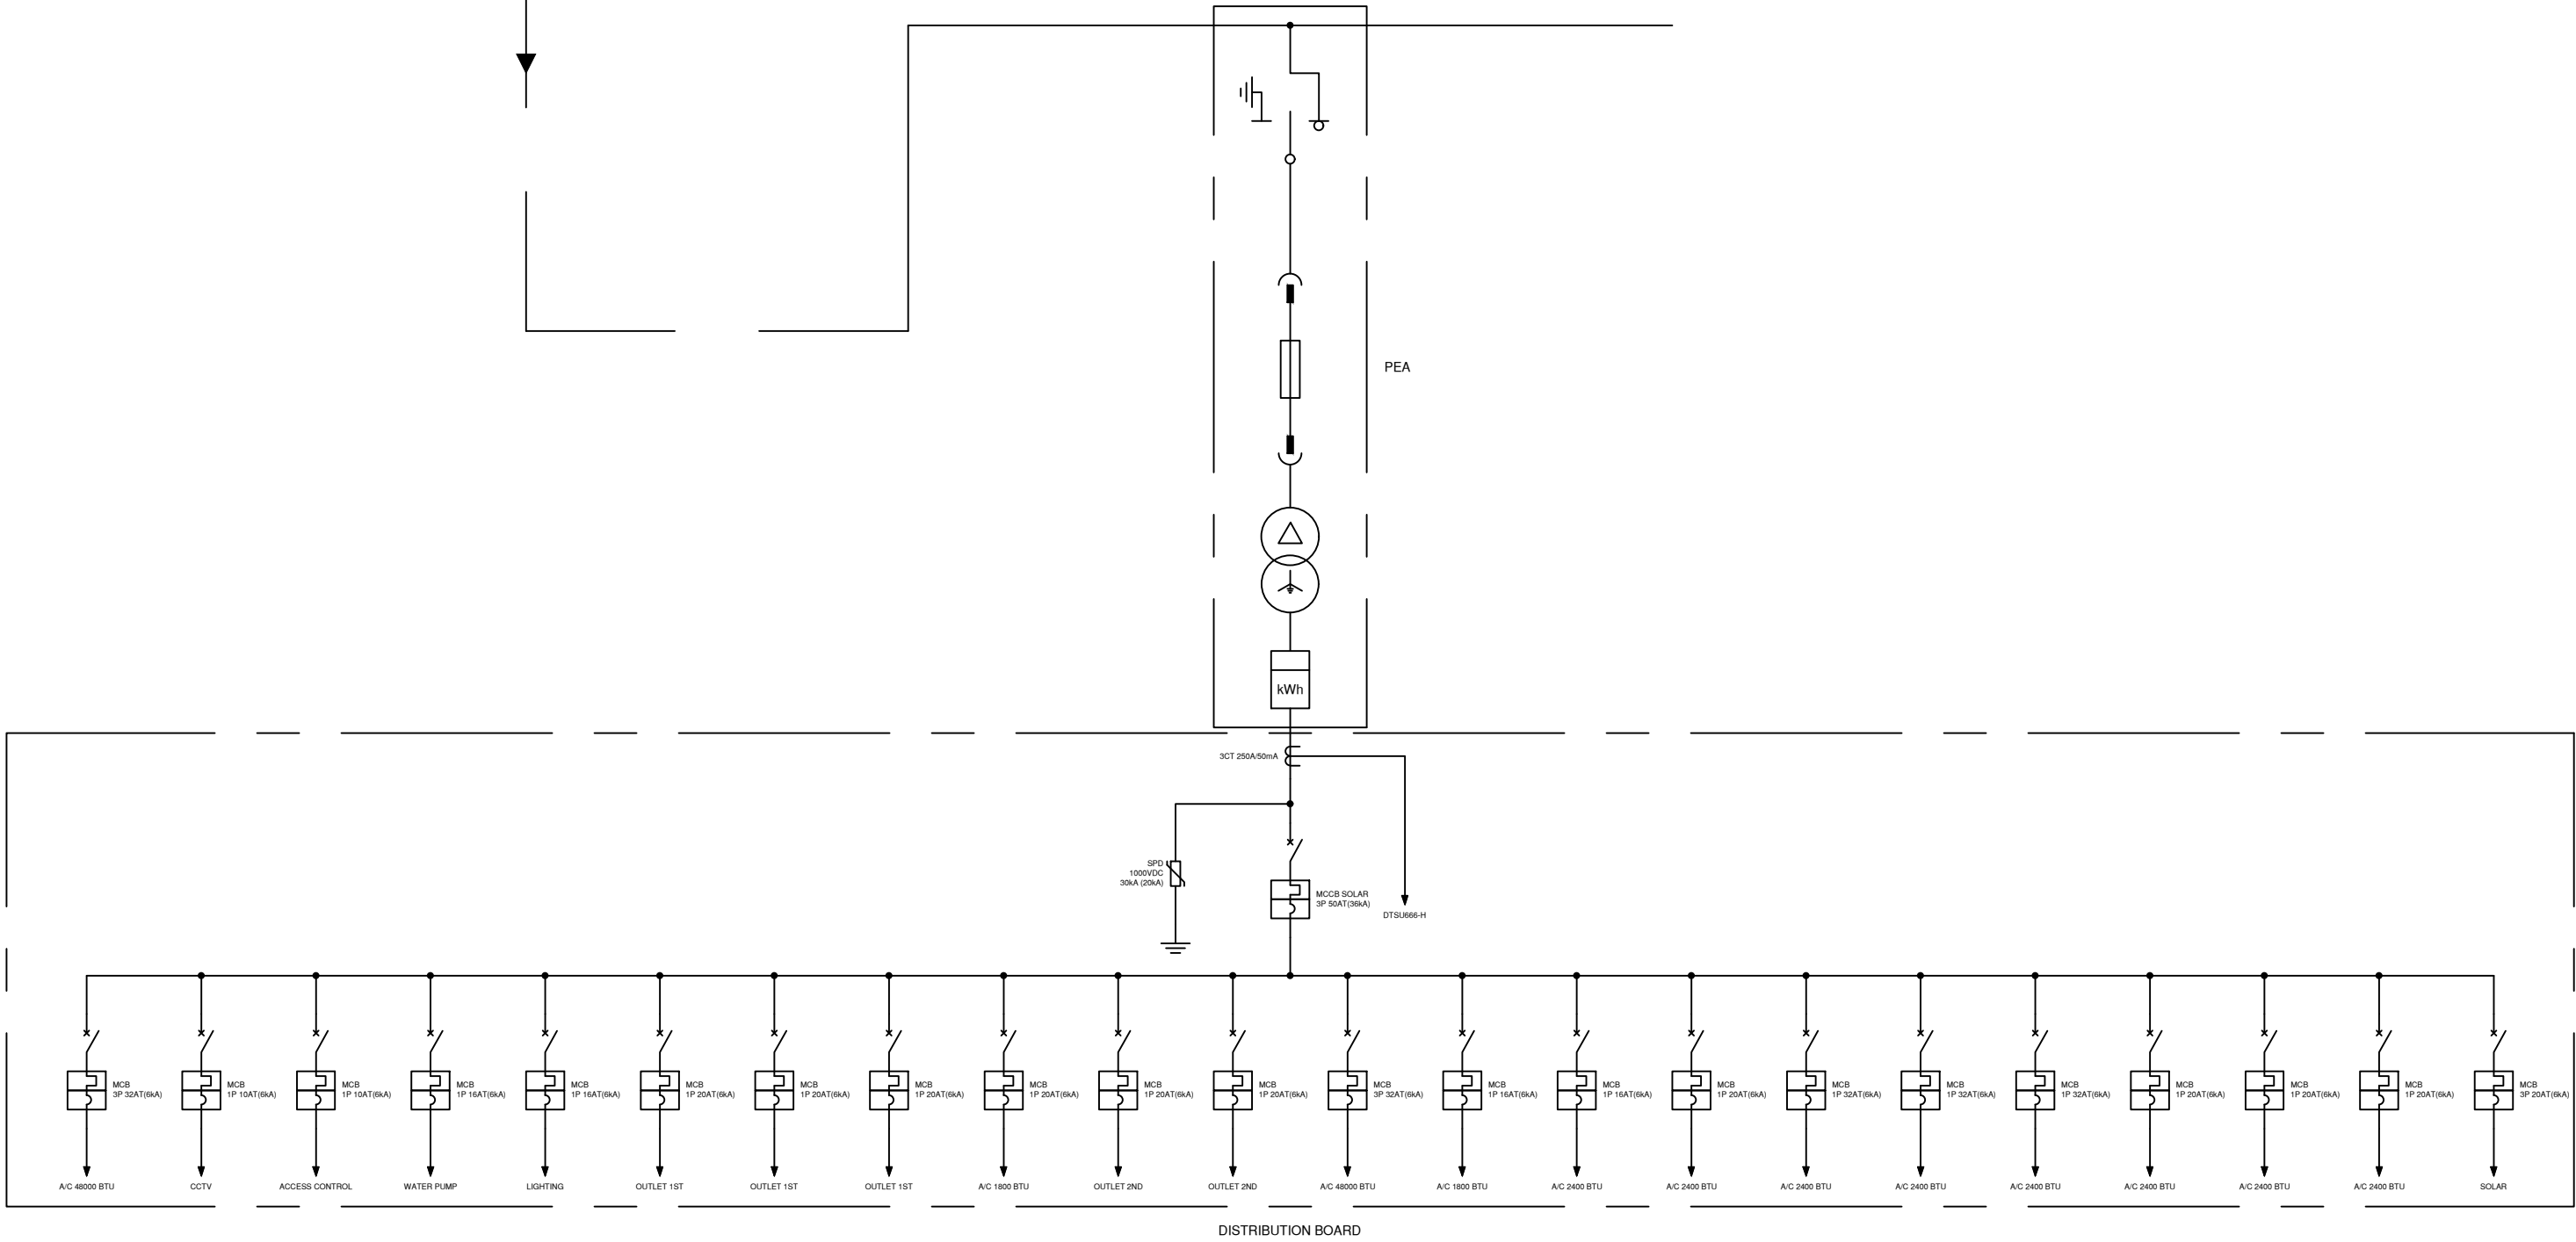

PROJECT NAME	PROLOGIC LIMITED	DRAWN BY	B.SITTAWEЕ, P.YANNAPHAT
DRAWING NAME	SINGLE LINE DIAGRAM -SOLAR CELLS	DATE	
		SCALE	
		DRAWING NO.	