



UTILITY SERVICE
600V, 3Φ, 4W, 60Hz
Assumed 50kA AFC

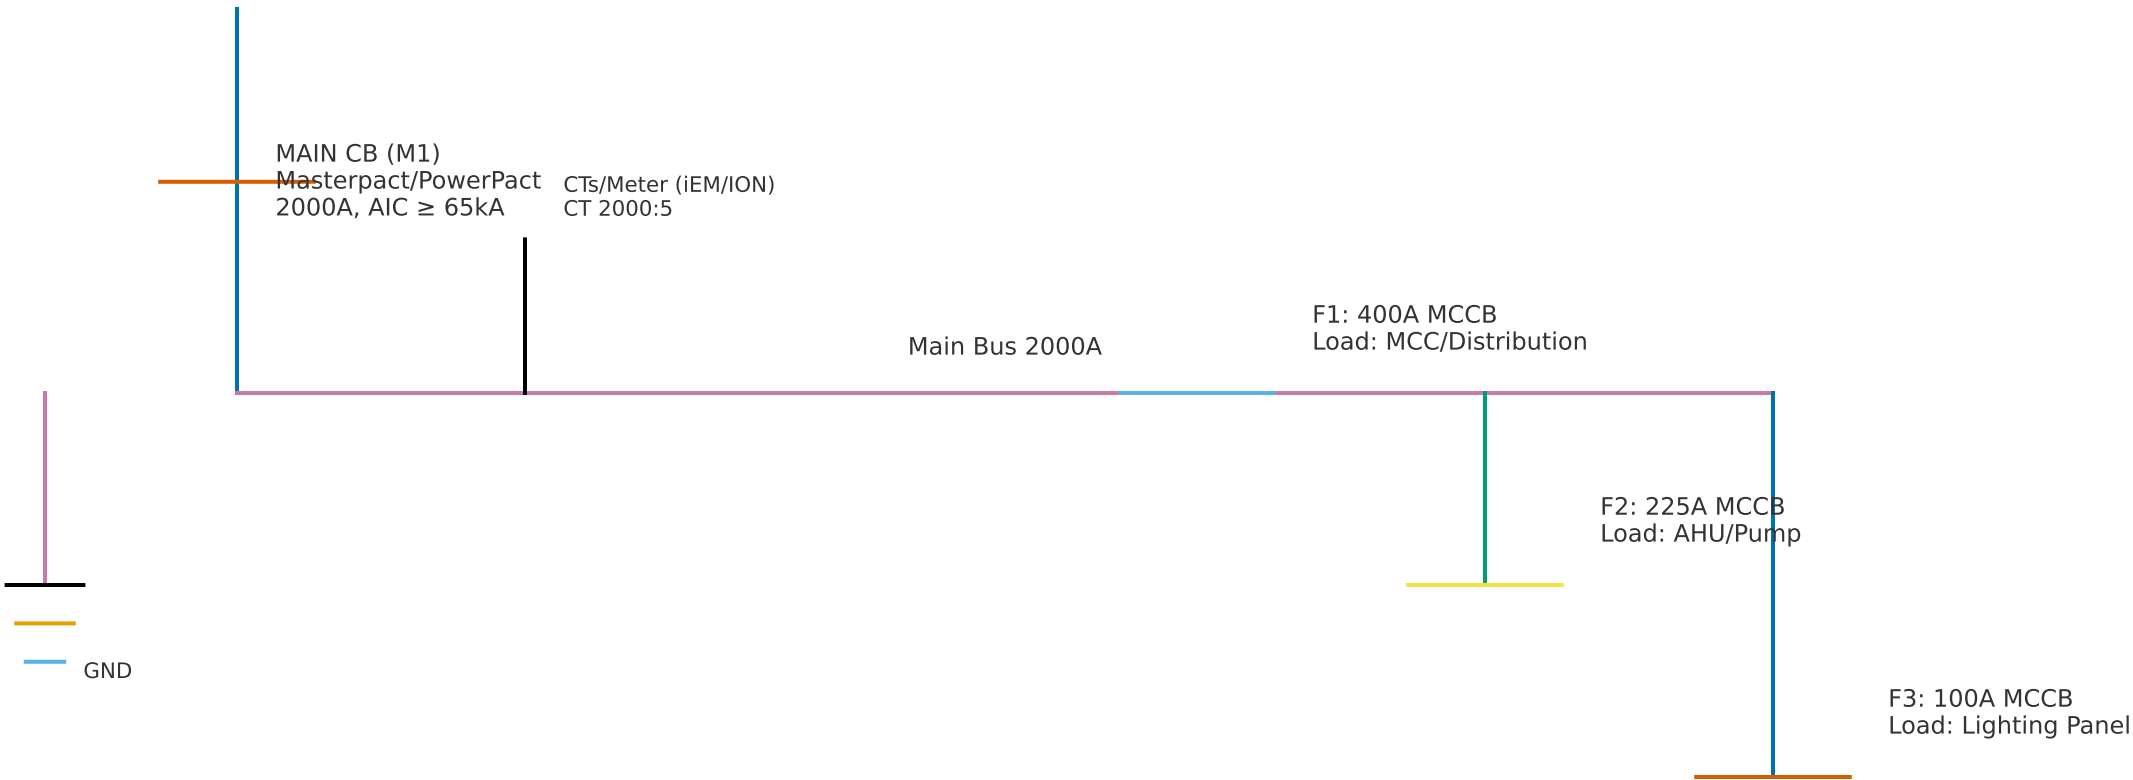

TITLE		SINGLE-LINE DIAGRAM (SLD)	
DWG NO: SLD-001	REV: A	BY: O. W. Ofuzim	
SHEET: A3 11x17	DATE: 2025-11-11	FOR APPROVAL	

H ≈ 2200 mm

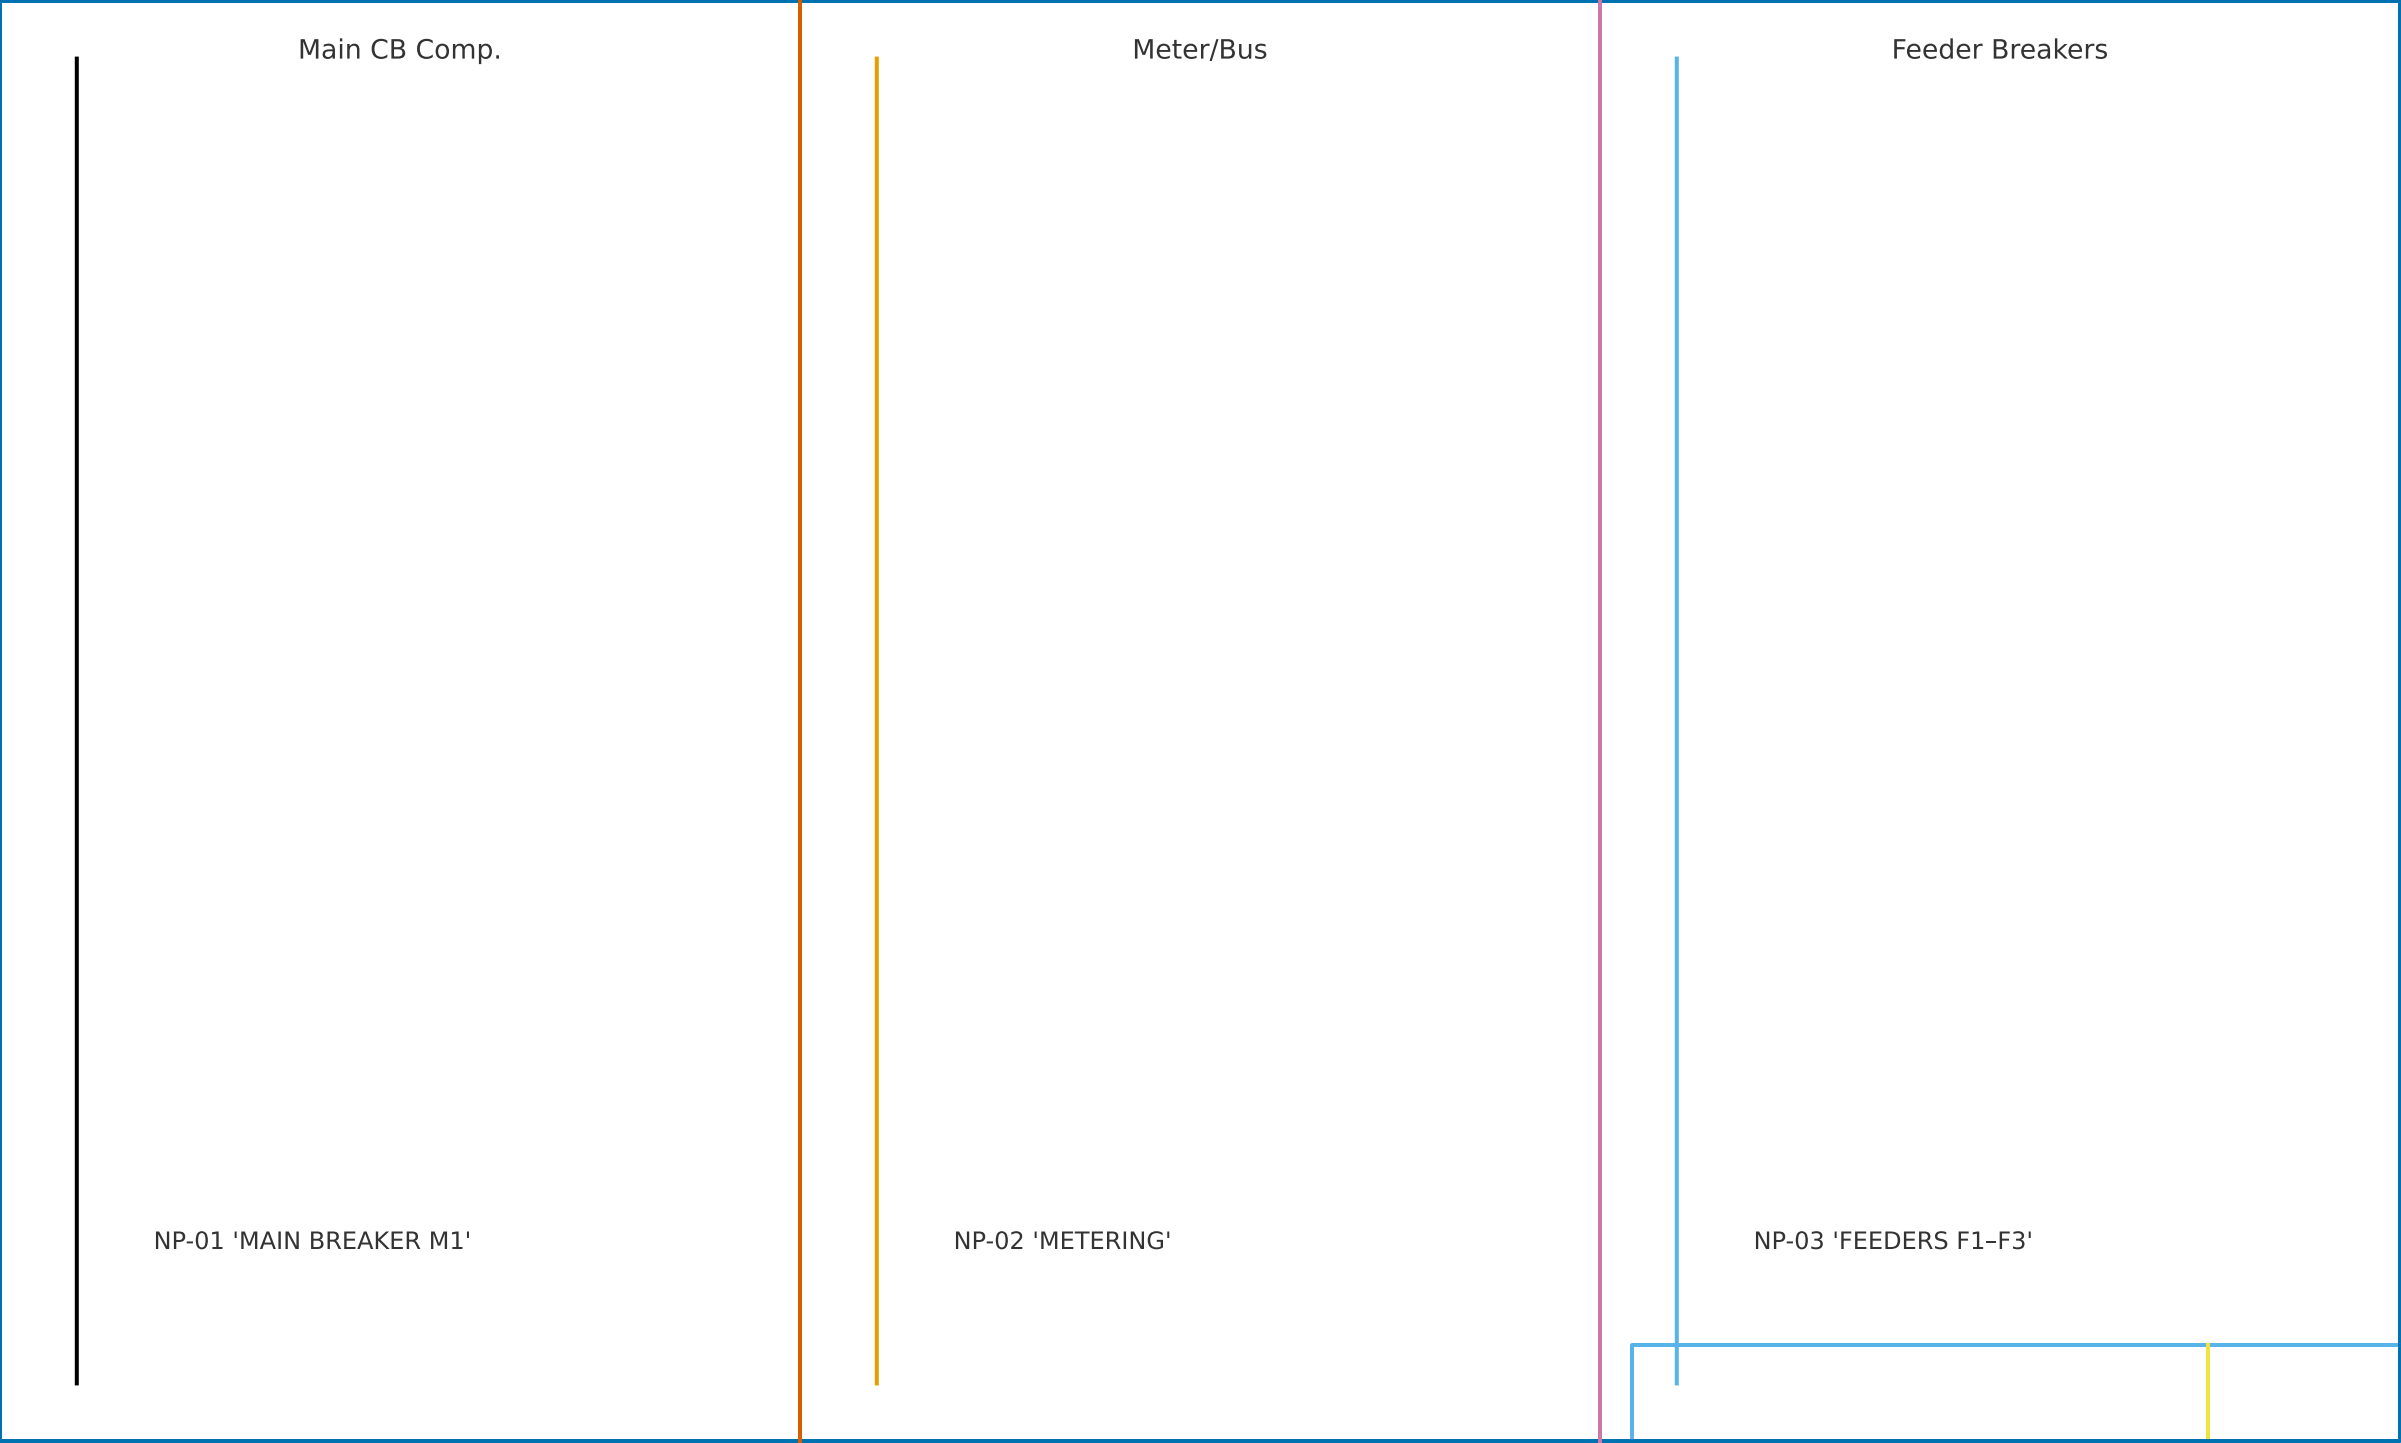

W ≈ 2500 mm

TITLE		SWITCHBOARD FRONT ELEVATION	
DWG NO: ELEV-001		REV: A	BY: O. W. Ofuzim
SHEET: A3 11x17		DATE: 2025-11-11	FOR APPROVAL

L1

N

STOP PB (NC)

START PB (NO)

OL NC

K1 COIL (F2)

M1 AUX (NO)

PL 'RUN'

TB1: 1-2-3-4 ...

TITLE		FEEDER CONTROL SCHEMATIC (F2)
DWG NO: SCH-101	REV: A	BY: O. W. Ofuzim
SHEET: A3 11x17	DATE: 2025-11-11	FOR APPROVAL