


UTILITY SERVICE  
600V, 3Φ, 4W, 60Hz  
Assumed 50kA AFC

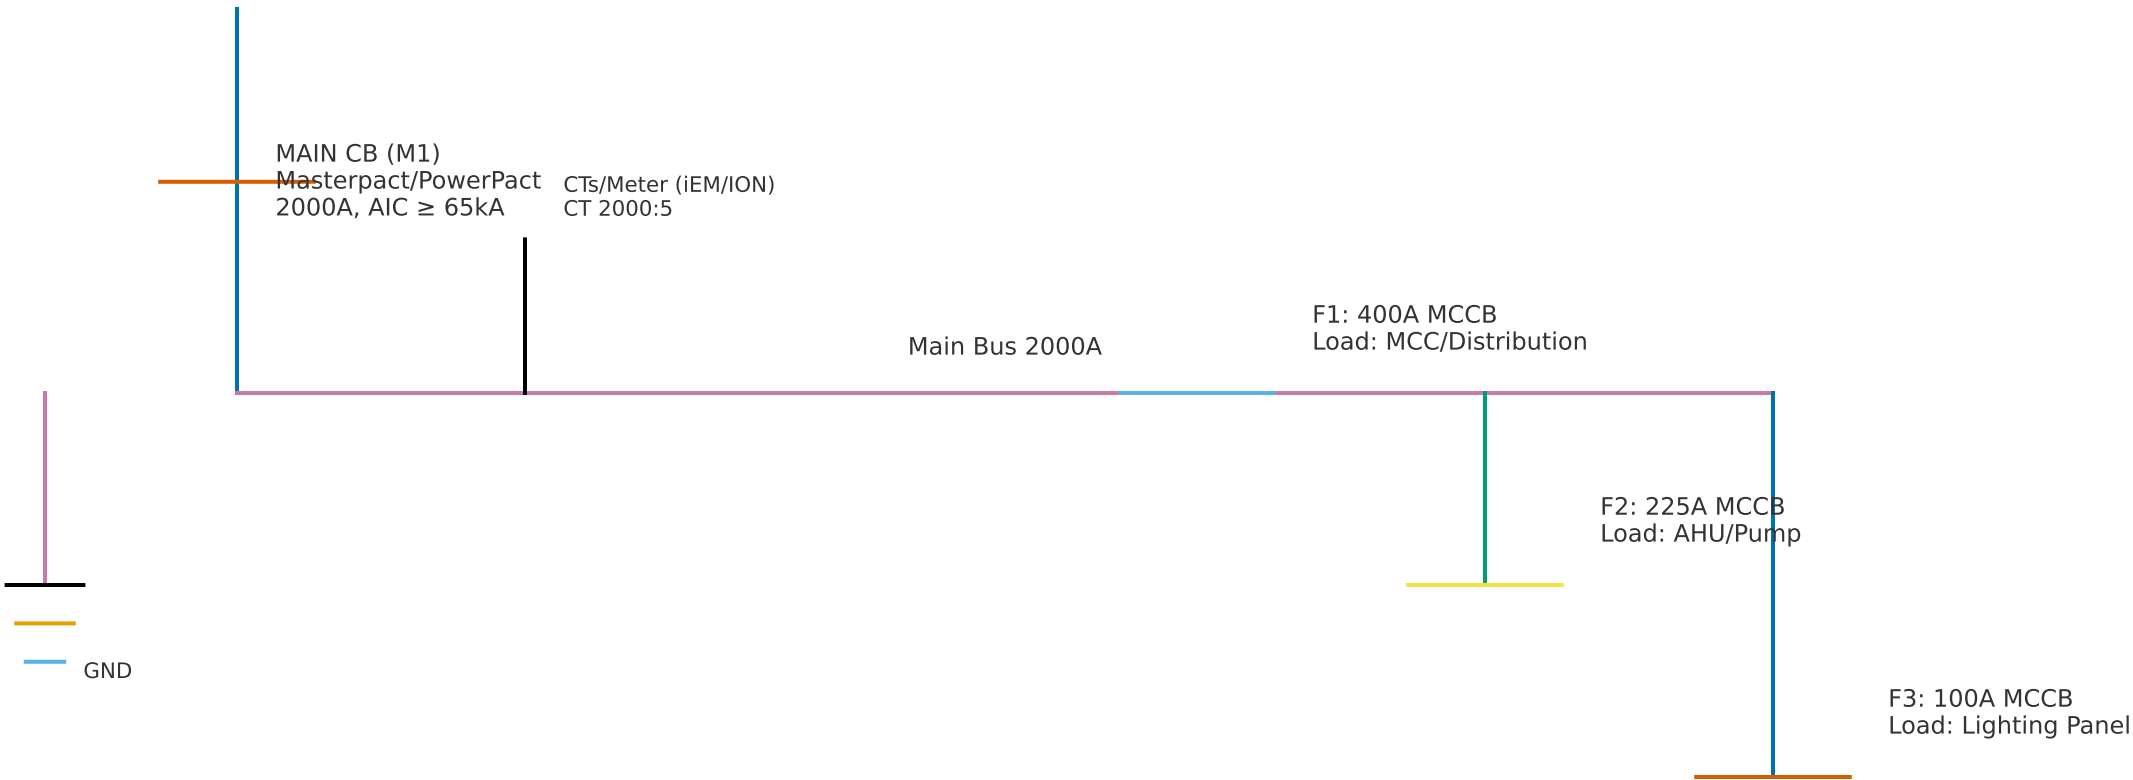

TITLE		SINGLE-LINE DIAGRAM (SLD)	
DWG NO: SLD-001	REV: A	BY: O. W. Ofuzim	
SHEET: A3 11x17	DATE: 2025-11-11	FOR APPROVAL	