



A Custom Home For

The Gant Family

Burkett Road, Boone NC

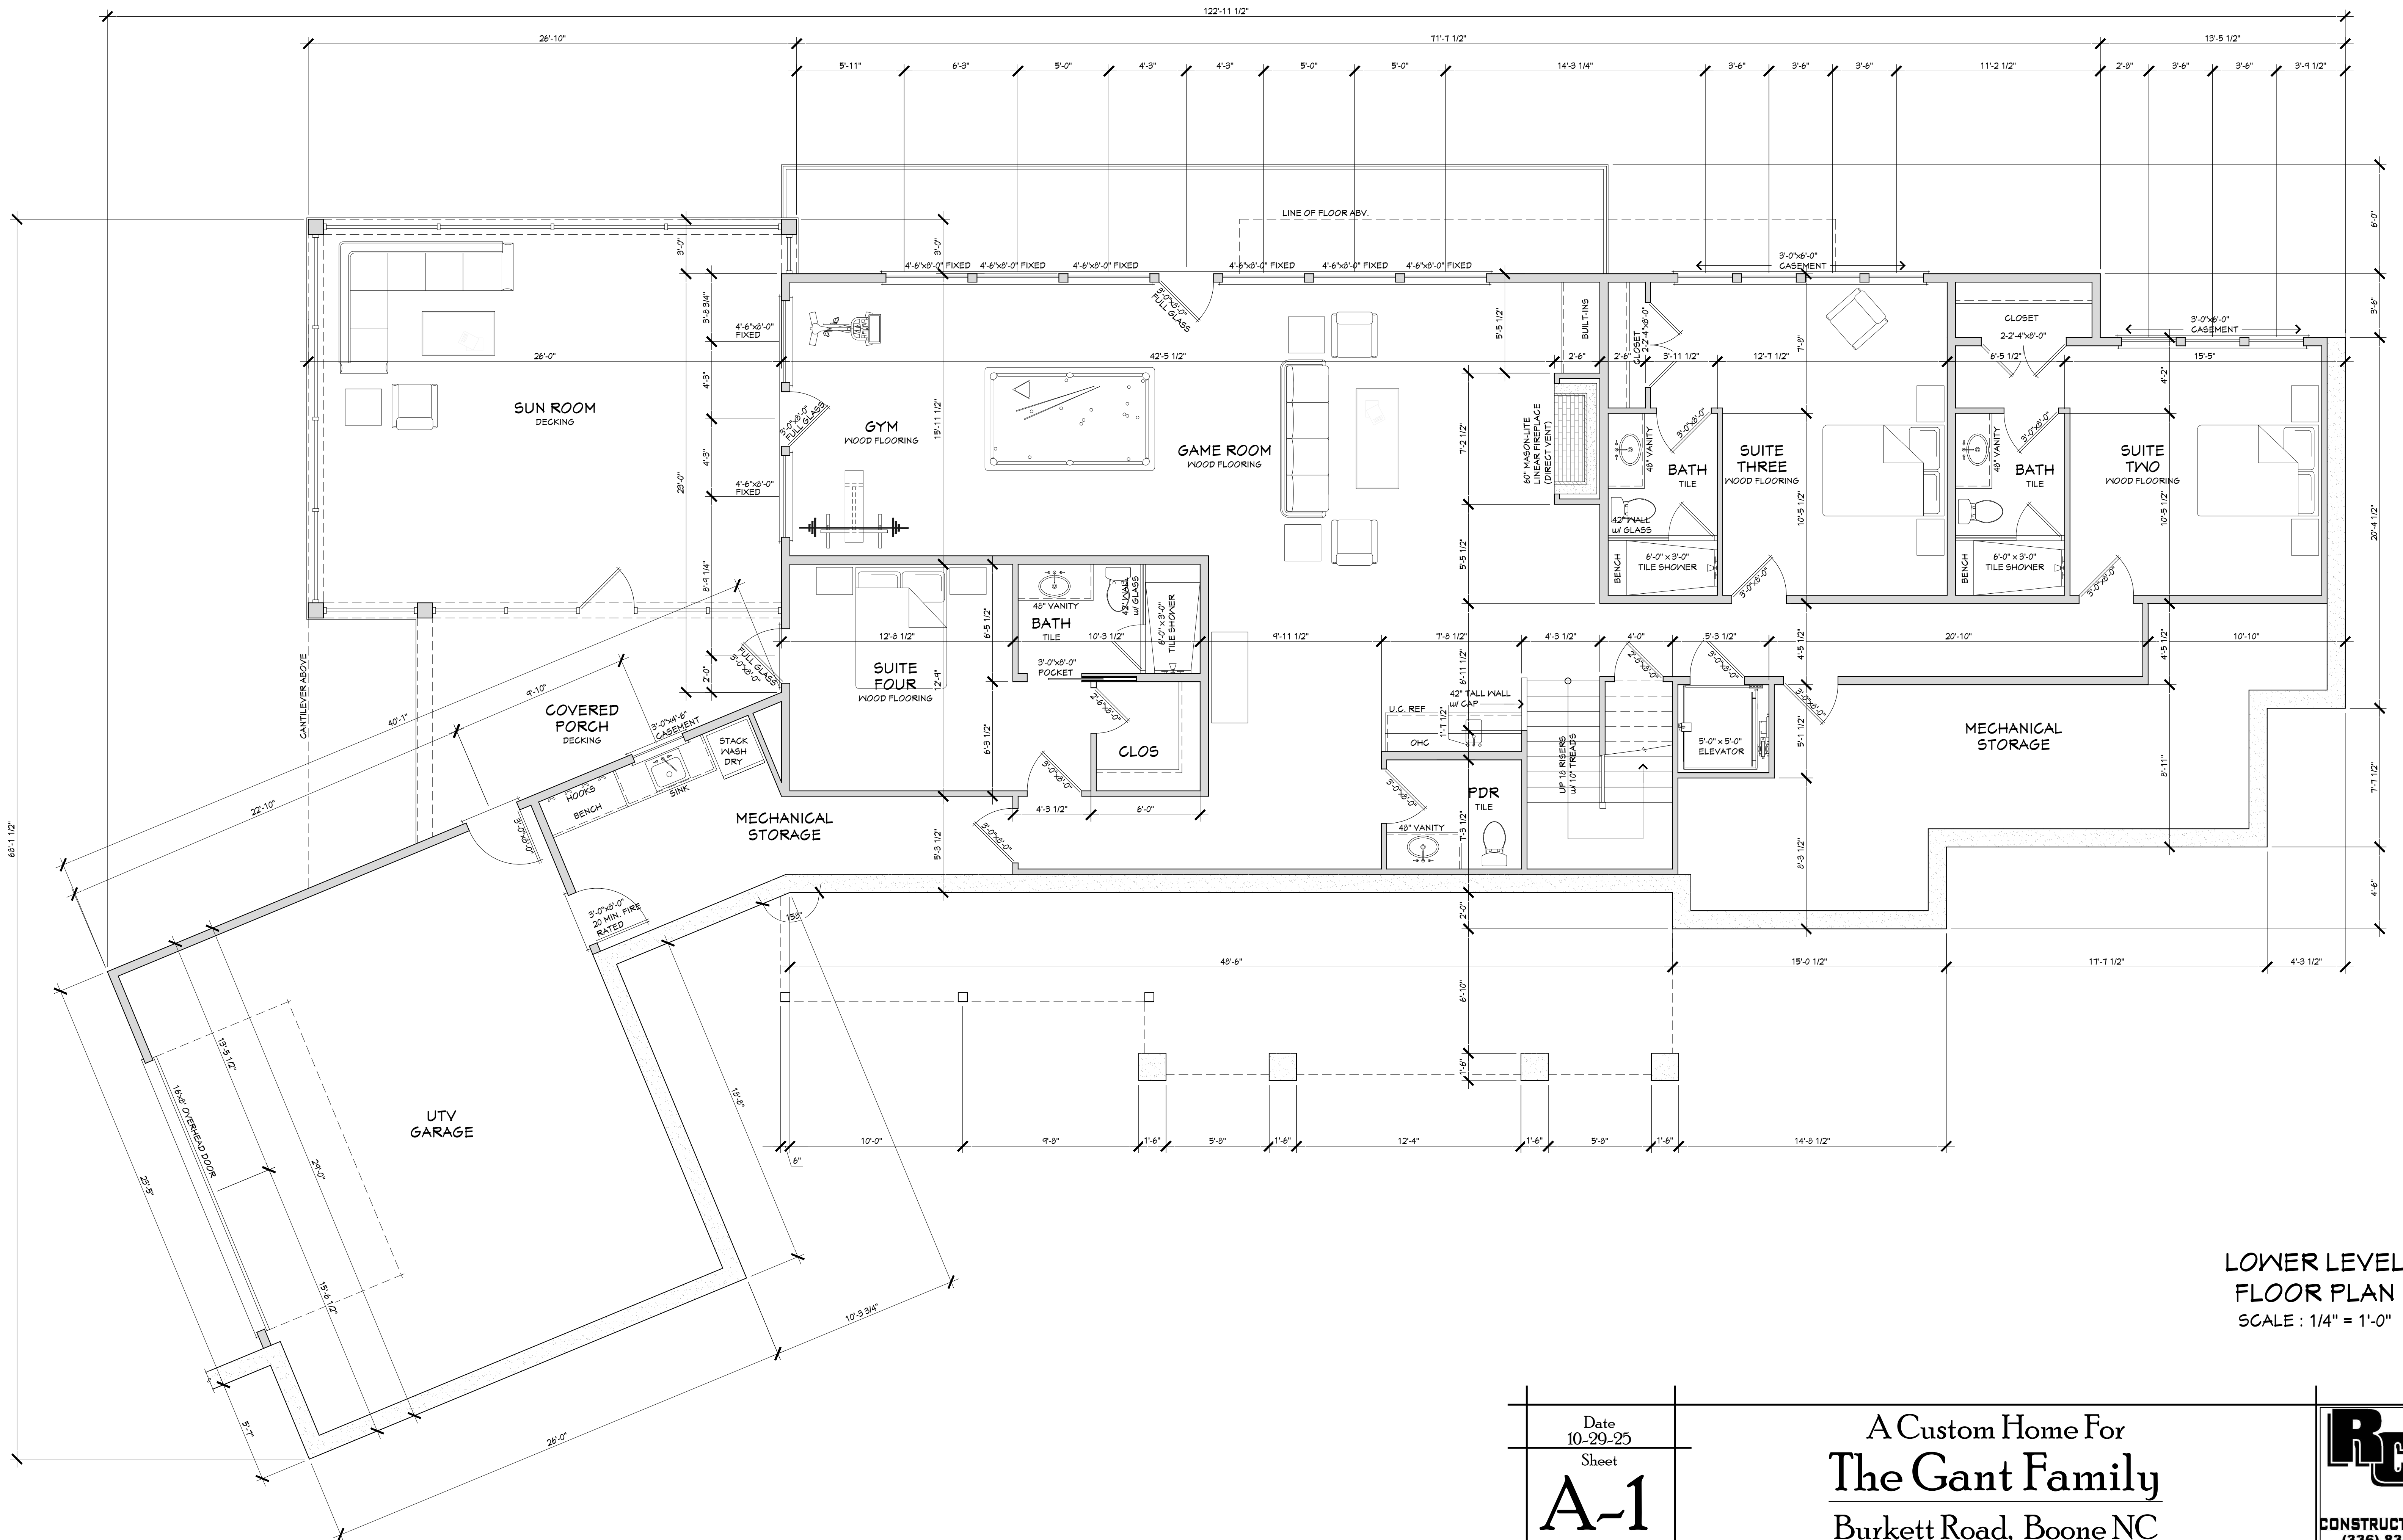

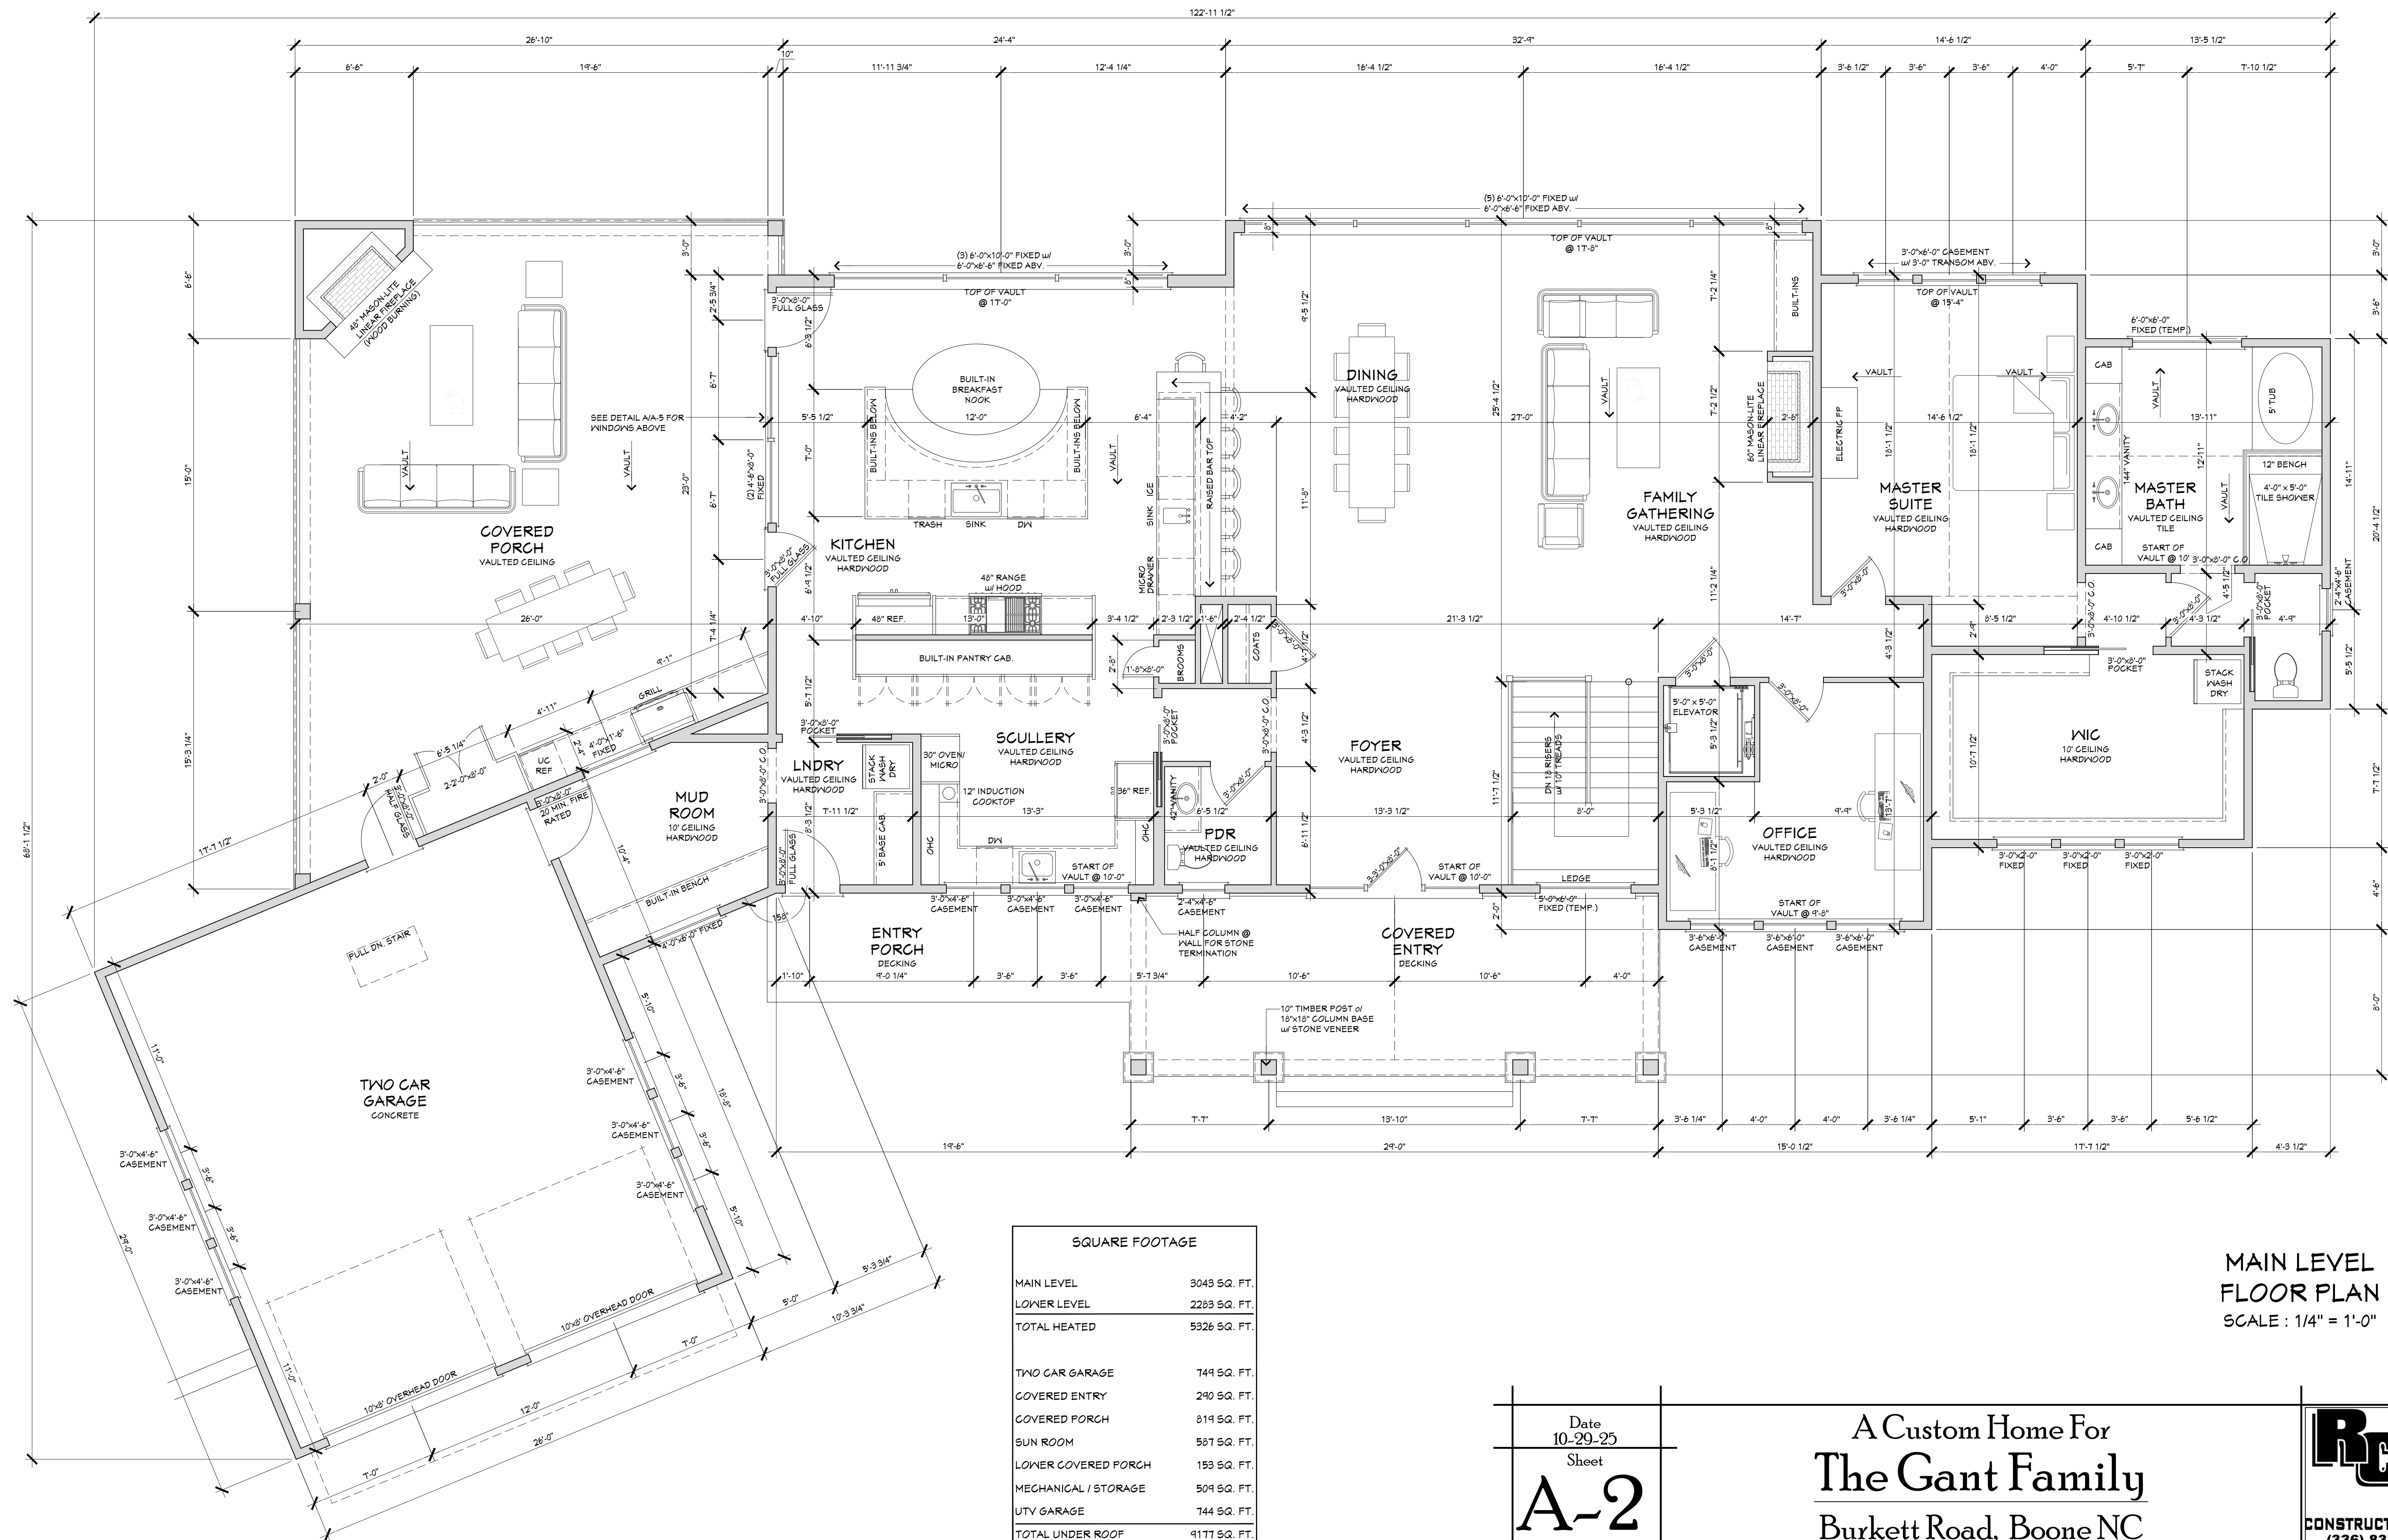

**MAIN LEVEL
FLOOR PLAN**
SCALE : 1/4" = 1'-0"

Date
10-29-25
Sheet

A-2


A Custom Home For
The Gant Family
Burkett Road, Boone NC

RCO
CONSTRUCTION, INC.
(336) 838-6701






SCALE : 1/4" = 1'-0"


| | | |
|---|--|---|
| <p>Date 10-29-25</p> <p>Sheet</p> <p>A-3</p> | <p>A Custom Home For</p> <p>The Gant Family</p> <p>Burkett Road, Boone NC</p> |  <p>RCO CONSTRUCTION, INC. (336) 838-6701</p> |
|---|--|---|

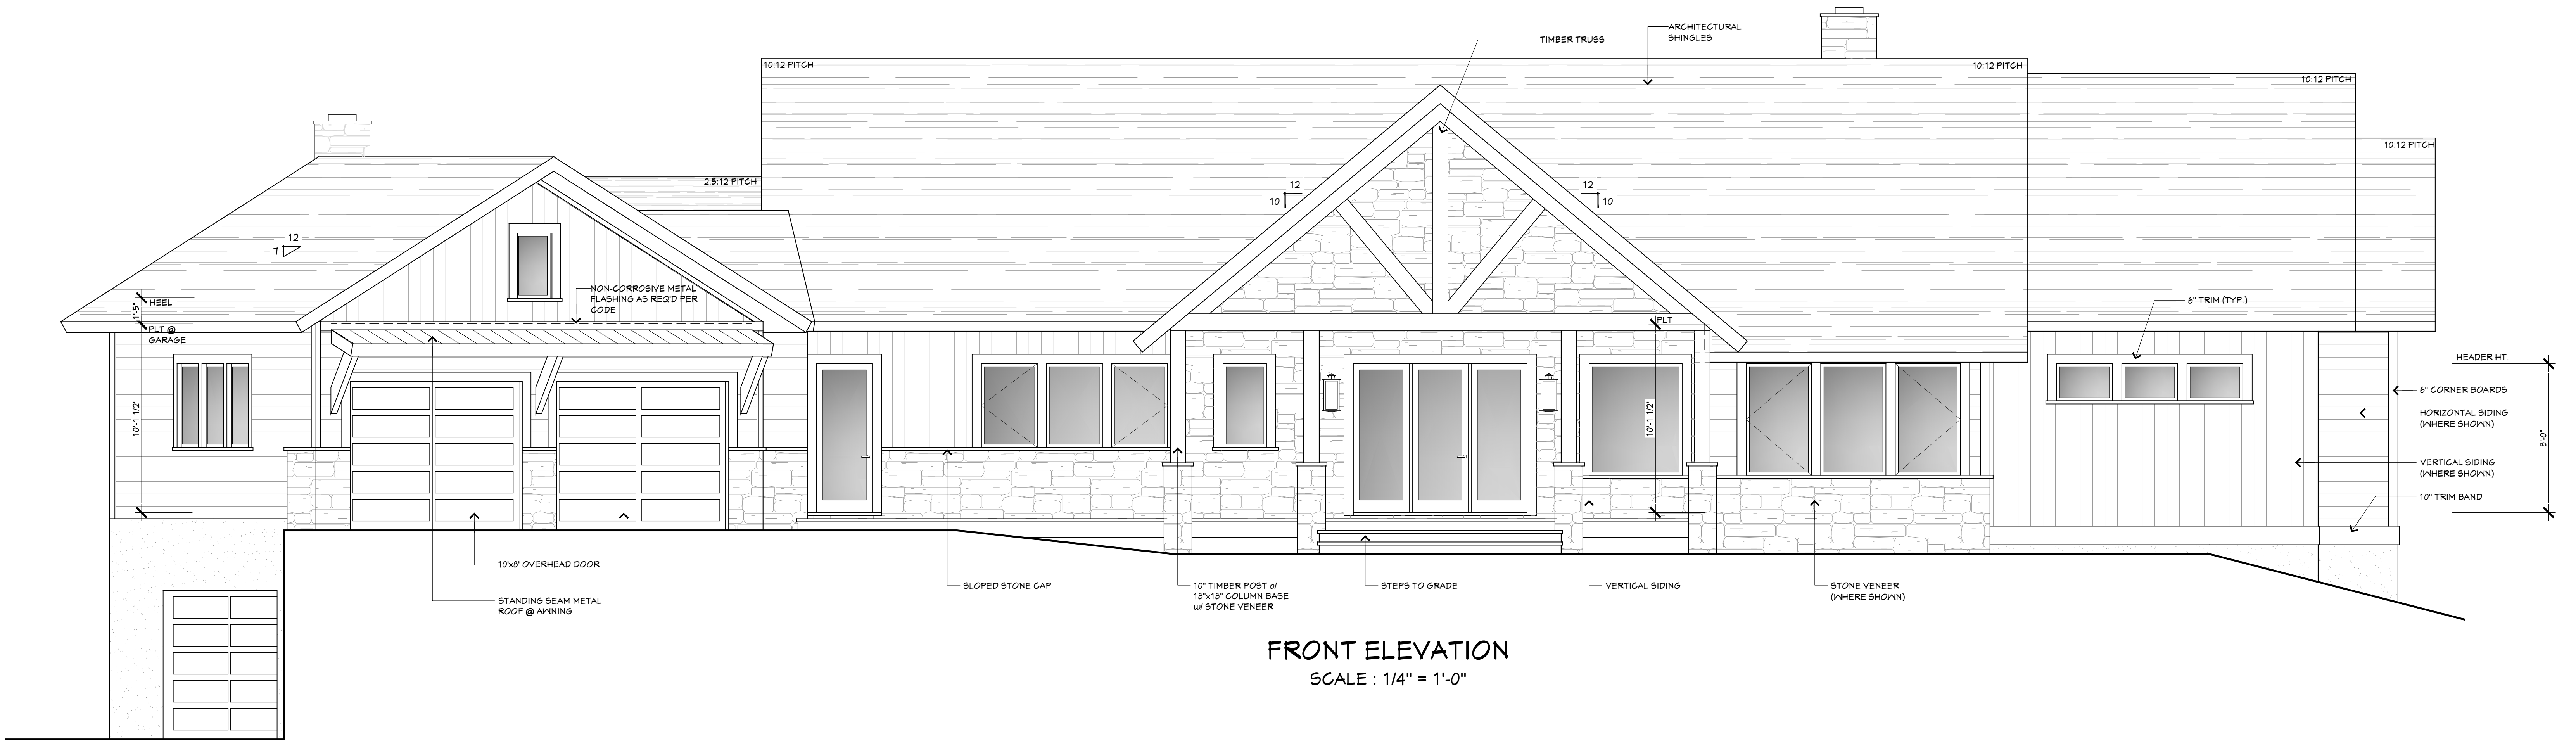


| | | |
|---|---|---|
| Date 10-29-25 Sheet A-4 | A Custom Home For The Gant Family Burkett Road, Boone NC |  CONSTRUCTION, INC. (336) 838-6701 |
|---|---|---|

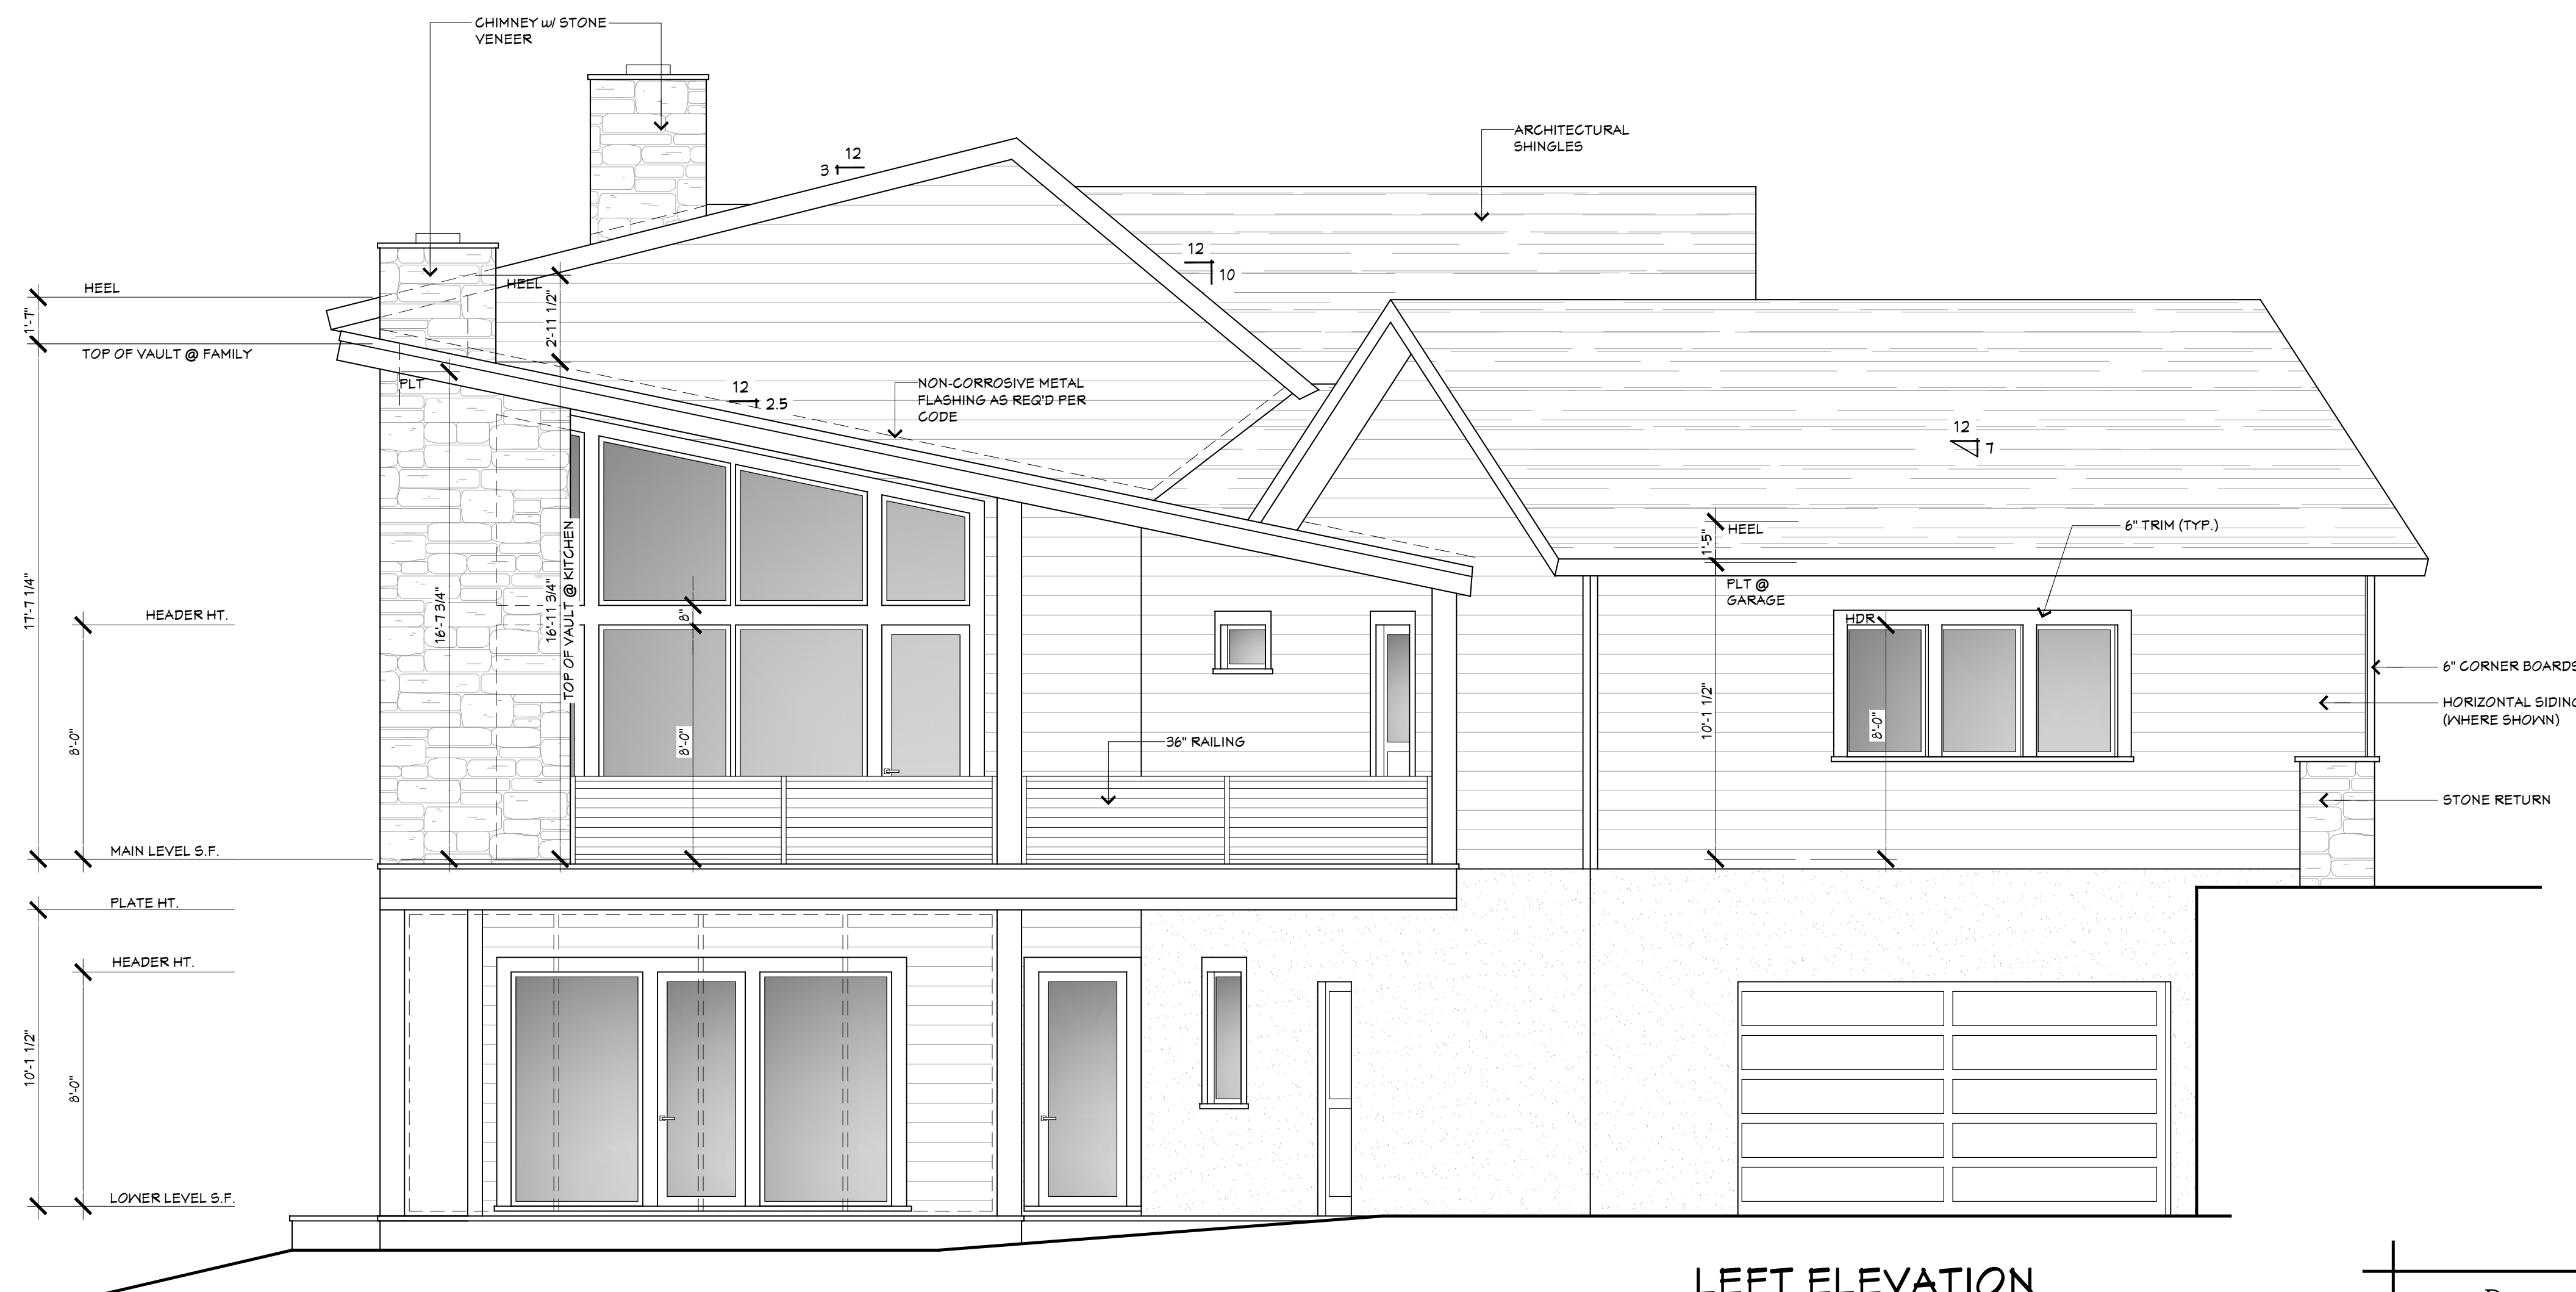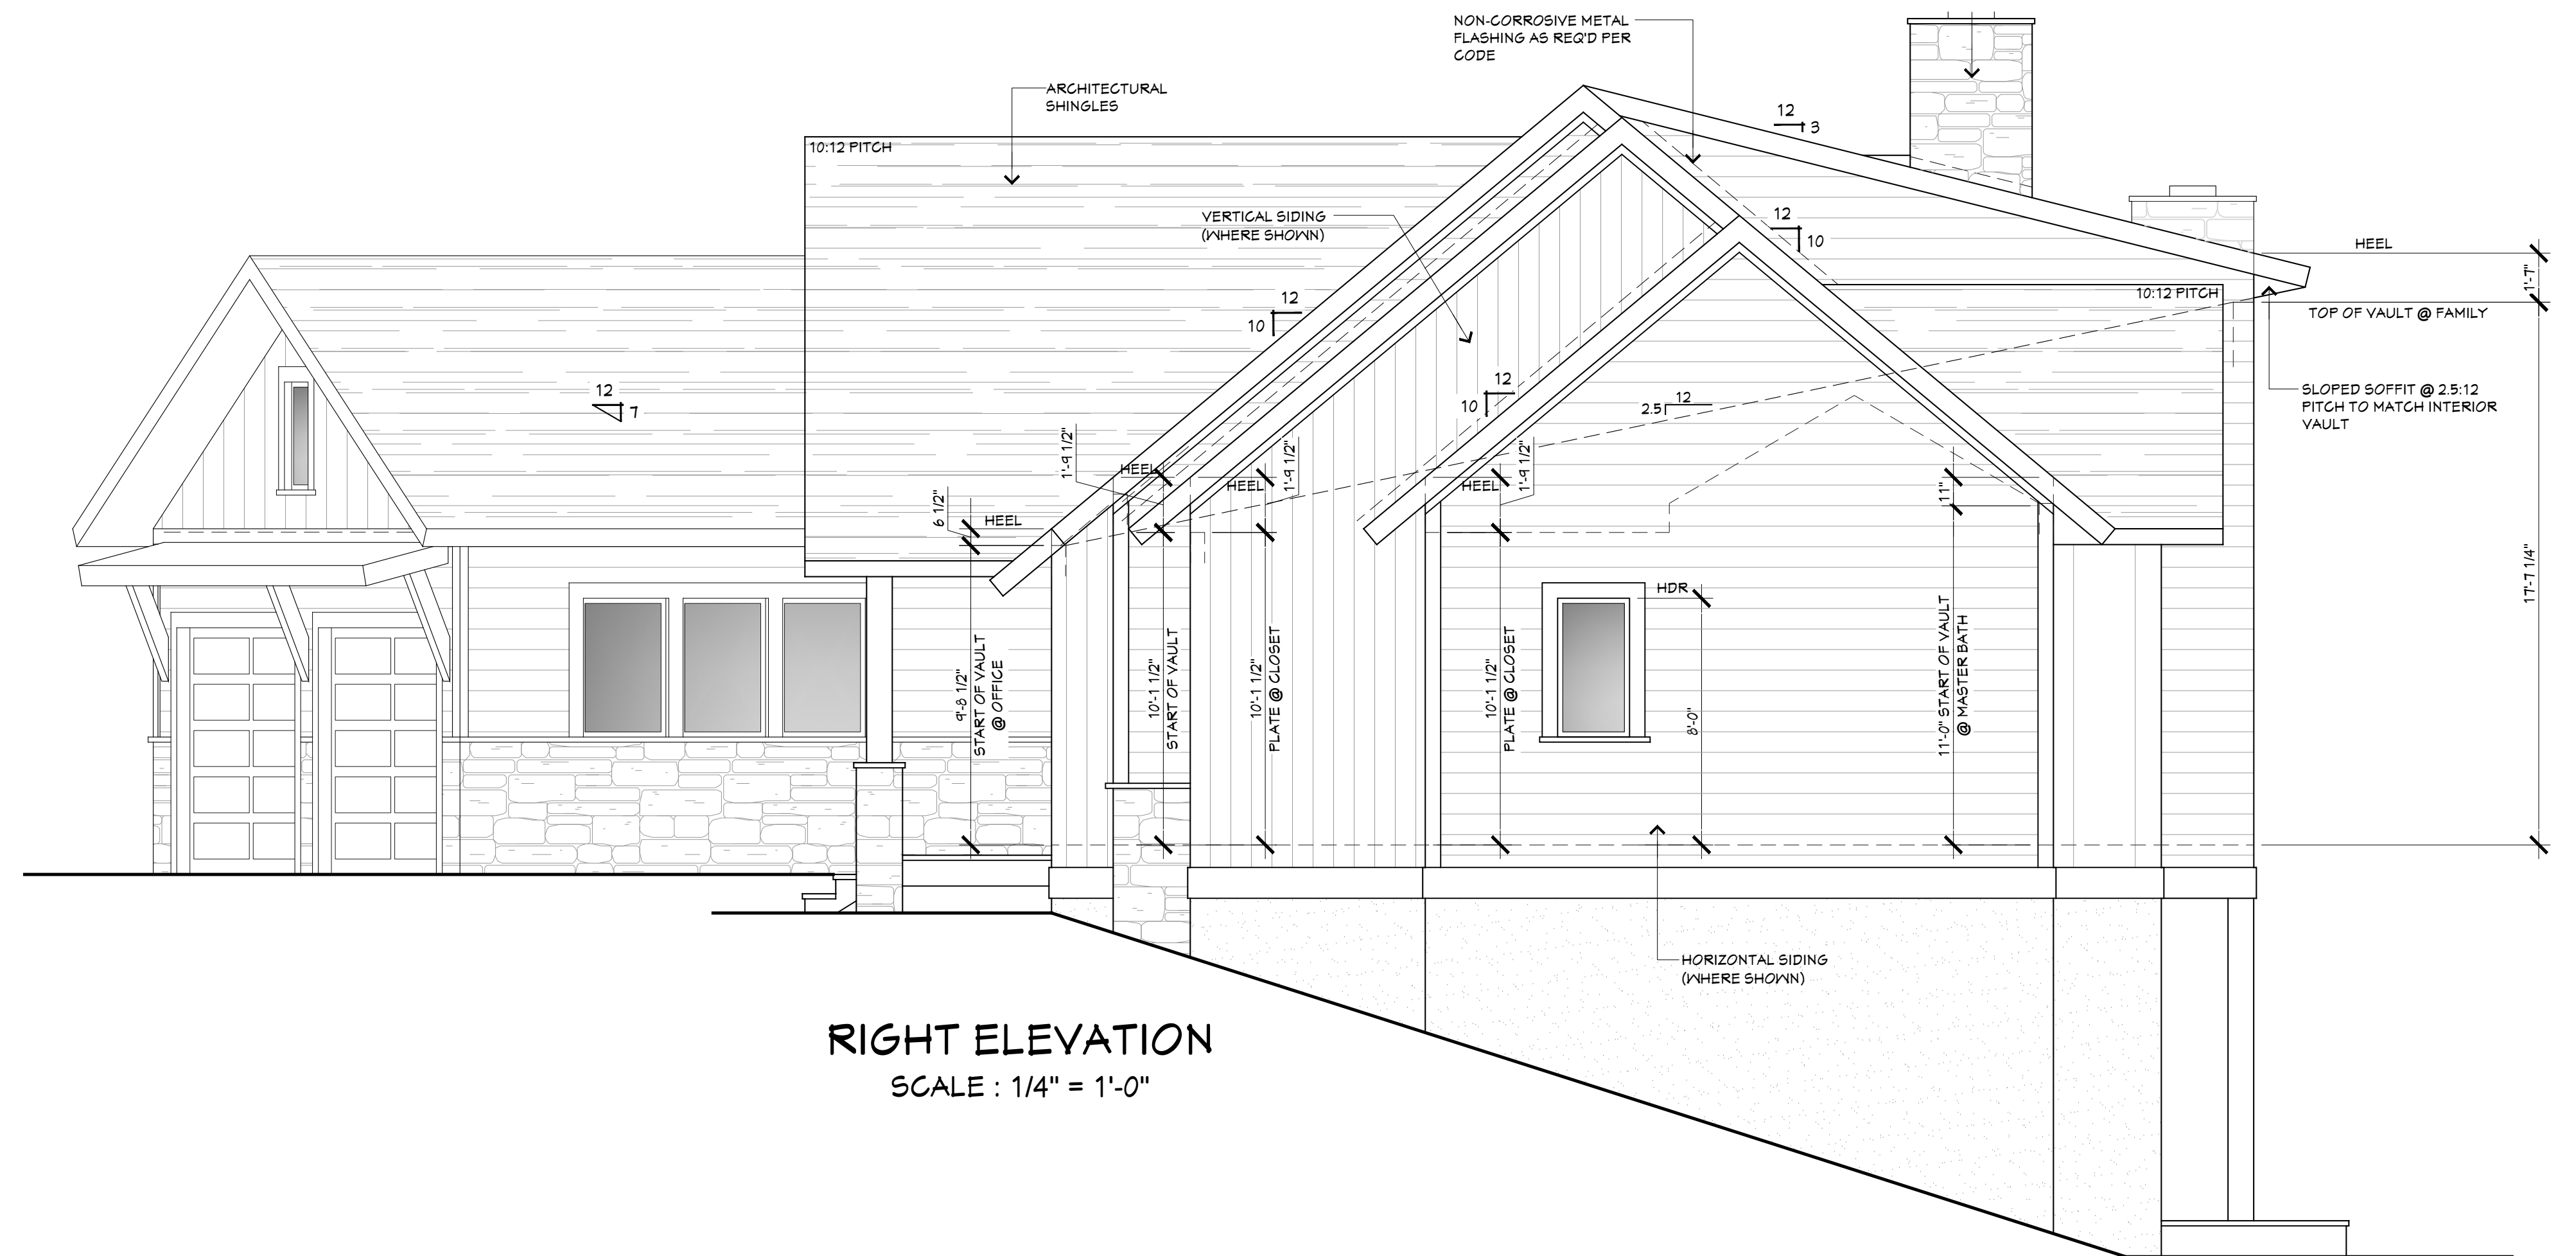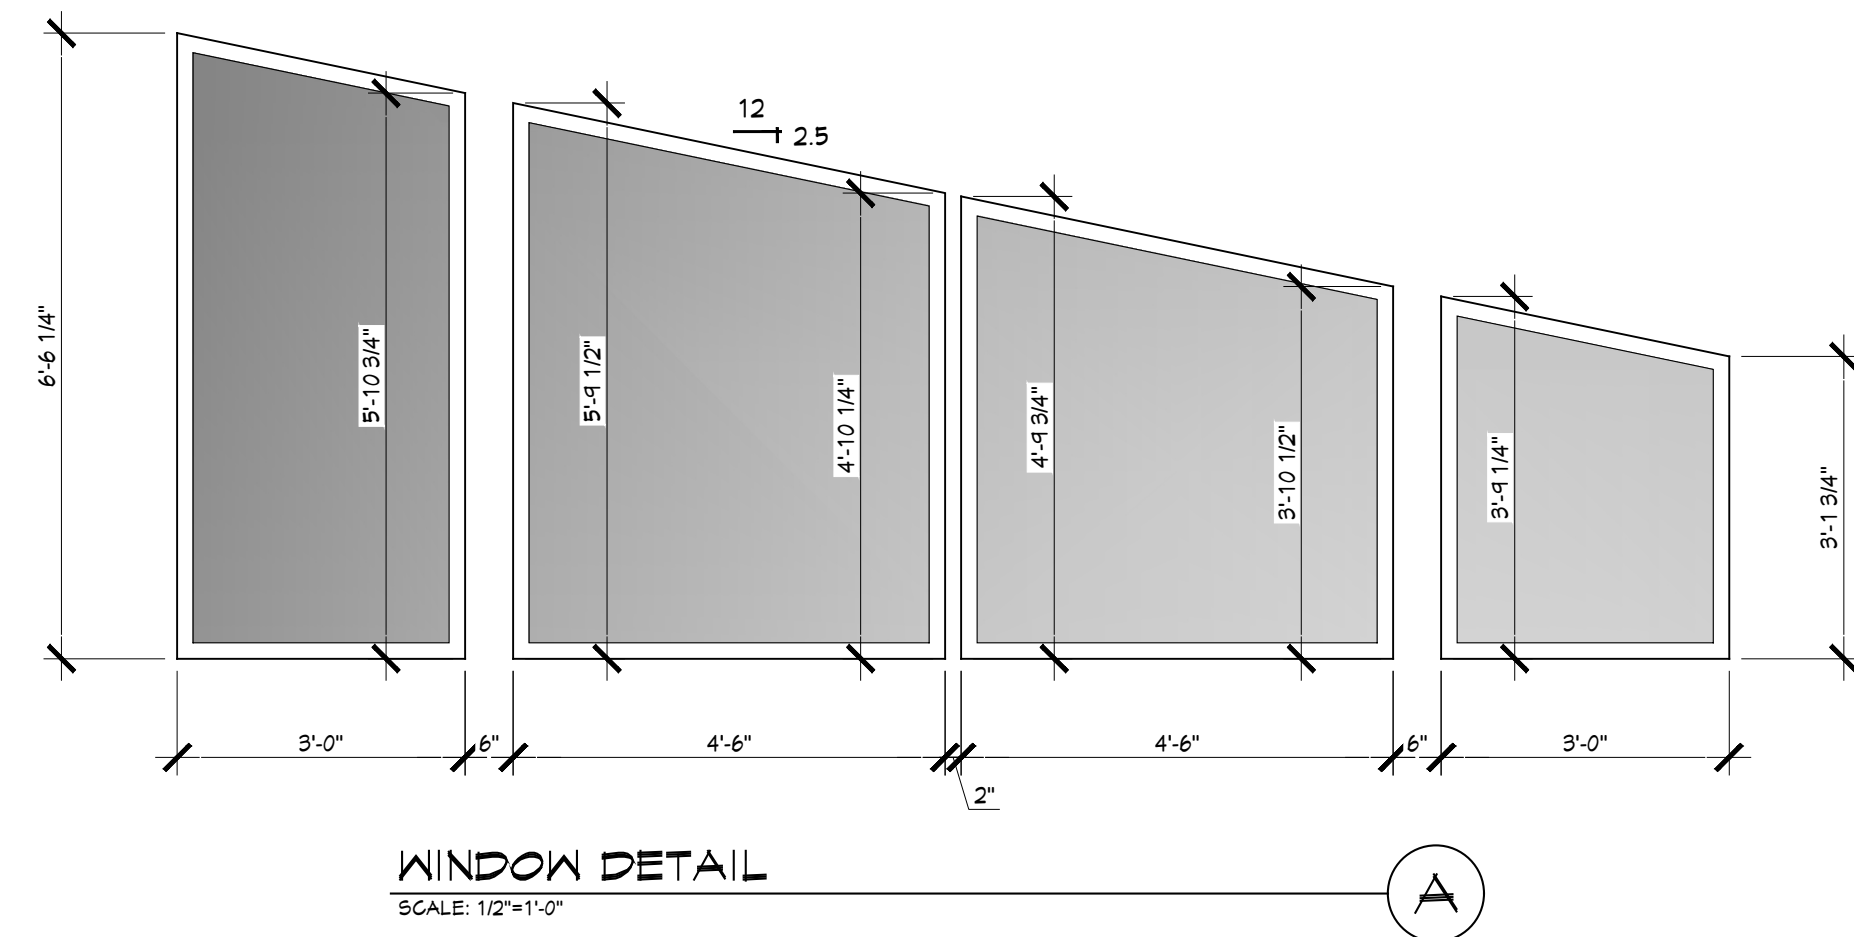


| | | |
|---|--|---|
| <p>Date 10-29-25 Sheet A-5</p> | <p>A Custom Home For The Gant Family Burkett Road, Boone NC</p> | <p>RCO CONSTRUCTION, INC. (336) 838-6701</p> |
|---|--|---|

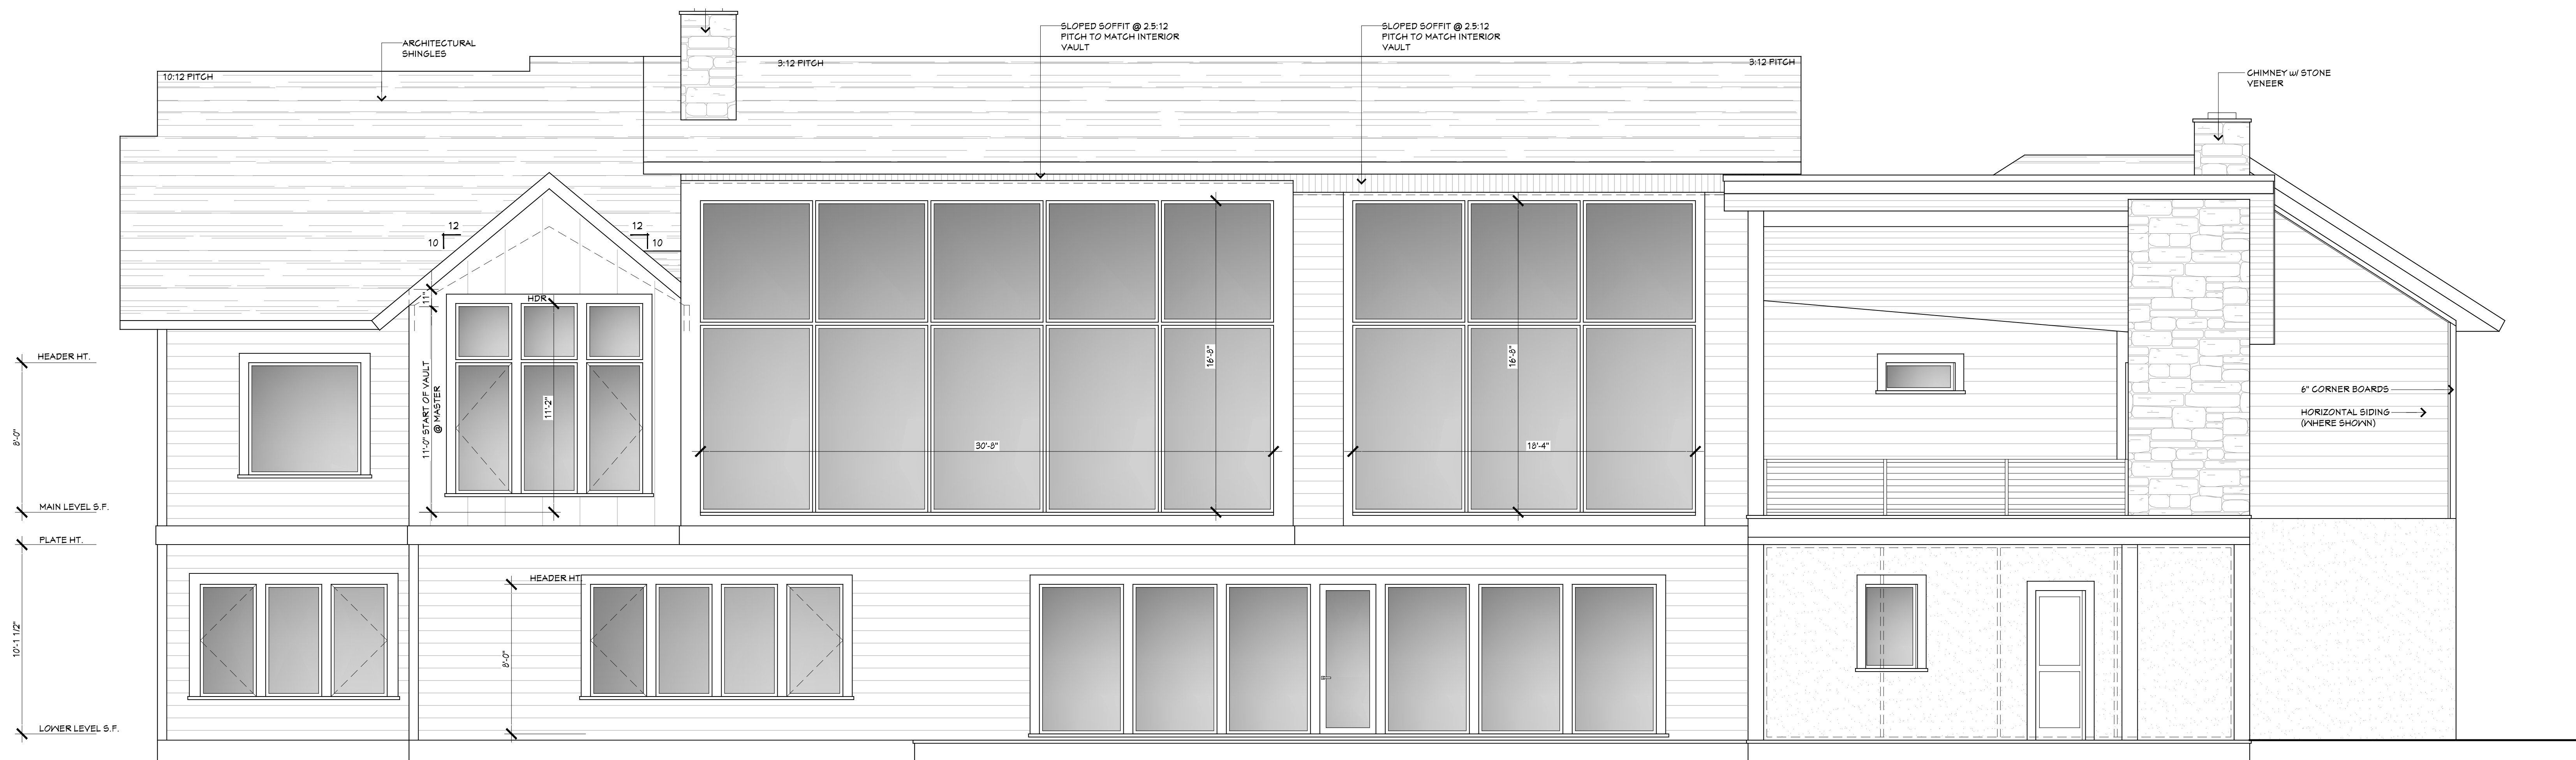

REAR ELEVATION
 SCALE : 1/4" = 1'-0"

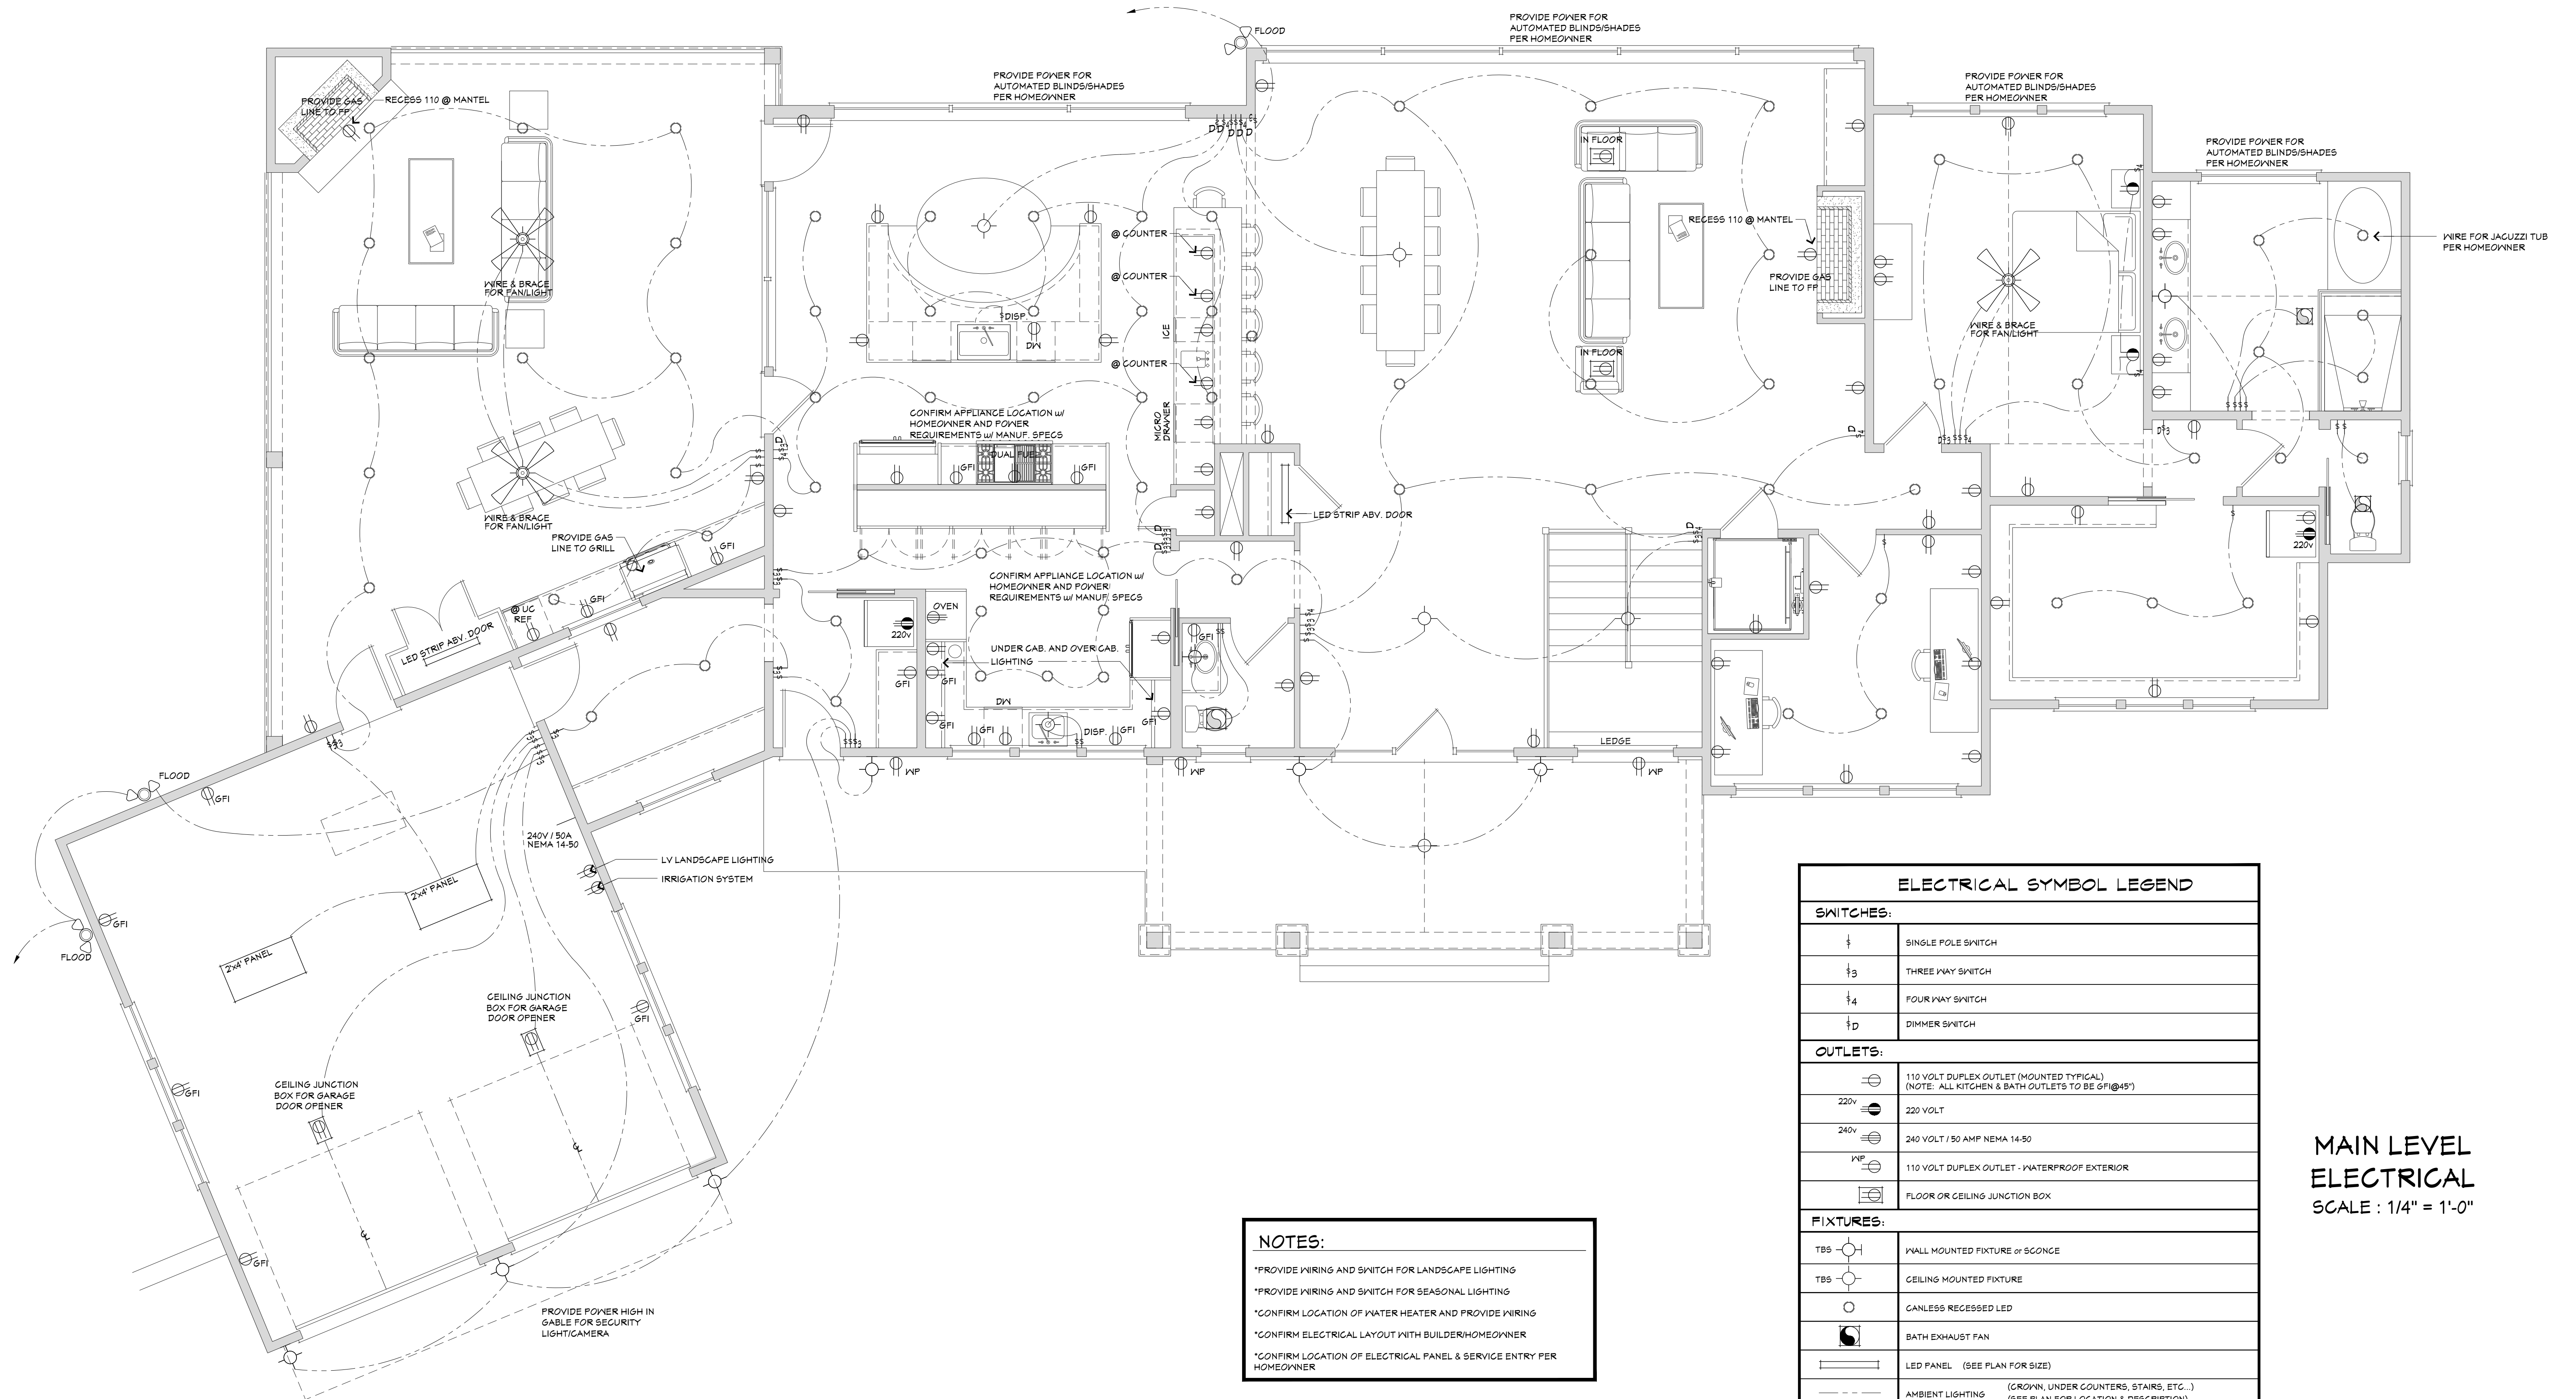

MAIN LEVEL
ELECTRICAL
SCALE : 1/4" = 1'-0"

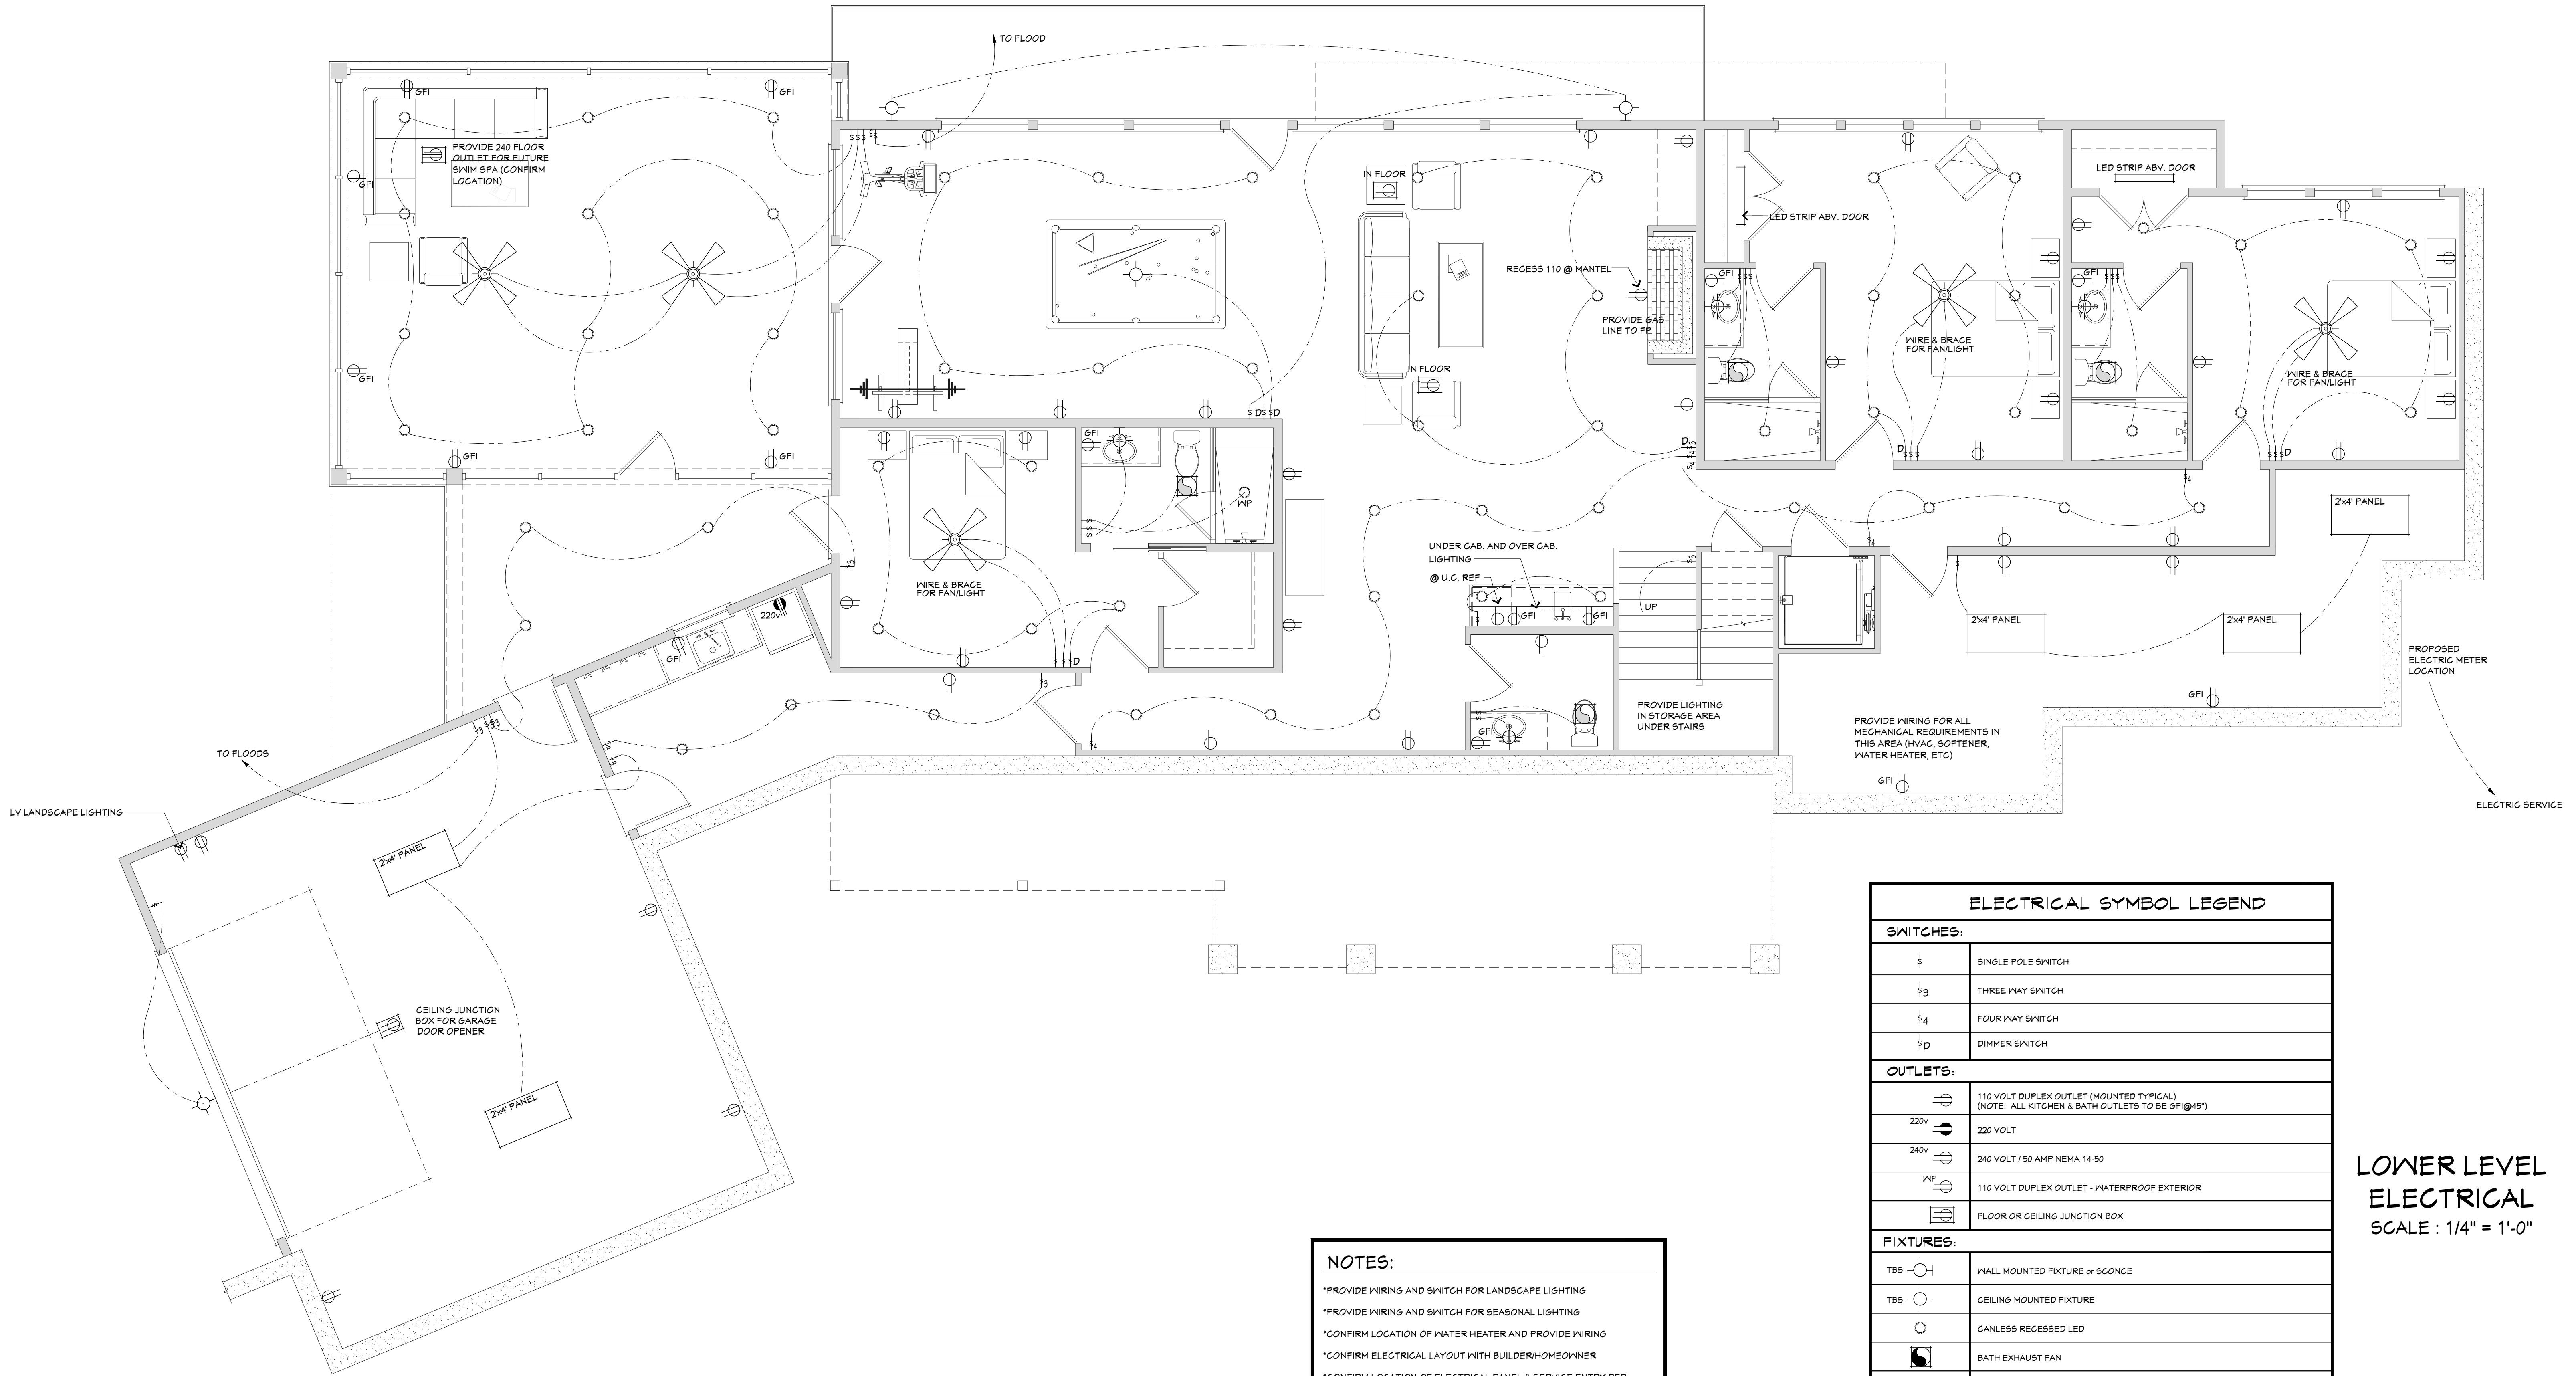

NOTES:

- *PROVIDE WIRING AND SWITCH FOR LANDSCAPE LIGHTING
- *PROVIDE WIRING AND SWITCH FOR SEASONAL LIGHTING
- *CONFIRM LOCATION OF WATER HEATER AND PROVIDE WIRING
- *CONFIRM ELECTRICAL LAYOUT WITH BUILDER/HOMEOWNER
- *CONFIRM LOCATION OF ELECTRICAL PANEL & SERVICE ENTRY PER HOMEOWNER

| ELECTRICAL SYMBOL LEGEND | |
|--------------------------|--|
| SWITCHES: | |
| | SINGLE POLE SWITCH |
| | THREE WAY SWITCH |
| | FOUR WAY SWITCH |
| | DIMMER SWITCH |
| OUTLETS: | |
| | 110 VOLT DUPLEX OUTLET (MOUNTED TYPICAL) (NOTE: ALL KITCHEN & BATH OUTLETS TO BE GFI@45") |
| | 220 VOLT |
| | 240 VOLT / 50 AMP NEMA 14-50 |
| | 110 VOLT DUPLEX OUTLET - WATERPROOF EXTERIOR |
| | FLOOR OR CEILING JUNCTION BOX |
| FIXTURES: | |
| | WALL MOUNTED FIXTURE or SCONCE |
| | CEILING MOUNTED FIXTURE |
| | CANLESS RECESSED LED |
| | BATH EXHAUST FAN |
| | LED PANEL (SEE PLAN FOR SIZE) |
| | AMBIENT LIGHTING (CROWN, UNDER COUNTERS, STAIRS, ETC...) (SEE PLAN FOR LOCATION & DESCRIPTION) |
| | CEILING FAN & LIGHT COMBO (WIRE & BRACE) |

**LOWER LEVEL
ELECTRICAL**
SCALE : 1/4" = 1'-0"